




- APPROVAL STAMP:
- NOTES:
- 1.) ALL DIMENSIONS TO BE VERIFIED BY CONTRACTOR ON SITE PRIOR TO COMMENCEMENT OF ANY WORK.
 - 2.) DO NOT SCALE THIS DRAWING FOR THE PURPOSE OF MEASUREMENT. ONLY SCALE DIMENSIONS WHERE SPECIFICALLY INSTRUCTED TO DO SO.
 - 3.) ALL MEASUREMENTS ARE IN MILLIMETERS UNLESS OTHERWISE SPECIFIED.
 - 4.) DIMENSIONS SHOWN ON THESE DRAWINGS ARE STRUCTURAL DIMENSIONS UNLESS CLEARLY NOTED OTHERWISE.
 - 5.) THIS DRAWING IS TO BE READ IN CONJUNCTION WITH ALL OTHER DRAWINGS, DETAIL AND SPECIFICATIONS. ANY DISCREPANCY TO BE IMMEDIATELY BROUGHT TO THE ATTENTION OF ARCHITECT PRIOR TO COMMENCING THE WORKS.

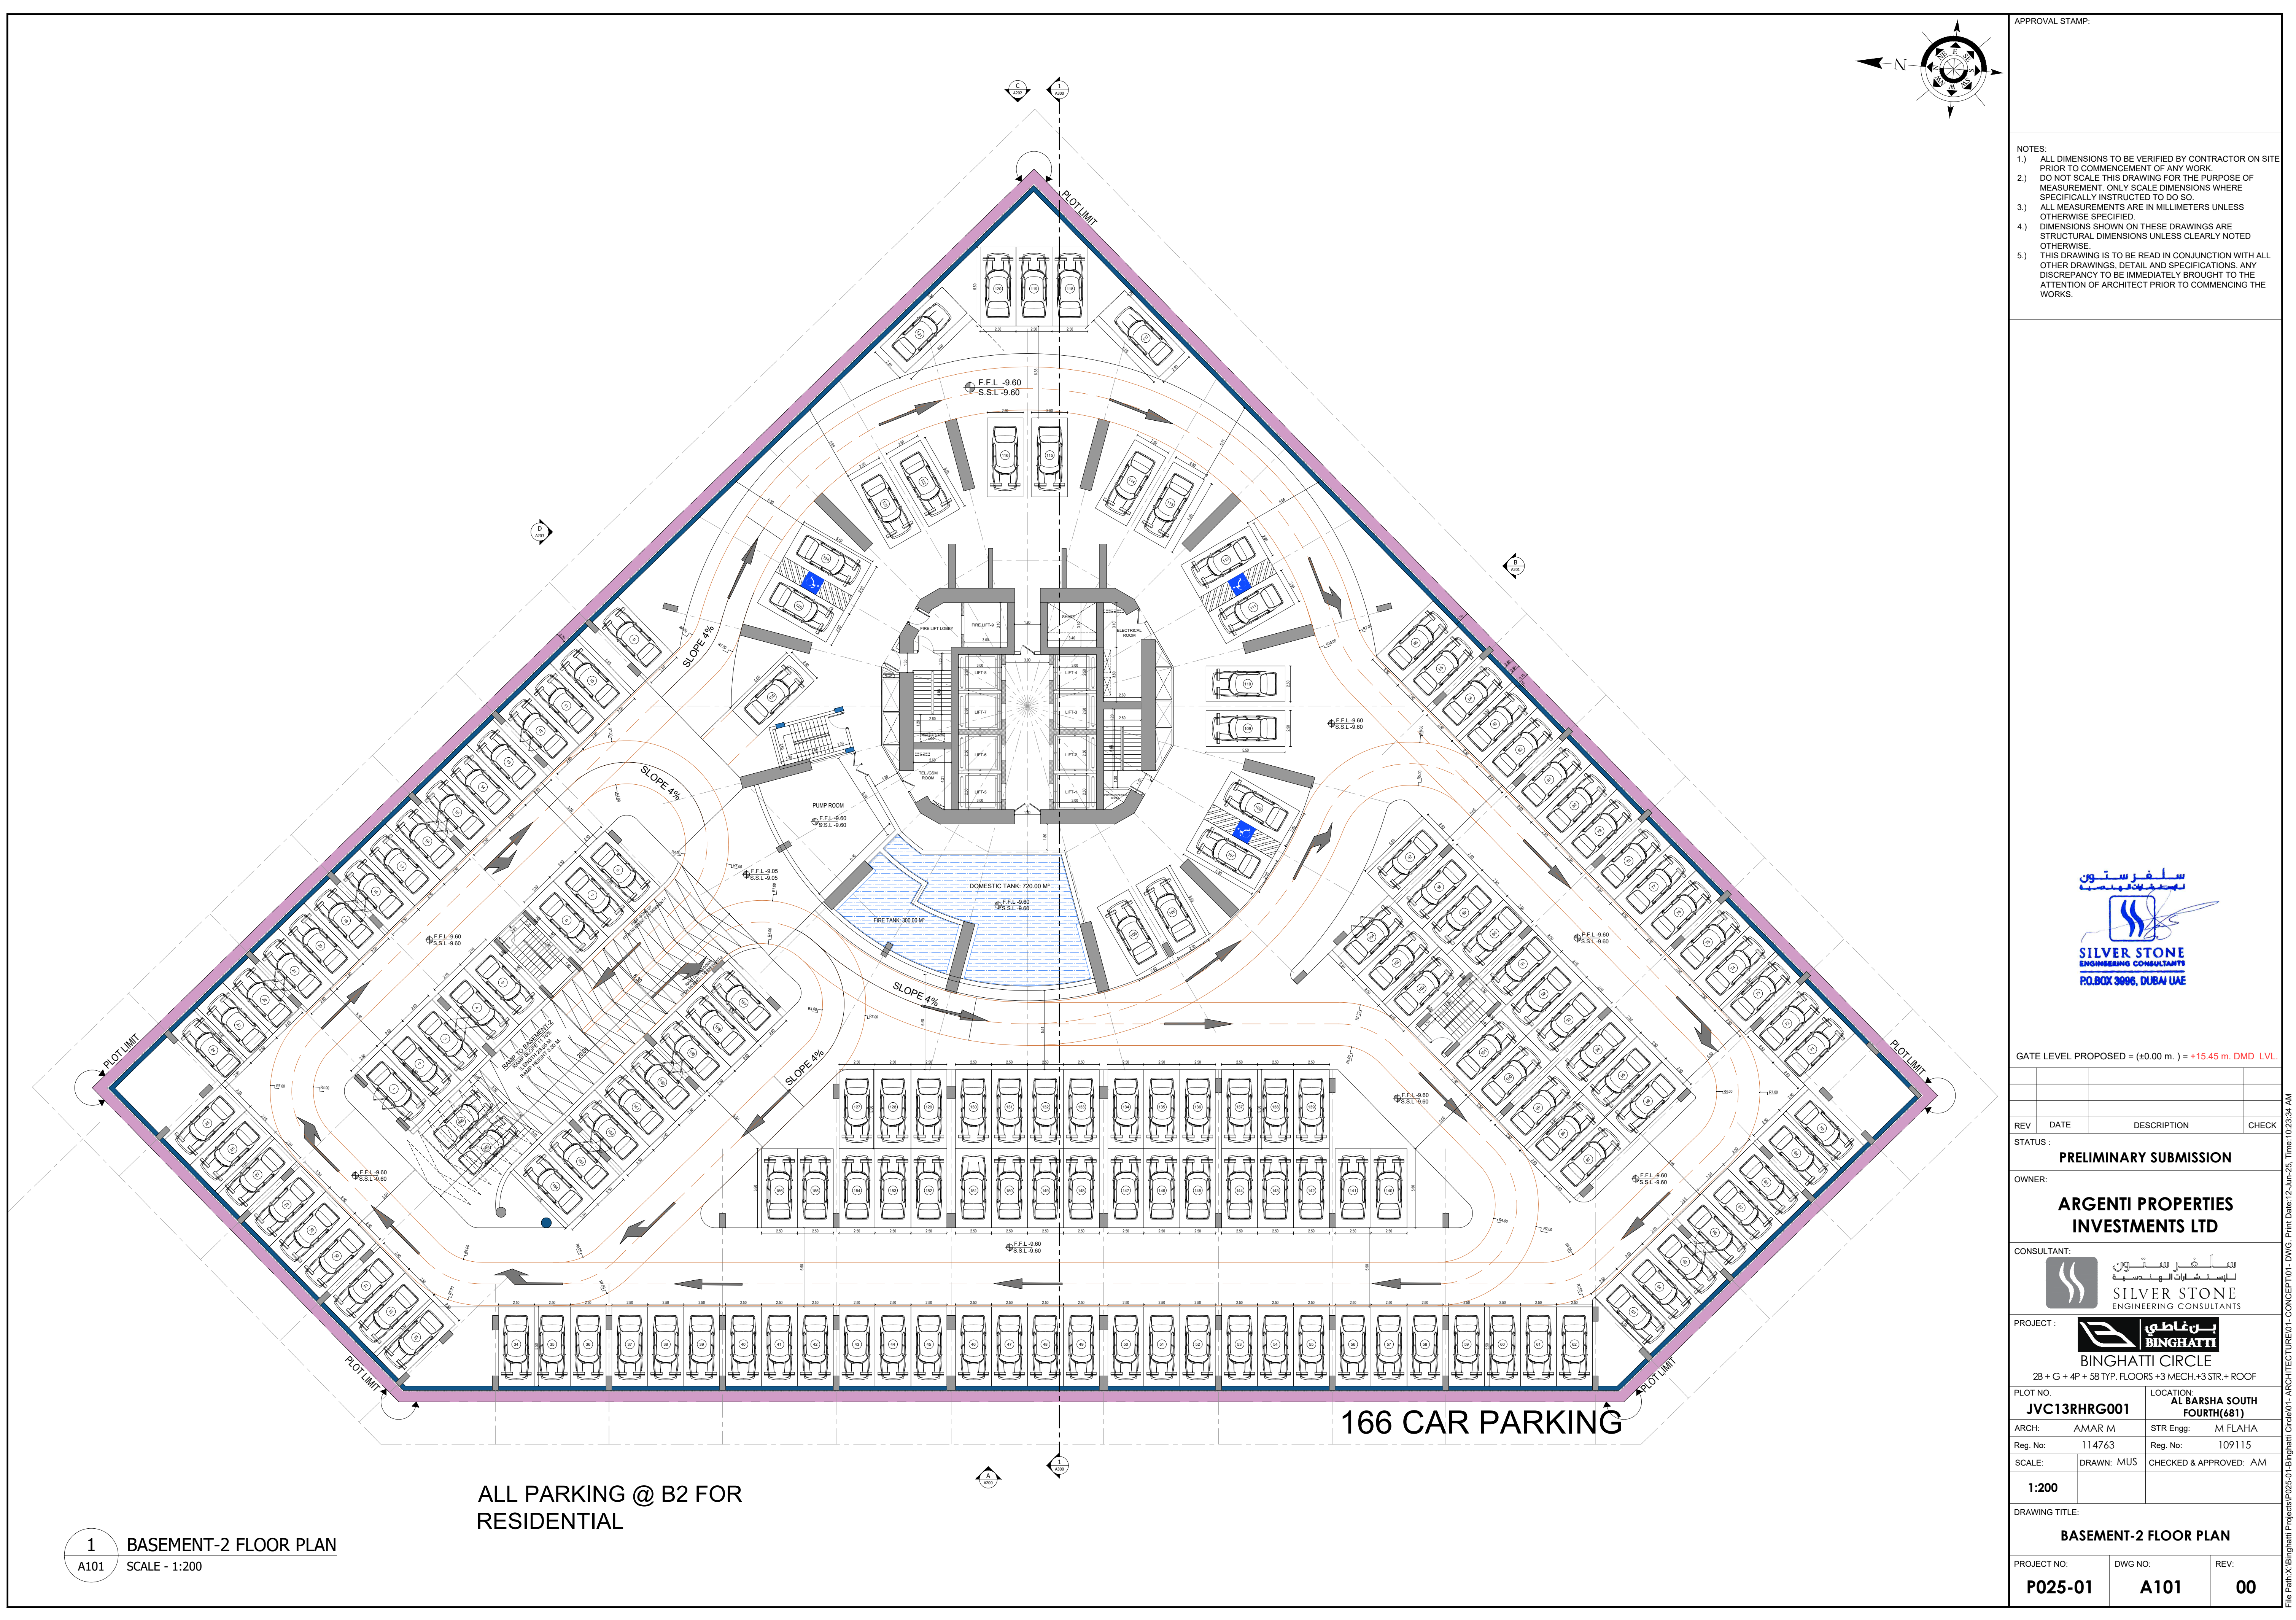

GATE LEVEL PROPOSED = (±0.00 m.) = +15.45 m. DMD LVL.

REV	DATE	DESCRIPTION	CHECK
-----	------	-------------	-------

STATUS: PRELIMINARY SUBMISSION

OWNER: ARGENTI PROPERTIES INVESTMENTS LTD



PROJECT: BINGHATTI CIRCLE
2B + G + 4P + S8 TYP. FLOORS +3 MECH.+3 STR.+ ROOF

PLOT NO: JVC13RHRG001	LOCATION: AL BARSHA SOUTH FOURTH(681)
ARCH: AMAR M	STR Engg: M FLAHA
Reg. No: 114763	Reg. No: 109115
SCALE: 1:200	DRAWN: MUS
CHECKED & APPROVED: AM	

DRAWING TITLE: BASEMENT-2 FLOOR PLAN


PROJECT NO: P025-01	DWG NO: A101	REV: 00
---------------------	--------------	---------

1 BASEMENT-2 FLOOR PLAN
A101 SCALE - 1:200

ALL PARKING @ B2 FOR
RESIDENTIAL

166 CAR PARKING

File Path: X:\Binghatti Project\2025-01-Binghatti Circle\01- ARCHITECTURE\01- CONCEPT\01- DWG- Print Date: 12-Jun-25, Time: 10:23:34 AM

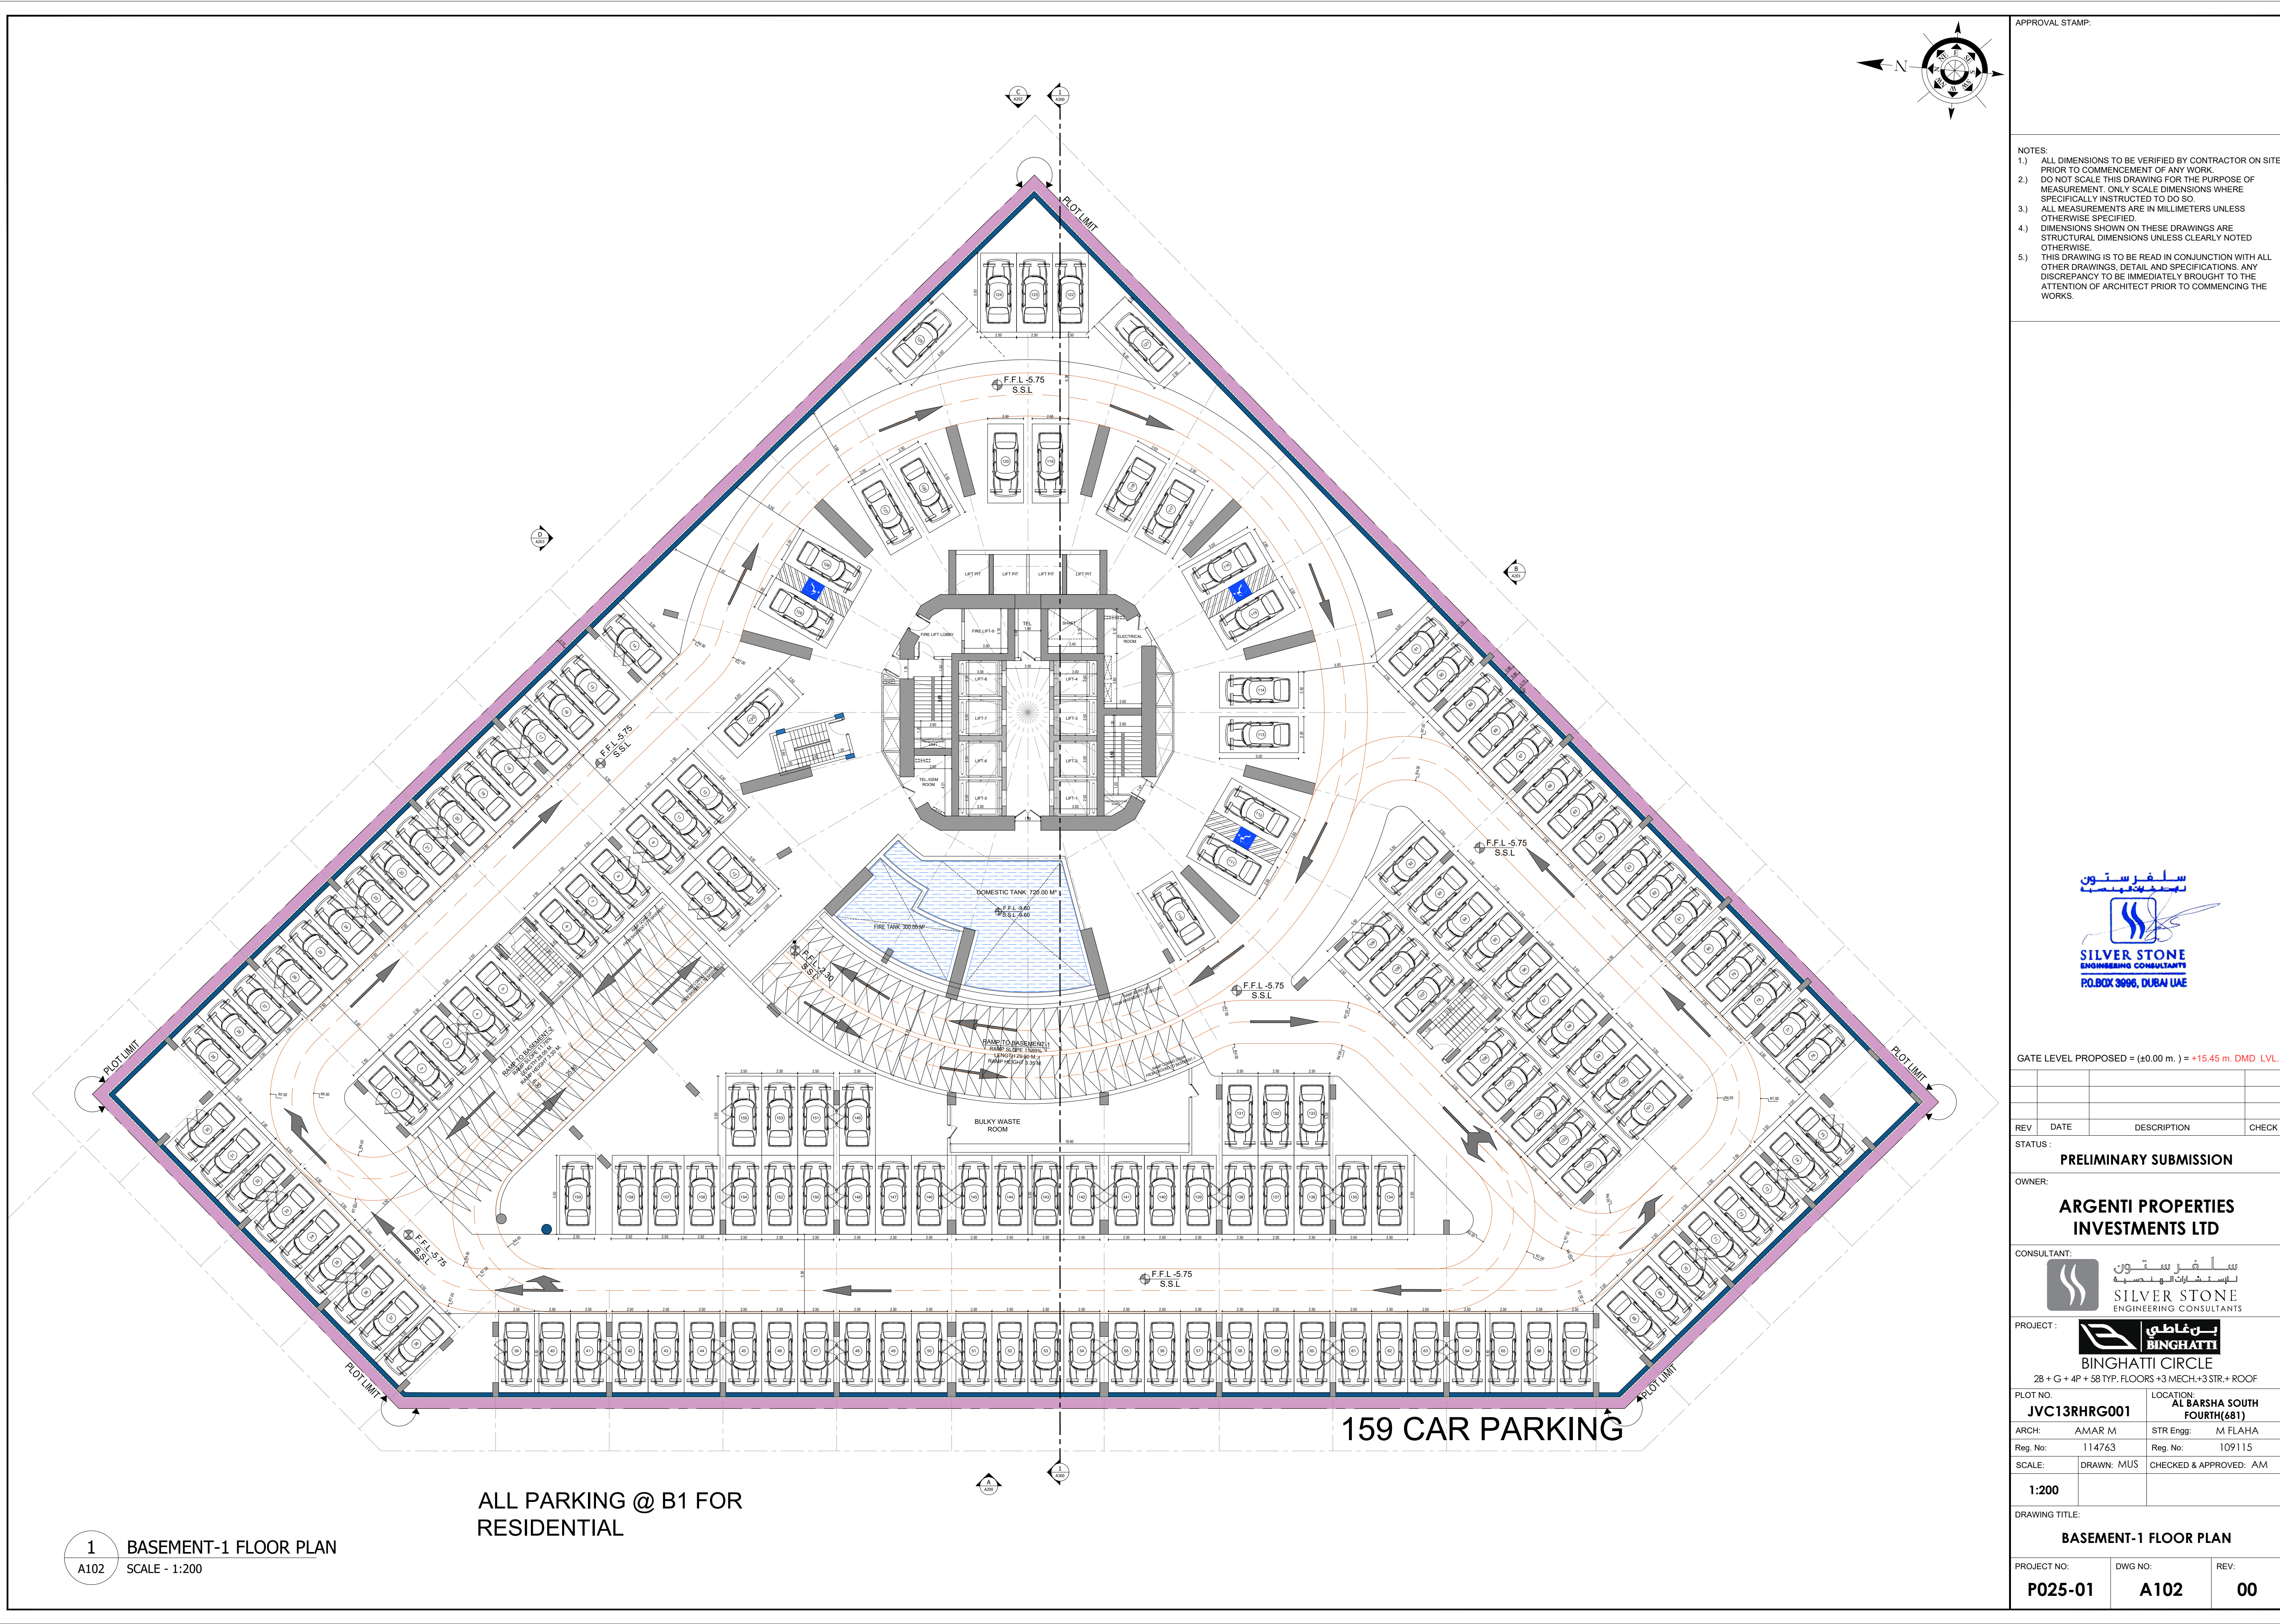

APPROVAL STAMP:

NOTES:

- 1.) ALL DIMENSIONS TO BE VERIFIED BY CONTRACTOR ON SITE PRIOR TO COMMENCEMENT OF ANY WORK.
- 2.) DO NOT SCALE THIS DRAWING FOR THE PURPOSE OF MEASUREMENT. ONLY SCALE DIMENSIONS WHERE SPECIFICALLY INSTRUCTED TO DO SO.
- 3.) ALL MEASUREMENTS ARE IN MILLIMETERS UNLESS OTHERWISE SPECIFIED.
- 4.) DIMENSIONS SHOWN ON THESE DRAWINGS ARE STRUCTURAL DIMENSIONS UNLESS CLEARLY NOTED OTHERWISE.
- 5.) THIS DRAWING IS TO BE READ IN CONJUNCTION WITH ALL OTHER DRAWINGS, DETAIL AND SPECIFICATIONS. ANY DISCREPANCY TO BE IMMEDIATELY BROUGHT TO THE ATTENTION OF ARCHITECT PRIOR TO COMMENCING THE WORKS.



GATE LEVEL PROPOSED = (±0.00 m.) = +15.45 m. DMD LVL.

REV	DATE	DESCRIPTION	CHECK

STATUS: PRELIMINARY SUBMISSION

OWNER: ARGENTI PROPERTIES INVESTMENTS LTD

CONSULTANT: SILVER STONE ENGINEERING CONSULTANTS

PROJECT: BINGHATTI CIRCLE

2B + G + 4P + S8 TYP. FLOORS +3 MECH.+3 STR.+ ROOF

PLOT NO: JVC13RHRG001	LOCATION: AL BARSHA SOUTH FOURTH(681)
ARCH: AMAR M	STR Engg: M FLAHA
Reg. No: 114763	Reg. No: 109115
SCALE: 1:200	DRAWN: MUS
	CHECKED & APPROVED: AM

DRAWING TITLE: BASEMENT-1 FLOOR PLAN



PROJECT NO: P025-01	DWG NO: A102	REV: 00
---------------------	--------------	---------

1 BASEMENT-1 FLOOR PLAN
A102 SCALE - 1:200

ALL PARKING @ B1 FOR
RESIDENTIAL

159 CAR PARKING

File Path: X:\Binghatti Project\2025-01-Binghatti Circle\01- ARCHITECTURE\01- CONCEPT\01- DWG- Print Date: 12-Jun-25, Time: 10:23:34 AM

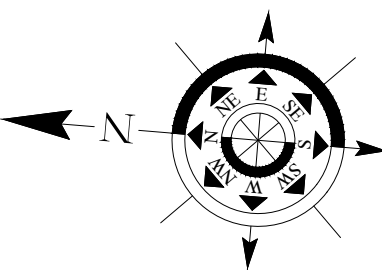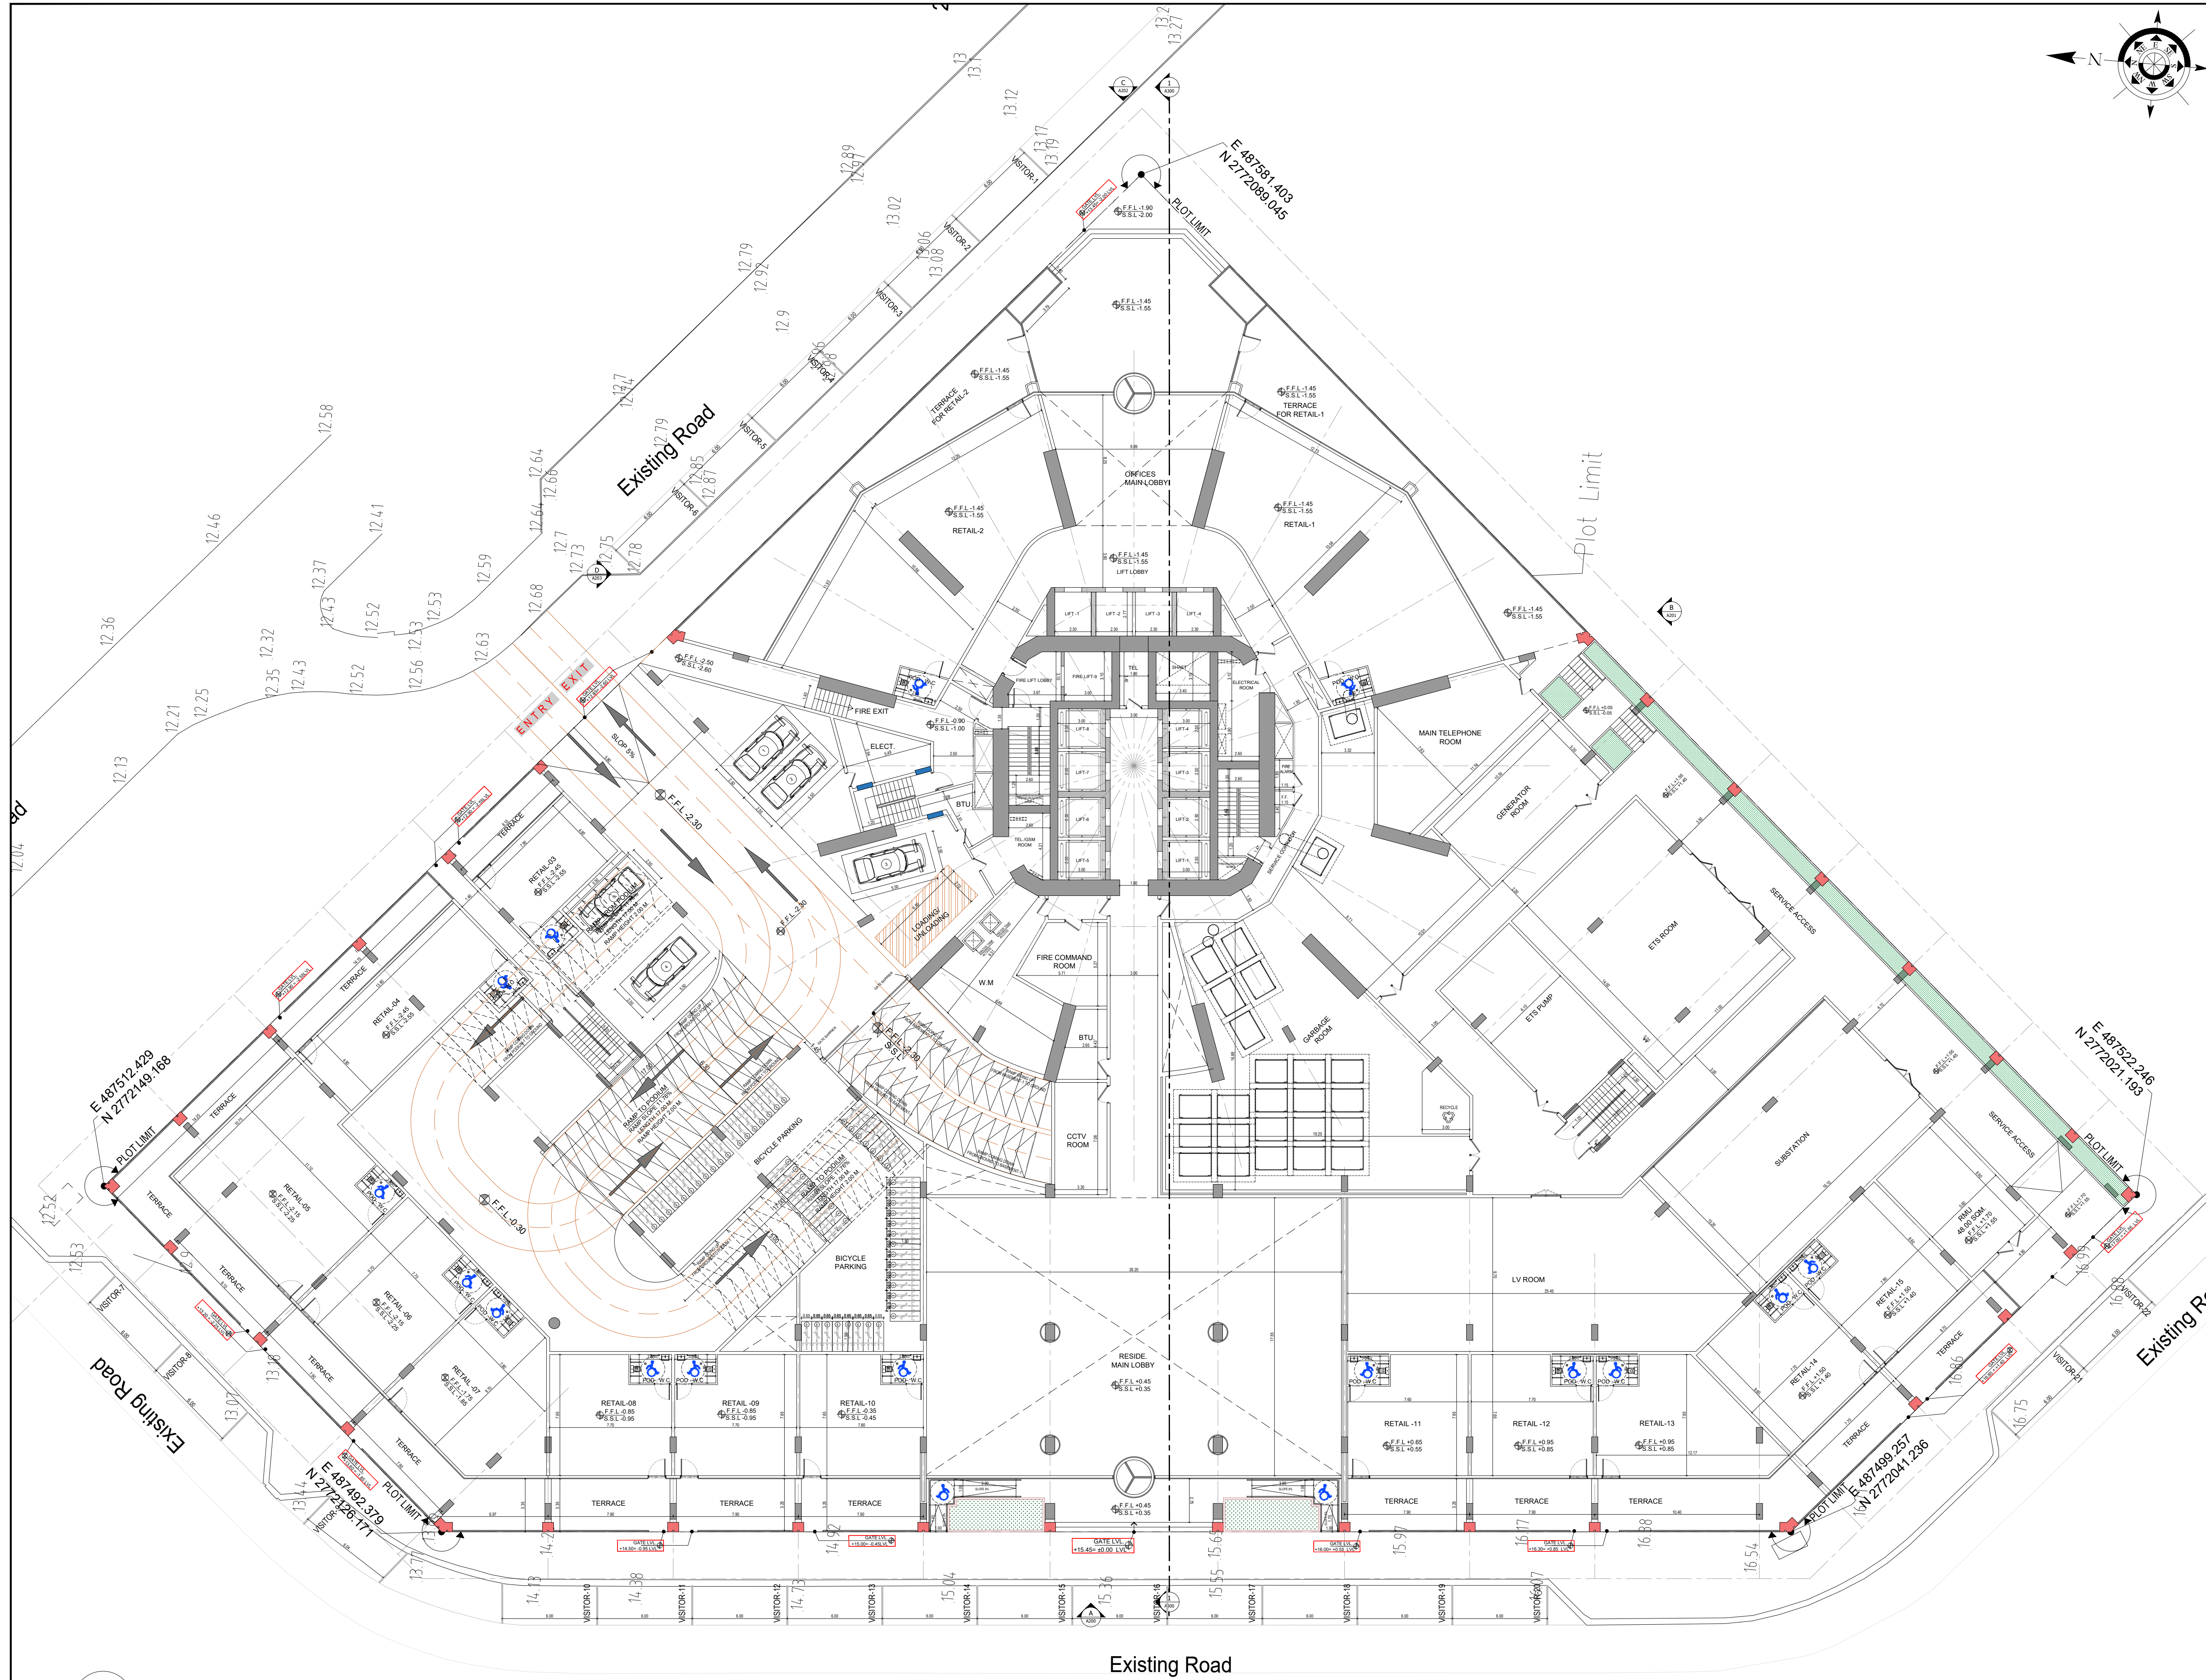

- APPROVAL STAMP:
- NOTES:
- 1.) ALL DIMENSIONS TO BE VERIFIED BY CONTRACTOR ON SITE PRIOR TO COMMENCEMENT OF ANY WORK.
 - 2.) DO NOT SCALE THIS DRAWING FOR THE PURPOSE OF MEASUREMENT. ONLY SCALE DIMENSIONS WHERE SPECIFICALLY INSTRUCTED TO DO SO.
 - 3.) ALL MEASUREMENTS ARE IN MILLIMETERS UNLESS OTHERWISE SPECIFIED.
 - 4.) DIMENSIONS SHOWN ON THESE DRAWINGS ARE STRUCTURAL DIMENSIONS UNLESS CLEARLY NOTED OTHERWISE.
 - 5.) THIS DRAWING IS TO BE READ IN CONJUNCTION WITH ALL OTHER DRAWINGS, DETAIL AND SPECIFICATIONS. ANY DISCREPANCY TO BE IMMEDIATELY BROUGHT TO THE ATTENTION OF ARCHITECT PRIOR TO COMMENCING THE WORKS.



GATE LEVEL PROPOSED = (±0.00 m.) = +15.45 m. DMD LVL.


REV	DATE	DESCRIPTION	CHECK
STATUS :			
PRELIMINARY SUBMISSION			
OWNER:			
ARGENTI PROPERTIES INVESTMENTS LTD			
CONSULTANT:			
			
PROJECT :			
			
BINGHATTI CIRCLE			
2B + G + 4P + S8 TYP. FLOORS +3 MECH.+3 STR.+ ROOF			
PLOT NO:		LOCATION:	
JVC13RHRG001		AL BARSHA SOUTH FOURTH(681)	
ARCH: AMAR M		STR Engg: M FLAHA	
Reg. No: 114763		Reg. No: 109115	
SCALE:		CHECKED & APPROVED: AM	
DRAWN: MUS			
1:200			
DRAWING TITLE:			
GROUND FLOOR PLAN			
PROJECT NO:		DWG NO:	
P025-01		A103	
		REV:	
		00	

1 GROUND FLOOR PLAN
A103 SCALE - 1:200

Existing Road

5 CAR PARKING

File Path: X:\Binghatti Project\2025-01-Binghatti Circle\01- ARCHITECTURE\01- CONCEPT\01- DWG- Print Date: 12-Jun-25, Time: 10:23:34 AM

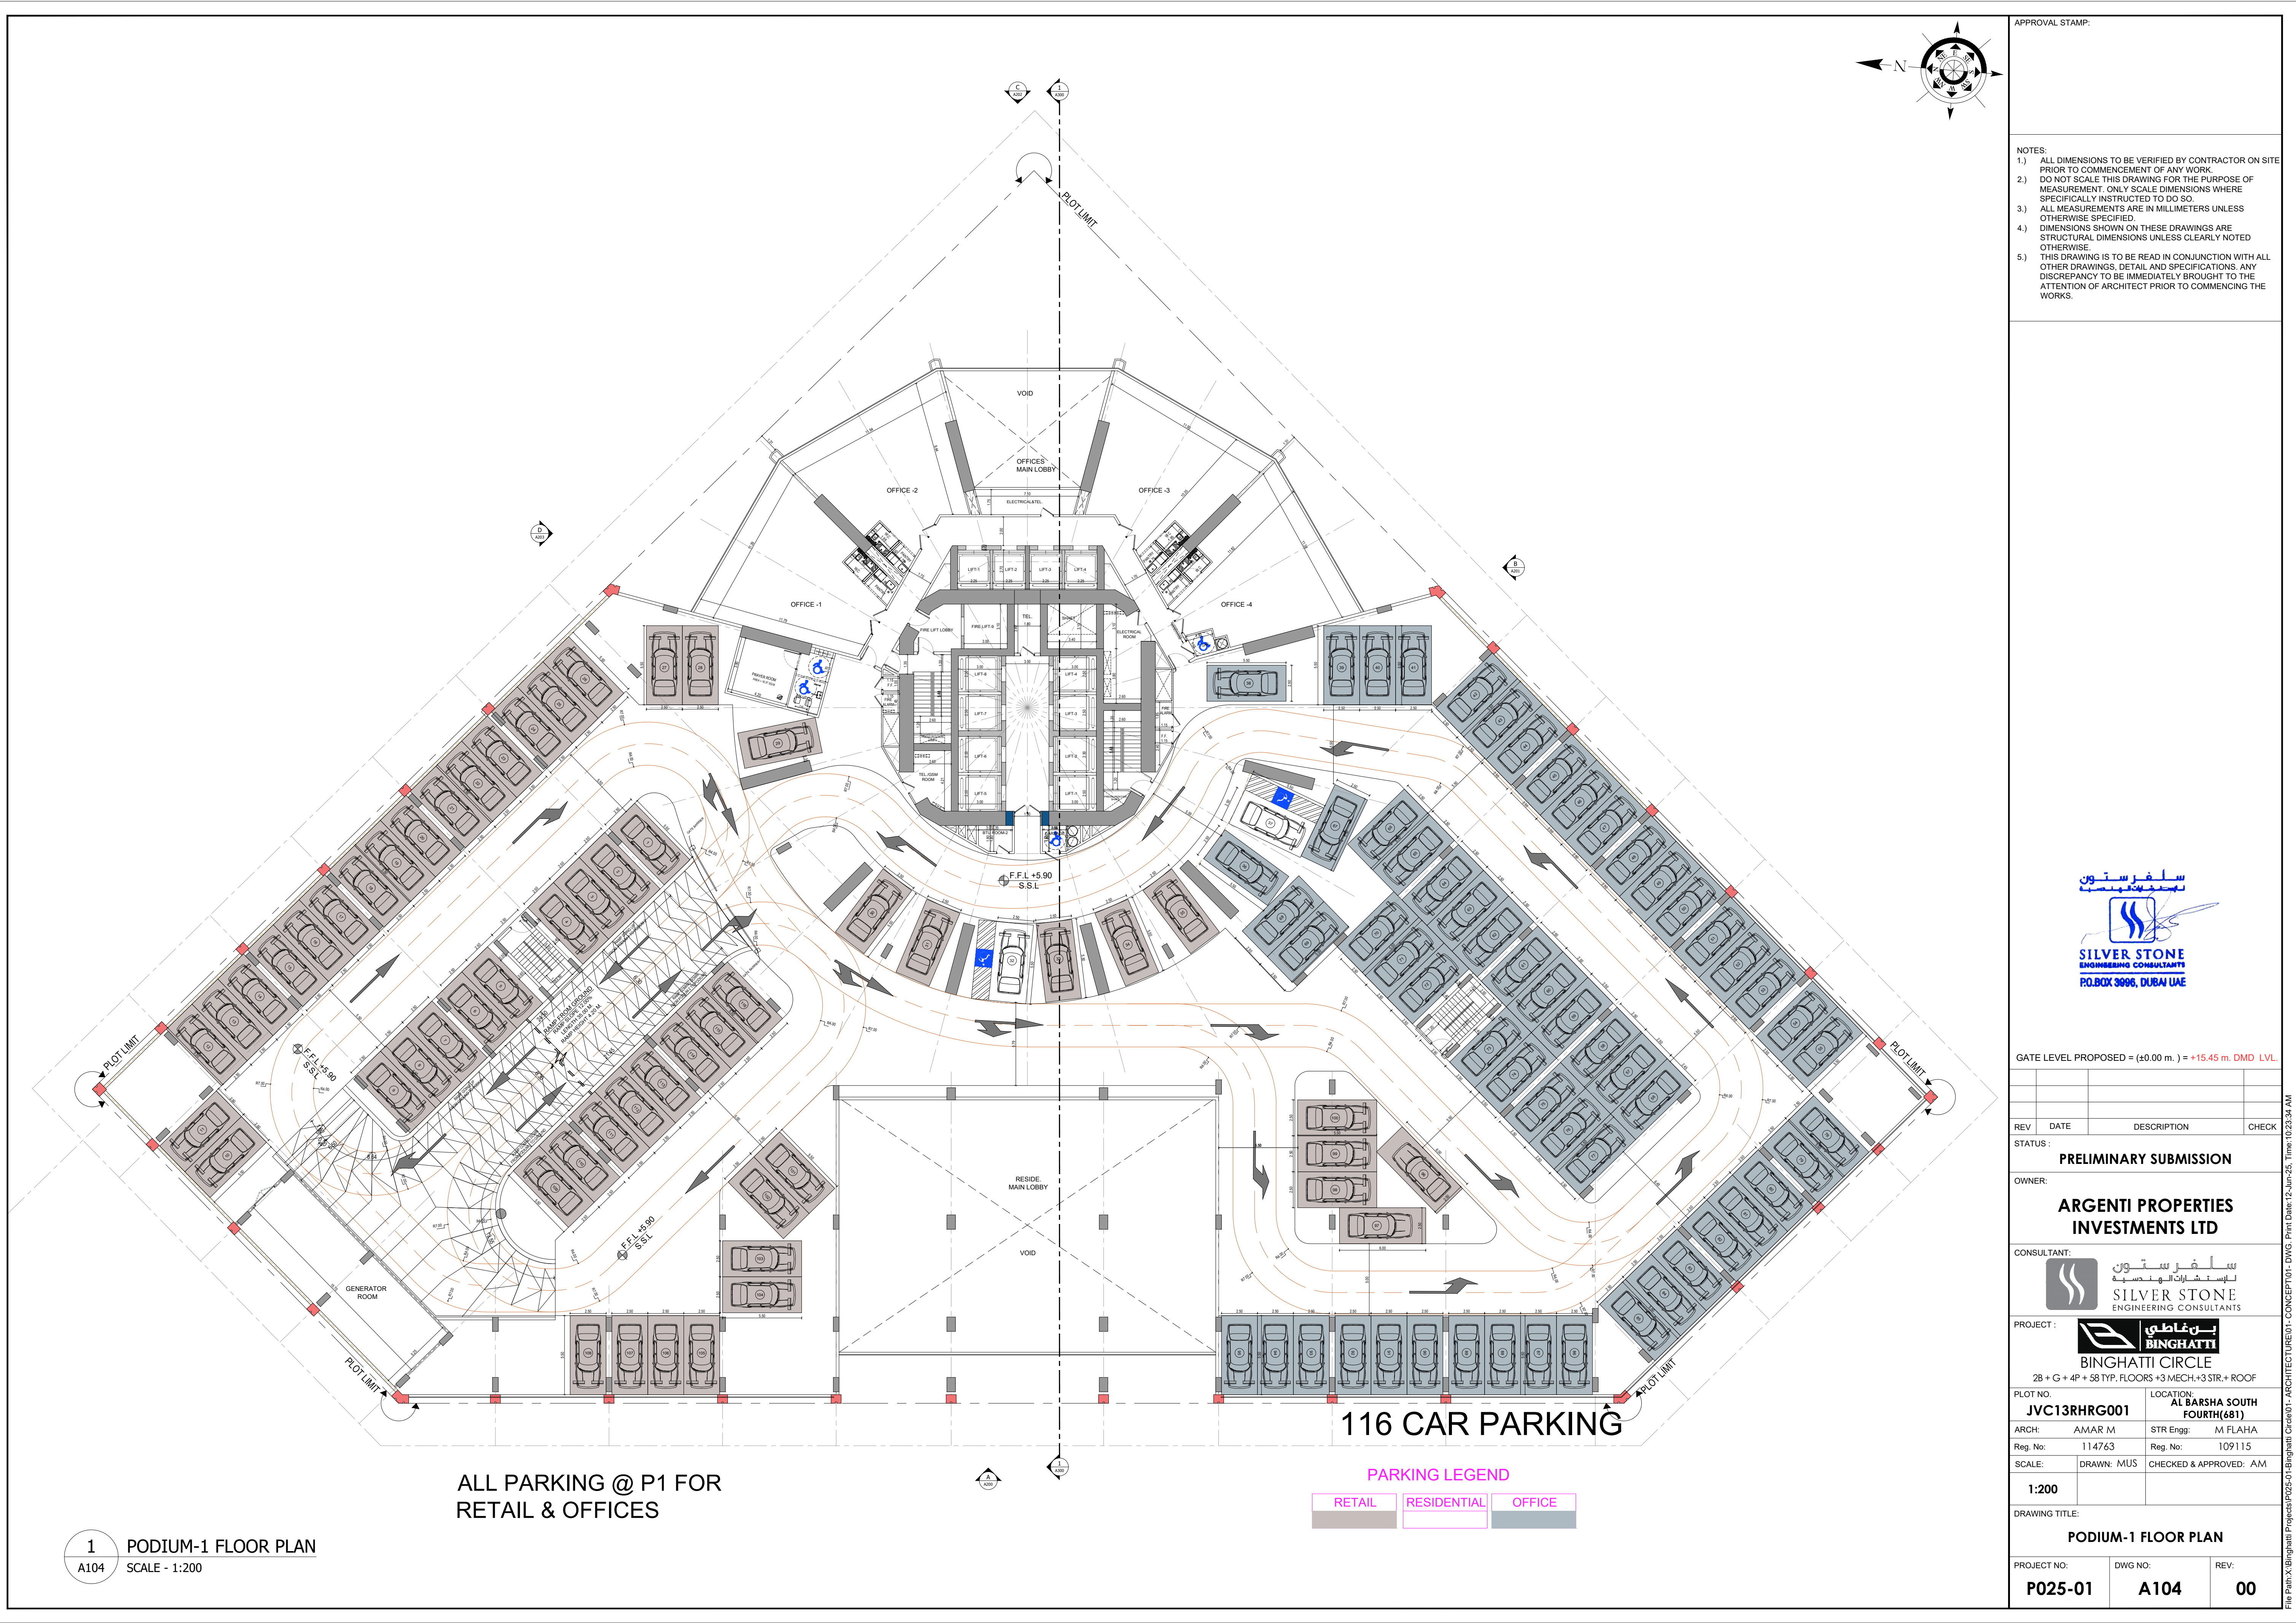

APPROVAL STAMP:

NOTES:

- 1.) ALL DIMENSIONS TO BE VERIFIED BY CONTRACTOR ON SITE PRIOR TO COMMENCEMENT OF ANY WORK.
- 2.) DO NOT SCALE THIS DRAWING FOR THE PURPOSE OF MEASUREMENT. ONLY SCALE DIMENSIONS WHERE SPECIFICALLY INSTRUCTED TO DO SO.
- 3.) ALL MEASUREMENTS ARE IN MILLIMETERS UNLESS OTHERWISE SPECIFIED.
- 4.) DIMENSIONS SHOWN ON THESE DRAWINGS ARE STRUCTURAL DIMENSIONS UNLESS CLEARLY NOTED OTHERWISE.
- 5.) THIS DRAWING IS TO BE READ IN CONJUNCTION WITH ALL OTHER DRAWINGS, DETAIL AND SPECIFICATIONS. ANY DISCREPANCY TO BE IMMEDIATELY BROUGHT TO THE ATTENTION OF ARCHITECT PRIOR TO COMMENCING THE WORKS.



GATE LEVEL PROPOSED = (±0.00 m.) = +15.45 m. DMD LVL.

REV	DATE	DESCRIPTION	CHECK
STATUS:			

PRELIMINARY SUBMISSION

OWNER:
ARGENTI PROPERTIES INVESTMENTS LTD


CONSULTANT:
SILVER STONE ENGINEERING CONSULTANTS

PROJECT:
BINGHATTI CIRCLE
2B + G + 4P + S8 TYP. FLOORS +3 MECH.+3 STR.+ ROOF

PLOT NO: JVC13RHRG001	LOCATION: AL BARSHA SOUTH FOURTH(681)
ARCH: AMAR M	STR Engg: M FLAHA
Reg. No: 114763	Reg. No: 109115
SCALE: 1:200	DRAWN: MUS CHECKED & APPROVED: AM

DRAWING TITLE:
PODIUM-1 FLOOR PLAN

PROJECT NO: P025-01	DWG NO: A104	REV: 00
-------------------------------	------------------------	-------------------

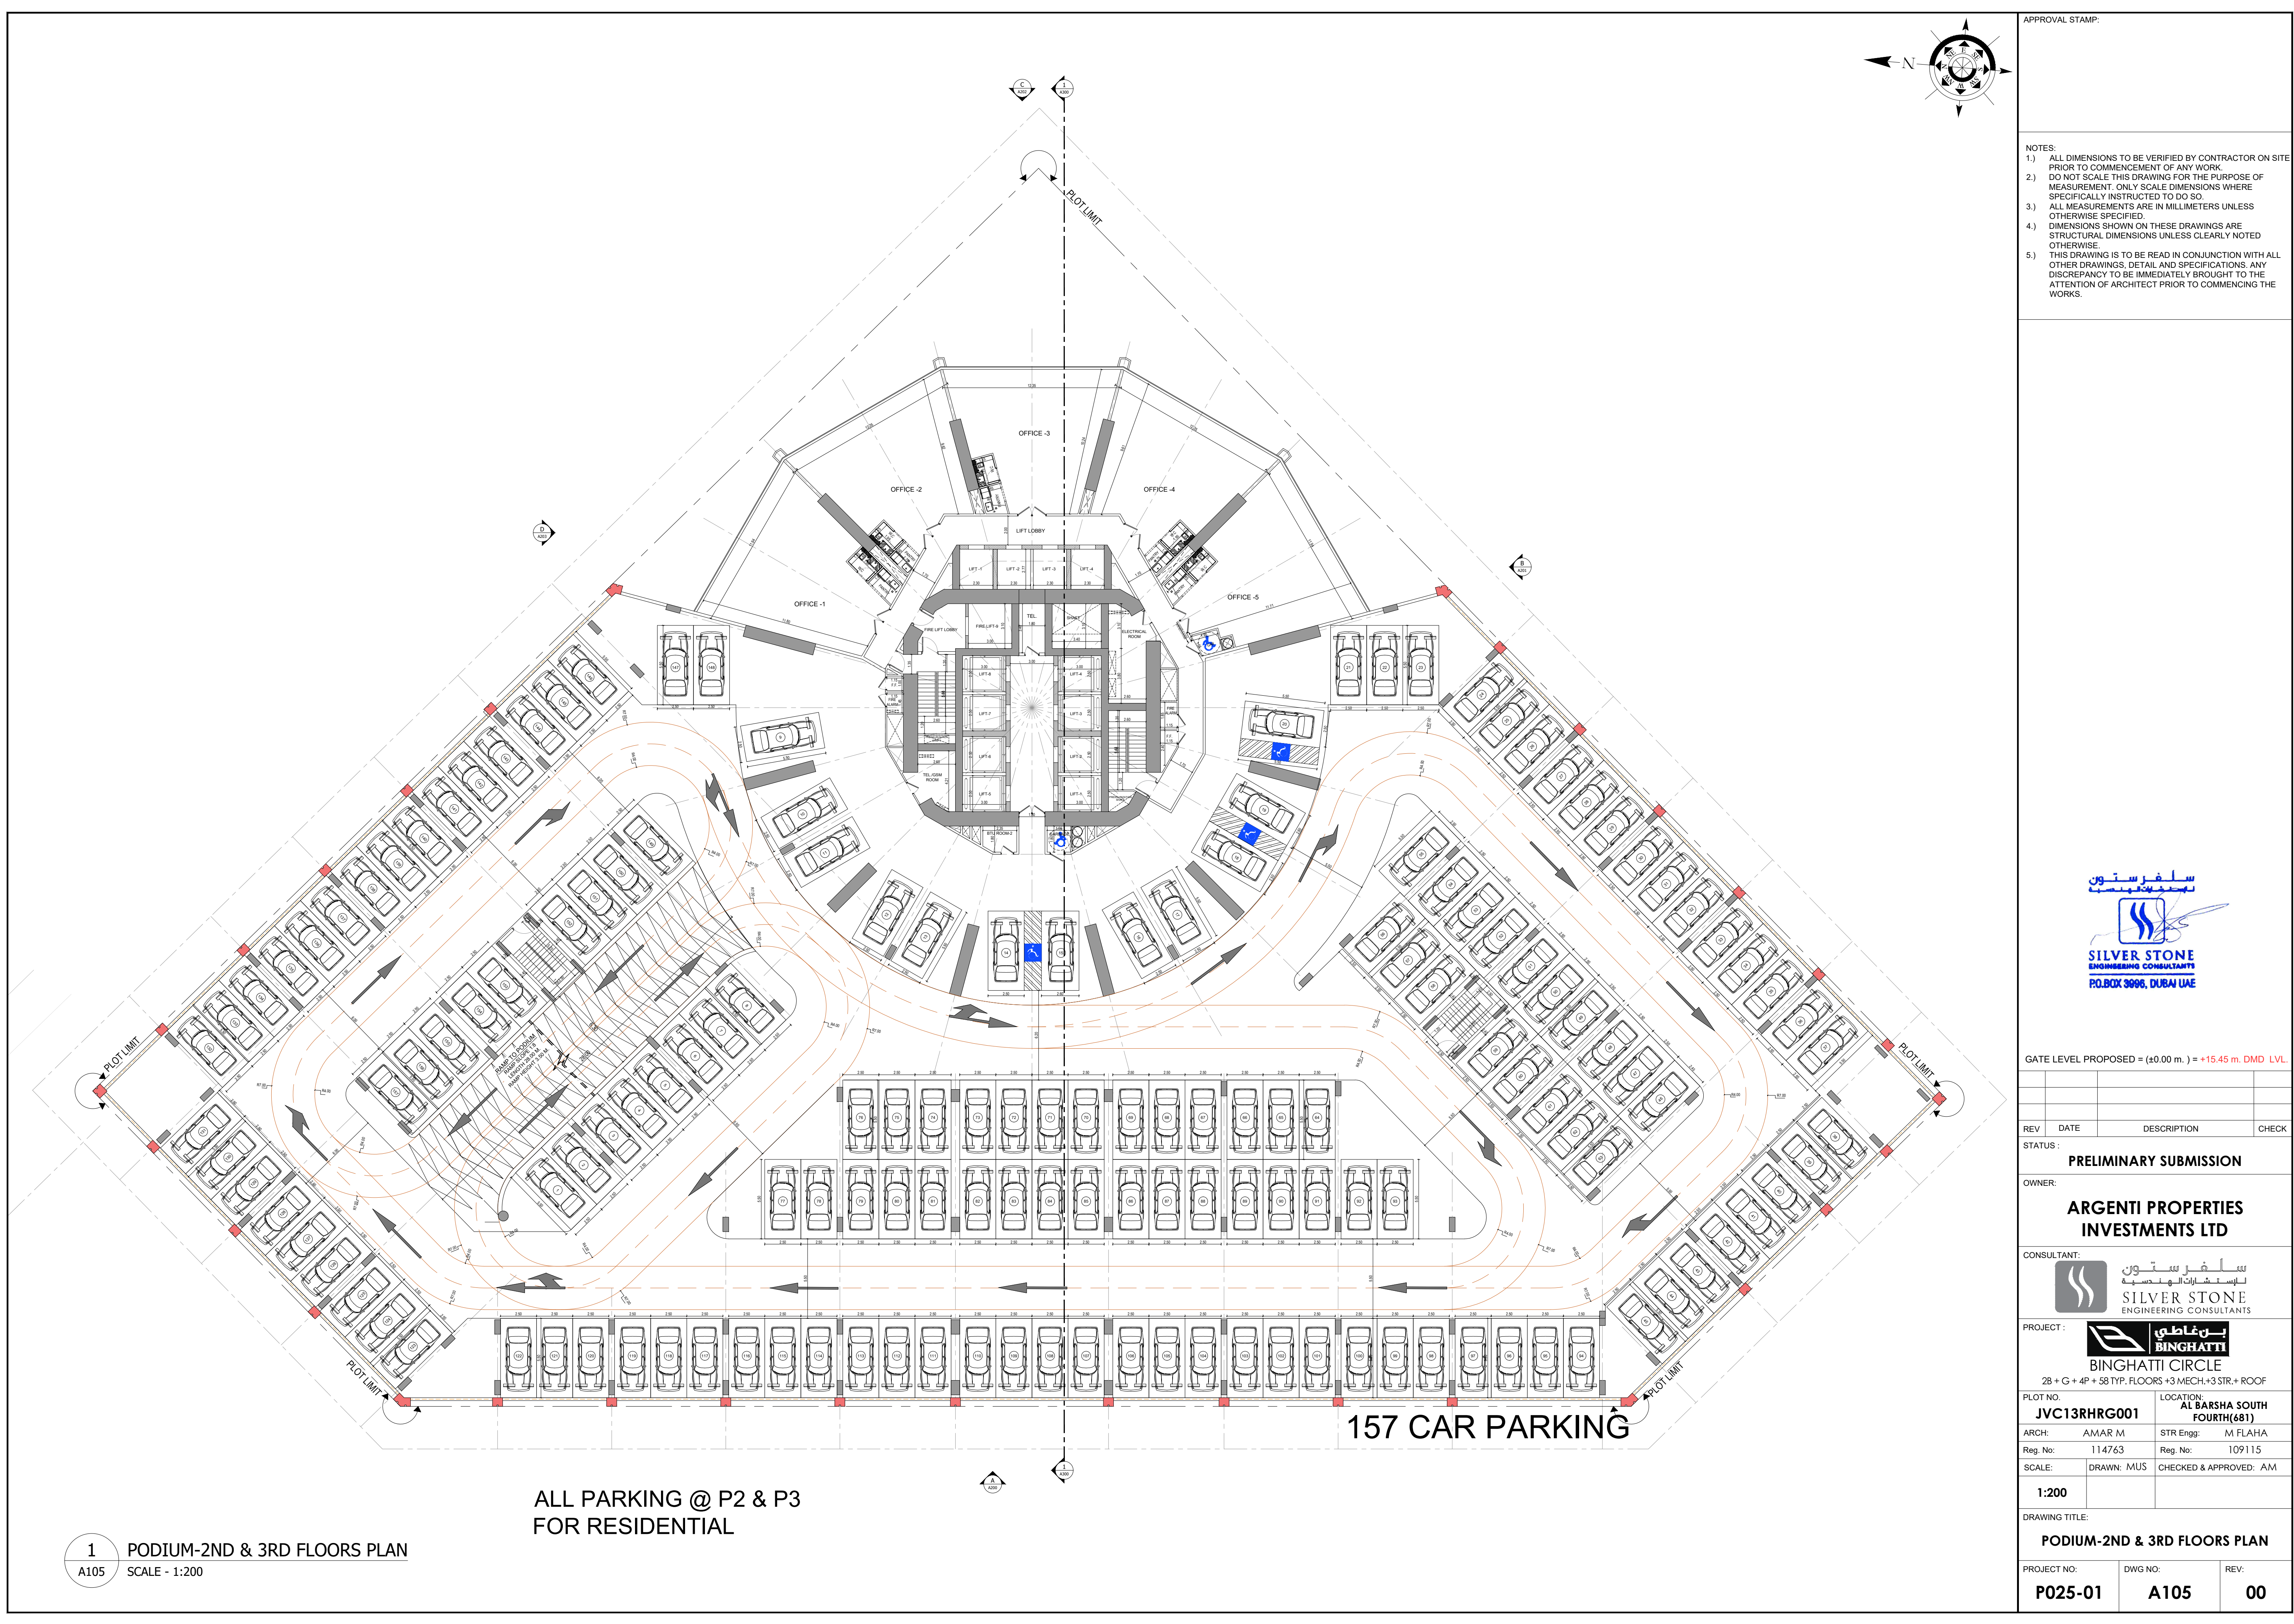

APPROVAL STAMP:

NOTES:

- 1.) ALL DIMENSIONS TO BE VERIFIED BY CONTRACTOR ON SITE PRIOR TO COMMENCEMENT OF ANY WORK.
- 2.) DO NOT SCALE THIS DRAWING FOR THE PURPOSE OF MEASUREMENT. ONLY SCALE DIMENSIONS WHERE SPECIFICALLY INSTRUCTED TO DO SO.
- 3.) ALL MEASUREMENTS ARE IN MILLIMETERS UNLESS OTHERWISE SPECIFIED.
- 4.) DIMENSIONS SHOWN ON THESE DRAWINGS ARE STRUCTURAL DIMENSIONS UNLESS CLEARLY NOTED OTHERWISE.
- 5.) THIS DRAWING IS TO BE READ IN CONJUNCTION WITH ALL OTHER DRAWINGS, DETAIL AND SPECIFICATIONS. ANY DISCREPANCY TO BE IMMEDIATELY BROUGHT TO THE ATTENTION OF ARCHITECT PRIOR TO COMMENCING THE WORKS.



GATE LEVEL PROPOSED = (±0.00 m.) = +15.45 m. DMD LVL.

REV	DATE	DESCRIPTION	CHECK

STATUS: **PRELIMINARY SUBMISSION**

OWNER: **ARGENTI PROPERTIES INVESTMENTS LTD**




PROJECT: **BINGHATTI CIRCLE**
2B + G + 4P + S8 TYP. FLOORS +3 MECH.+3 STR.+ ROOF

PLOT NO: JVC13RHRG001	LOCATION: AL BARSHA SOUTH FOURTH(681)
ARCH: AMAR M	STR Enng: M FLAHA
Reg. No: 114763	Reg. No: 109115
SCALE: 1:200	DRAWN: MUS CHECKED & APPROVED: AM

DRAWING TITLE: **PODIUM-2ND & 3RD FLOORS PLAN**

PROJECT NO: P025-01	DWG NO: A105	REV: 00
----------------------------	---------------------	----------------

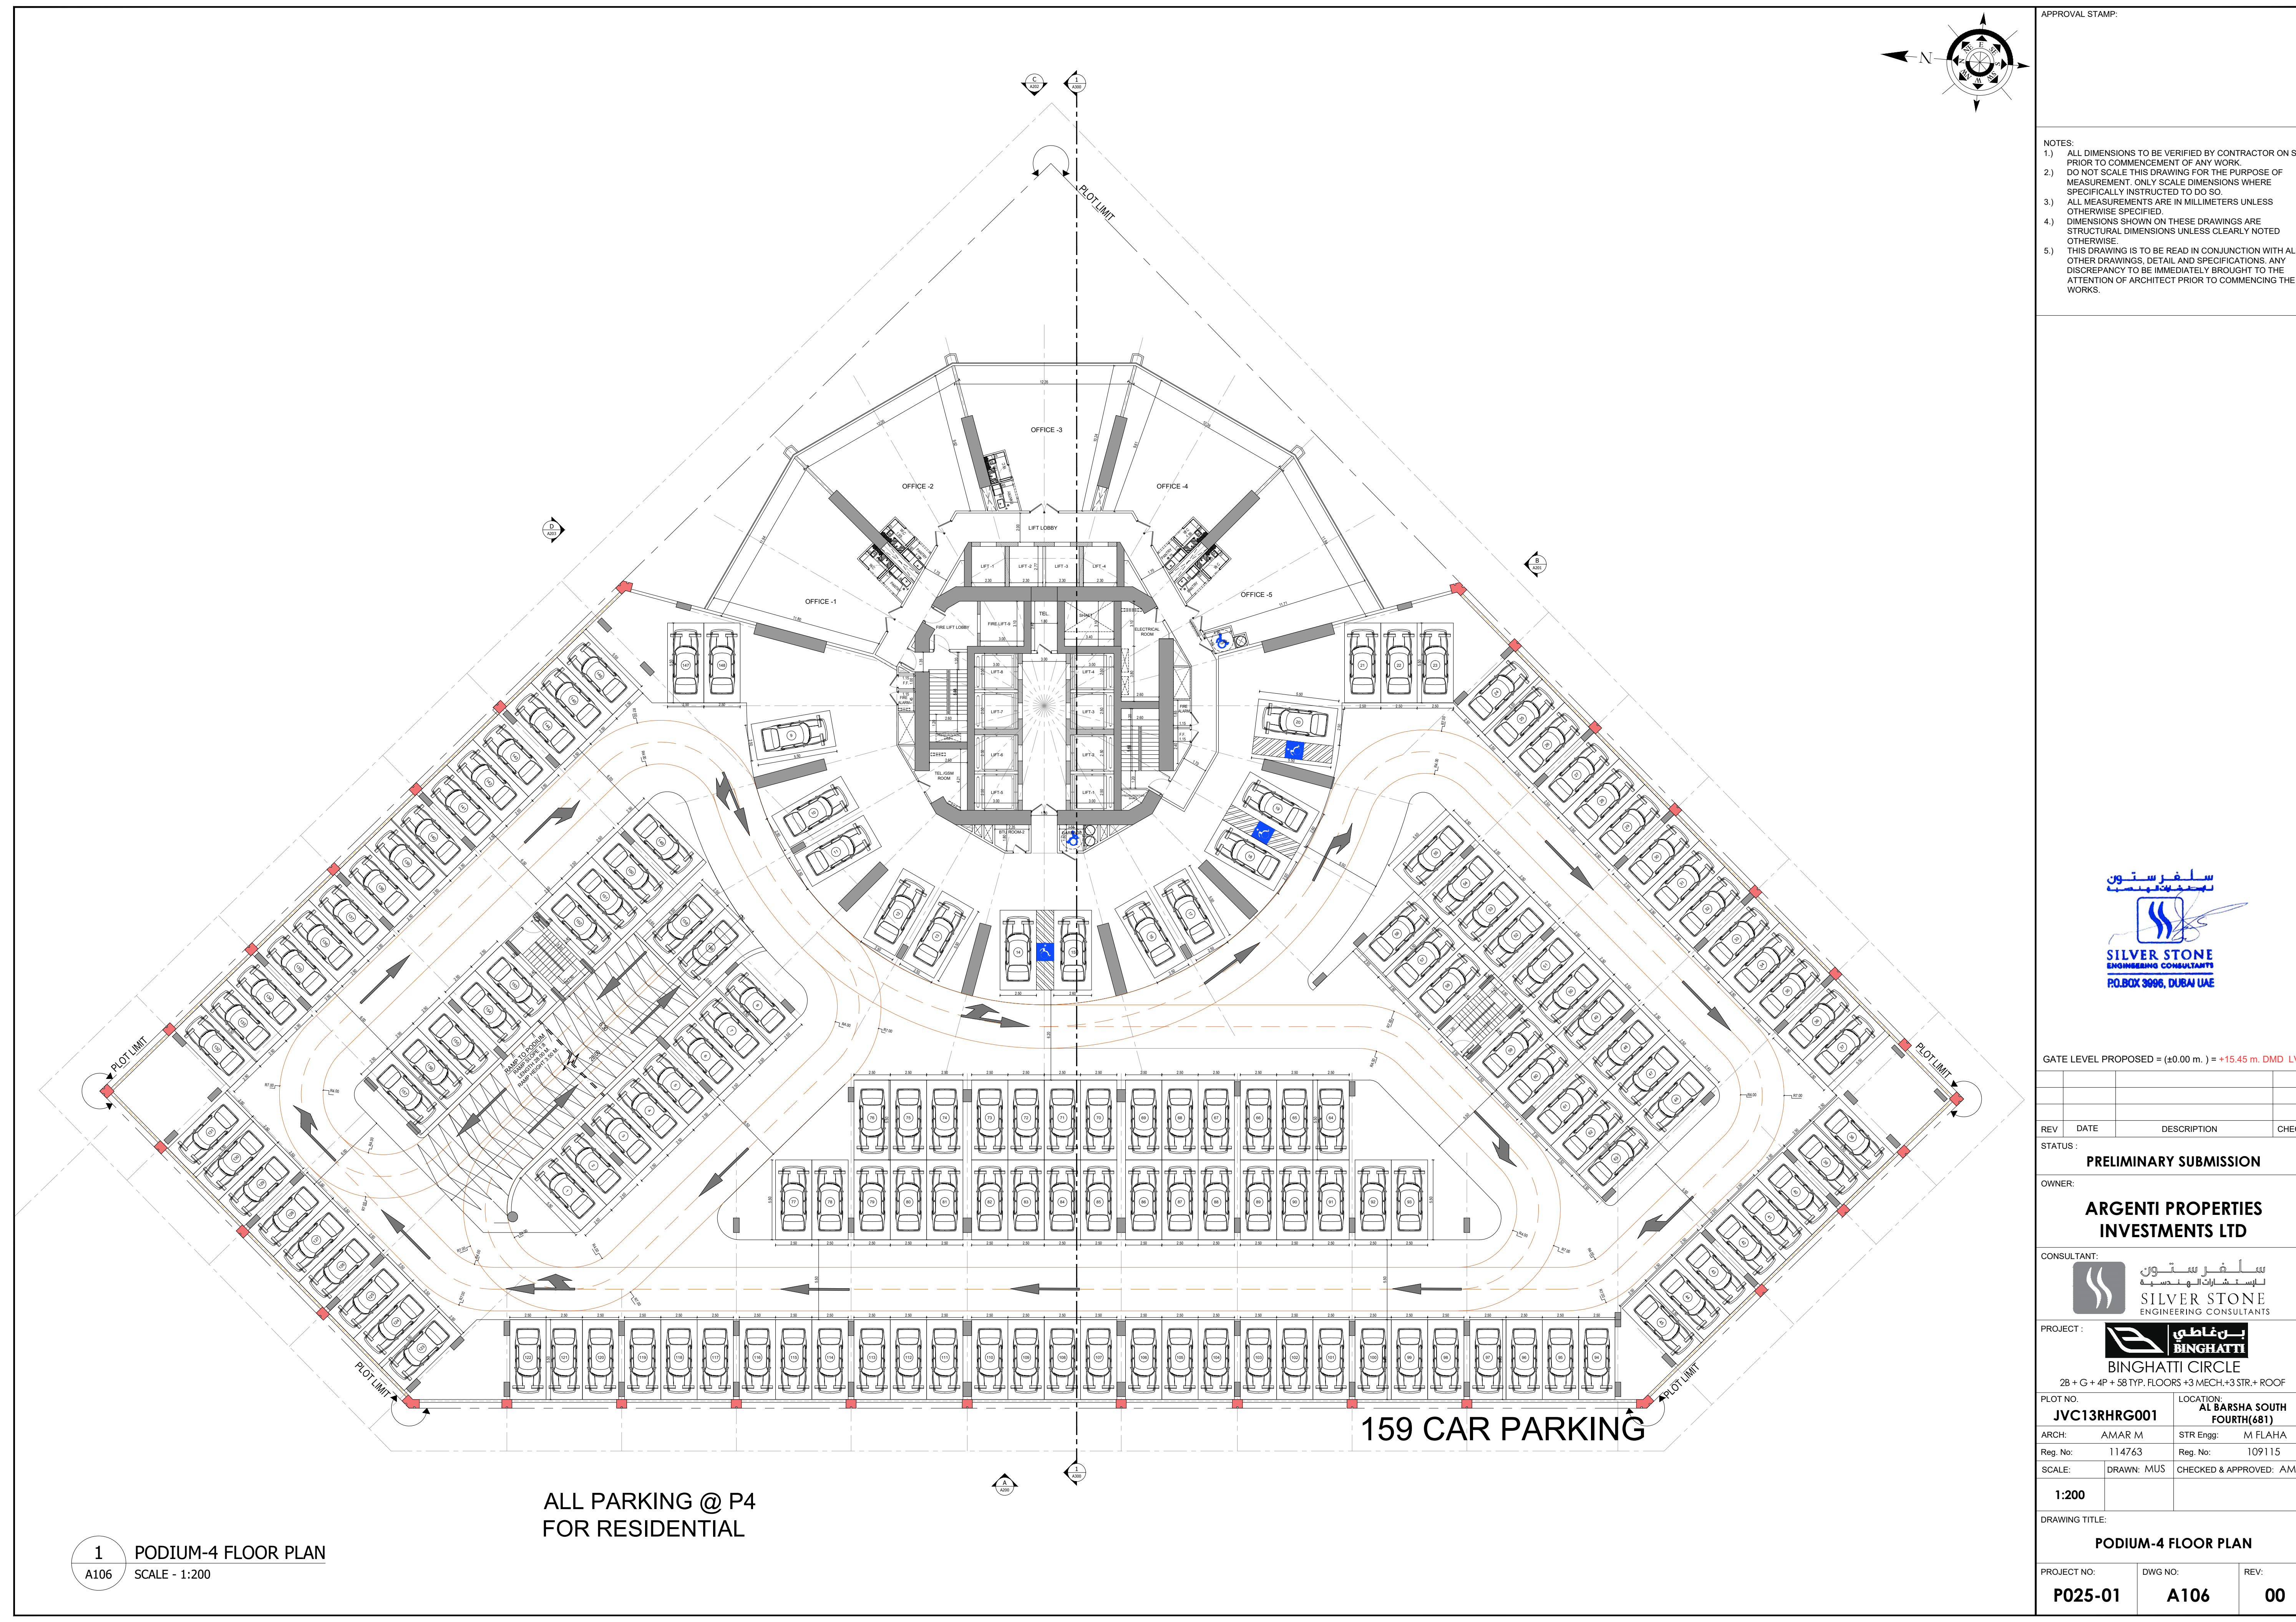

APPROVAL STAMP:

NOTES:

- 1.) ALL DIMENSIONS TO BE VERIFIED BY CONTRACTOR ON SITE PRIOR TO COMMENCEMENT OF ANY WORK.
- 2.) DO NOT SCALE THIS DRAWING FOR THE PURPOSE OF MEASUREMENT. ONLY SCALE DIMENSIONS WHERE SPECIFICALLY INSTRUCTED TO DO SO.
- 3.) ALL MEASUREMENTS ARE IN MILLIMETERS UNLESS OTHERWISE SPECIFIED.
- 4.) DIMENSIONS SHOWN ON THESE DRAWINGS ARE STRUCTURAL DIMENSIONS UNLESS CLEARLY NOTED OTHERWISE.
- 5.) THIS DRAWING IS TO BE READ IN CONJUNCTION WITH ALL OTHER DRAWINGS, DETAIL AND SPECIFICATIONS. ANY DISCREPANCY TO BE IMMEDIATELY BROUGHT TO THE ATTENTION OF ARCHITECT PRIOR TO COMMENCING THE WORKS.



GATE LEVEL PROPOSED = (±0.00 m.) = +15.45 m. DMD LVL.

REV	DATE	DESCRIPTION	CHECK
STATUS:			

PRELIMINARY SUBMISSION

OWNER:

ARGENTI PROPERTIES INVESTMENTS LTD



PROJECT : BINGHATTI CIRCLE
2B + G + 4P + S8 TYP. FLOORS +3 MECH.+3 STR.+ ROOF

PLOT NO: JVC13RHRG001	LOCATION: AL BARSHA SOUTH FOURTH(681)
ARCH: AMAR M	STR Enng: M FLAHA
Reg. No: 114763	Reg. No: 109115
SCALE: 1:200	DRAWN: MUS CHECKED & APPROVED: AM

DRAWING TITLE:

PODIUM-4 FLOOR PLAN


PROJECT NO: P025-01	DWG NO: A106	REV: 00
------------------------	-----------------	------------

1 PODIUM-4 FLOOR PLAN
A106 SCALE - 1:200

ALL PARKING @ P4
FOR RESIDENTIAL

159 CAR PARKING

File Path: X:\Binghatti Project\PO25-01-Binghatti Circle\01- ARCHITECTURE\01- CONCEPT\01- DWG- PLOT Date: 12-Jun-25, Time: 10:23:34 AM

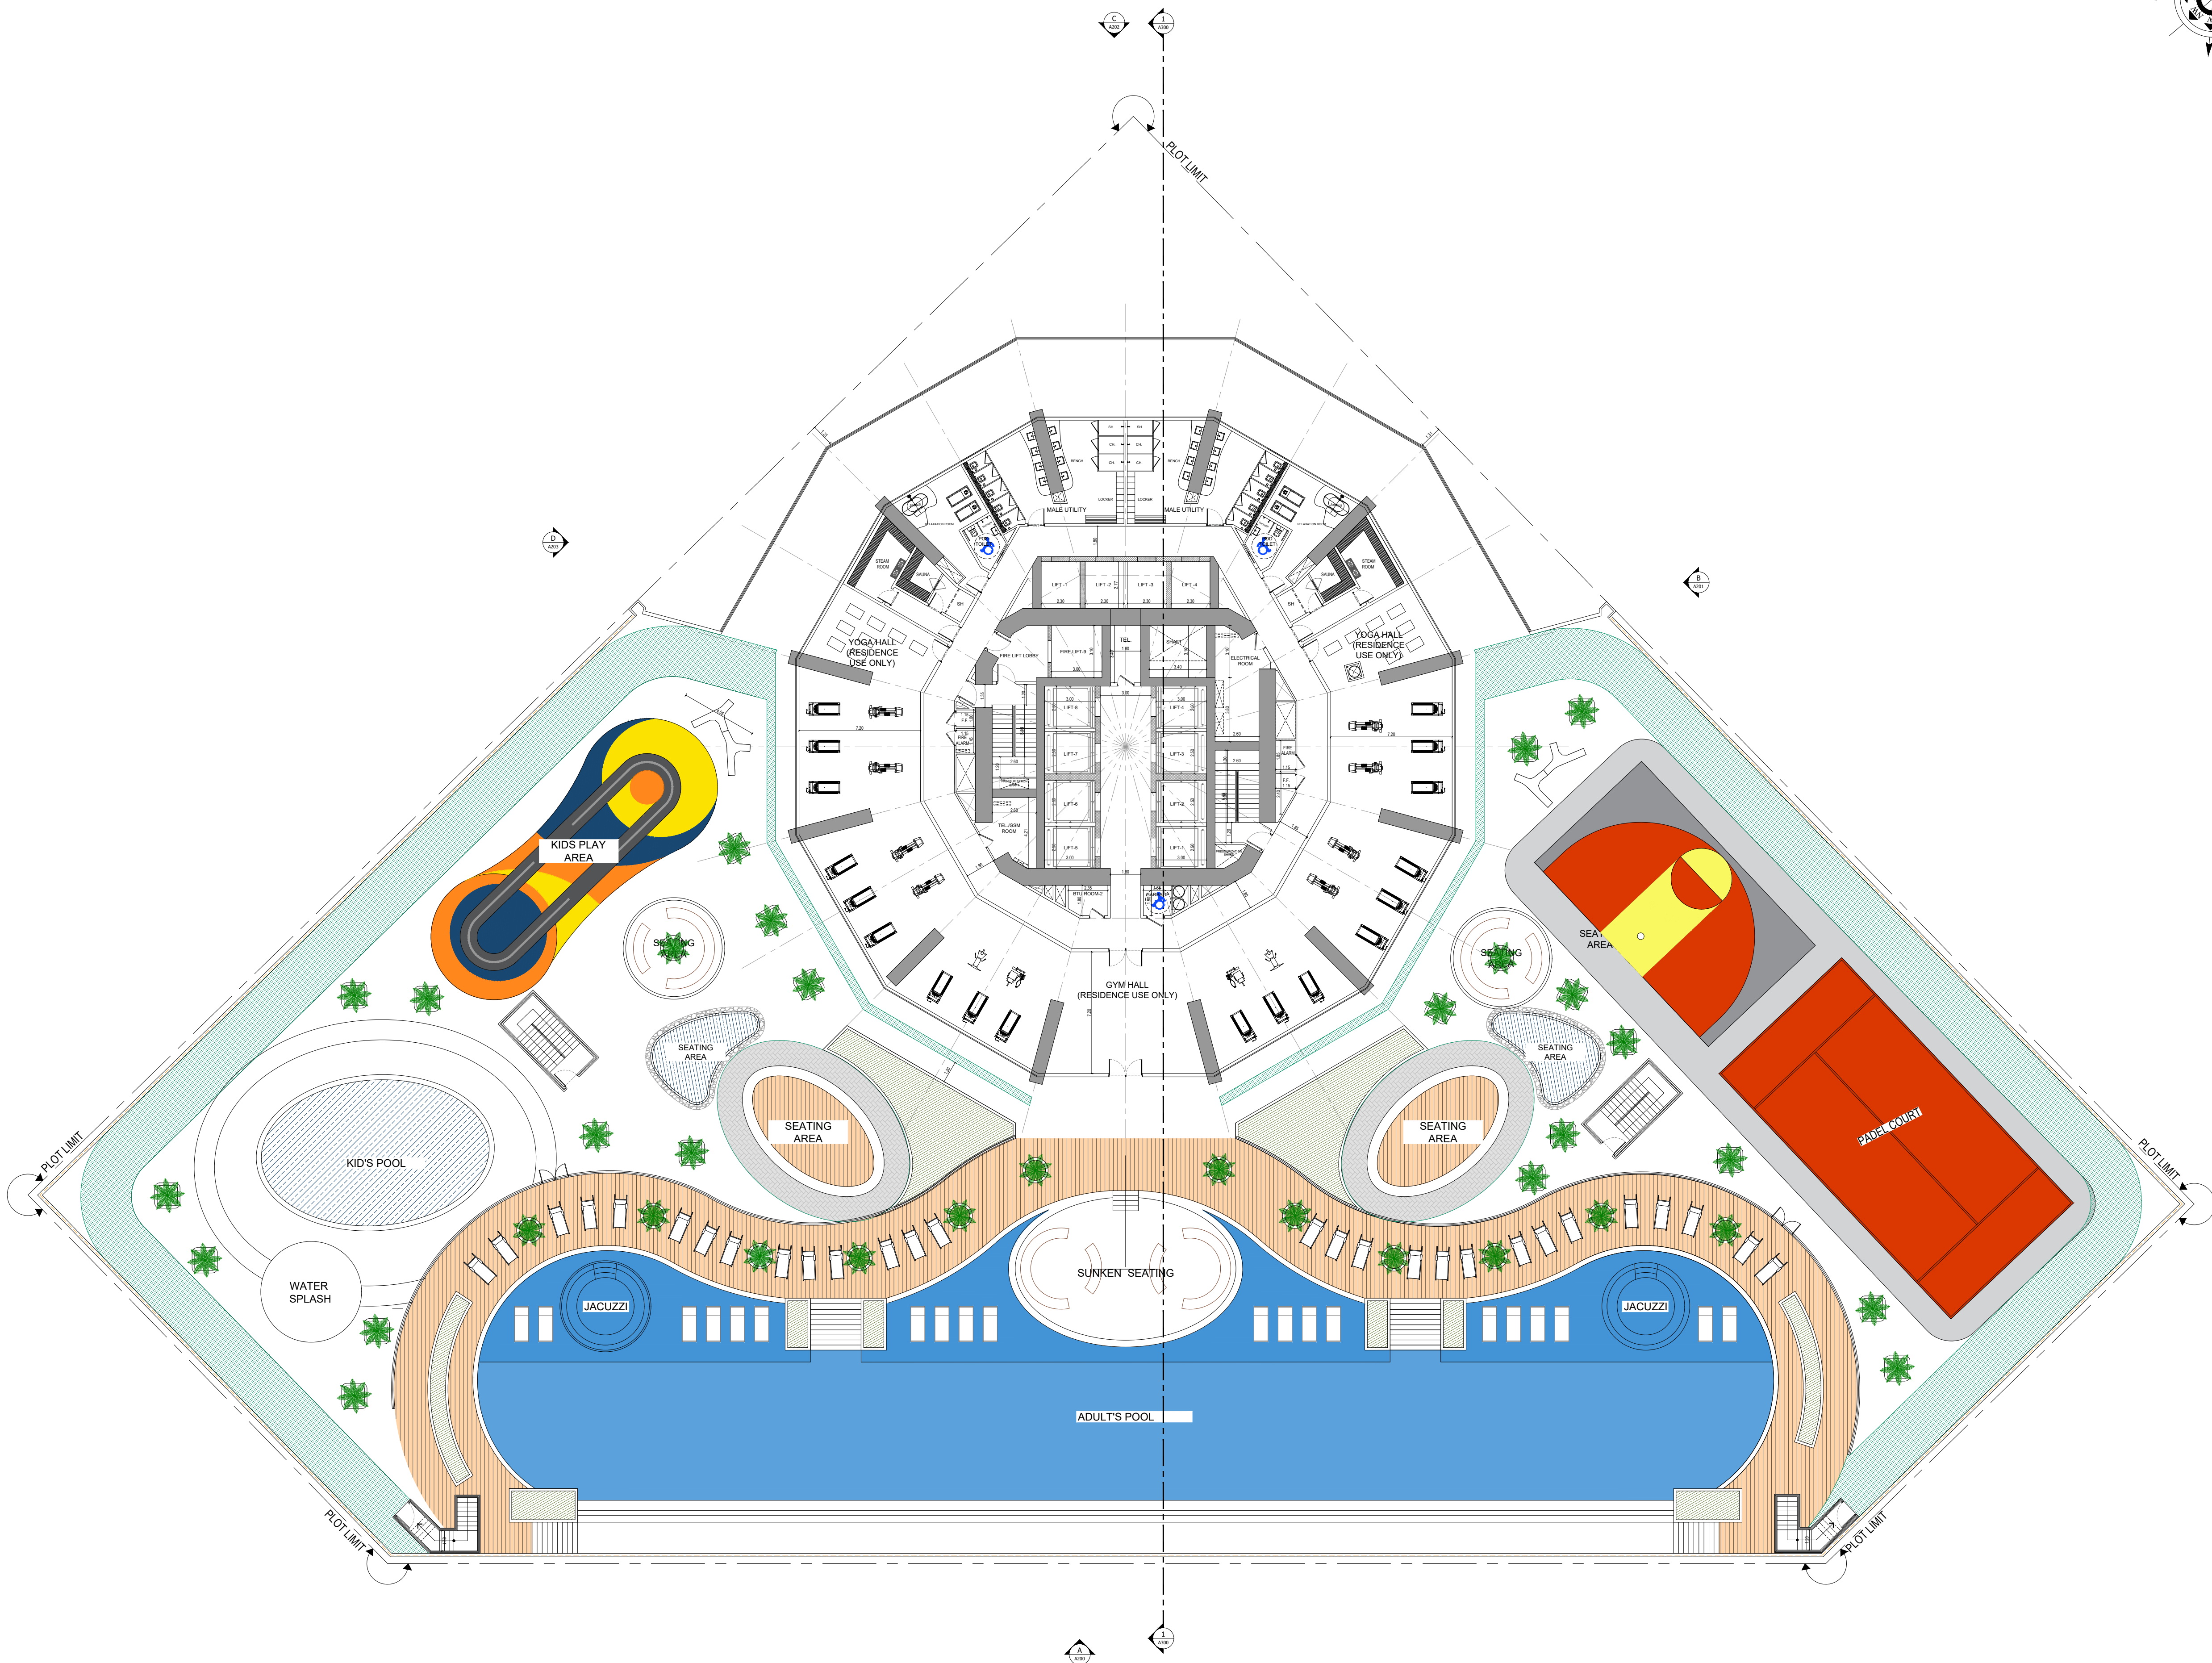

1 FIRST FLOOR PLAN
A107 SCALE - 1:200

APPROVAL STAMP:

- NOTES:
- 1.) ALL DIMENSIONS TO BE VERIFIED BY CONTRACTOR ON SITE PRIOR TO COMMENCEMENT OF ANY WORK.
 - 2.) DO NOT SCALE THIS DRAWING FOR THE PURPOSE OF MEASUREMENT. ONLY SCALE DIMENSIONS WHERE SPECIFICALLY INSTRUCTED TO DO SO.
 - 3.) ALL MEASUREMENTS ARE IN MILLIMETERS UNLESS OTHERWISE SPECIFIED.
 - 4.) DIMENSIONS SHOWN ON THESE DRAWINGS ARE STRUCTURAL DIMENSIONS UNLESS CLEARLY NOTED OTHERWISE.
 - 5.) THIS DRAWING IS TO BE READ IN CONJUNCTION WITH ALL OTHER DRAWINGS, DETAIL AND SPECIFICATIONS. ANY DISCREPANCY TO BE IMMEDIATELY BROUGHT TO THE ATTENTION OF ARCHITECT PRIOR TO COMMENCING THE WORKS.



GATE LEVEL PROPOSED = (±0.00 m.) = +15.45 m. DMD LVL.

REV	DATE	DESCRIPTION	CHECK
-----	------	-------------	-------

STATUS:

PRELIMINARY SUBMISSION

OWNER:

ARGENTI PROPERTIES
INVESTMENTS LTD

CONSULTANT:



PROJECT :



BINGHATTI CIRCLE

2B + G + 4P + S8 TYP. FLOORS +3 MECH.+3 STR.+ ROOF

PLOT NO:

JVC13RHRG001

LOCATION:

AL BARSHA SOUTH

FOURTH(681)

ARCH: AMAR M

STR Engg: M FLAHA

Reg. No: 114763

Reg. No: 109115

SCALE: DRAWN: MUS

CHECKED & APPROVED: AM

1:200

DRAWING TITLE:

FIRST FLOOR PLAN

PROJECT NO:



P025-01

DWG NO:

A107

REV:


00

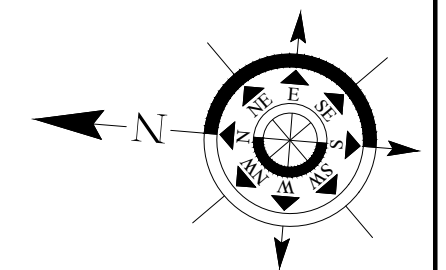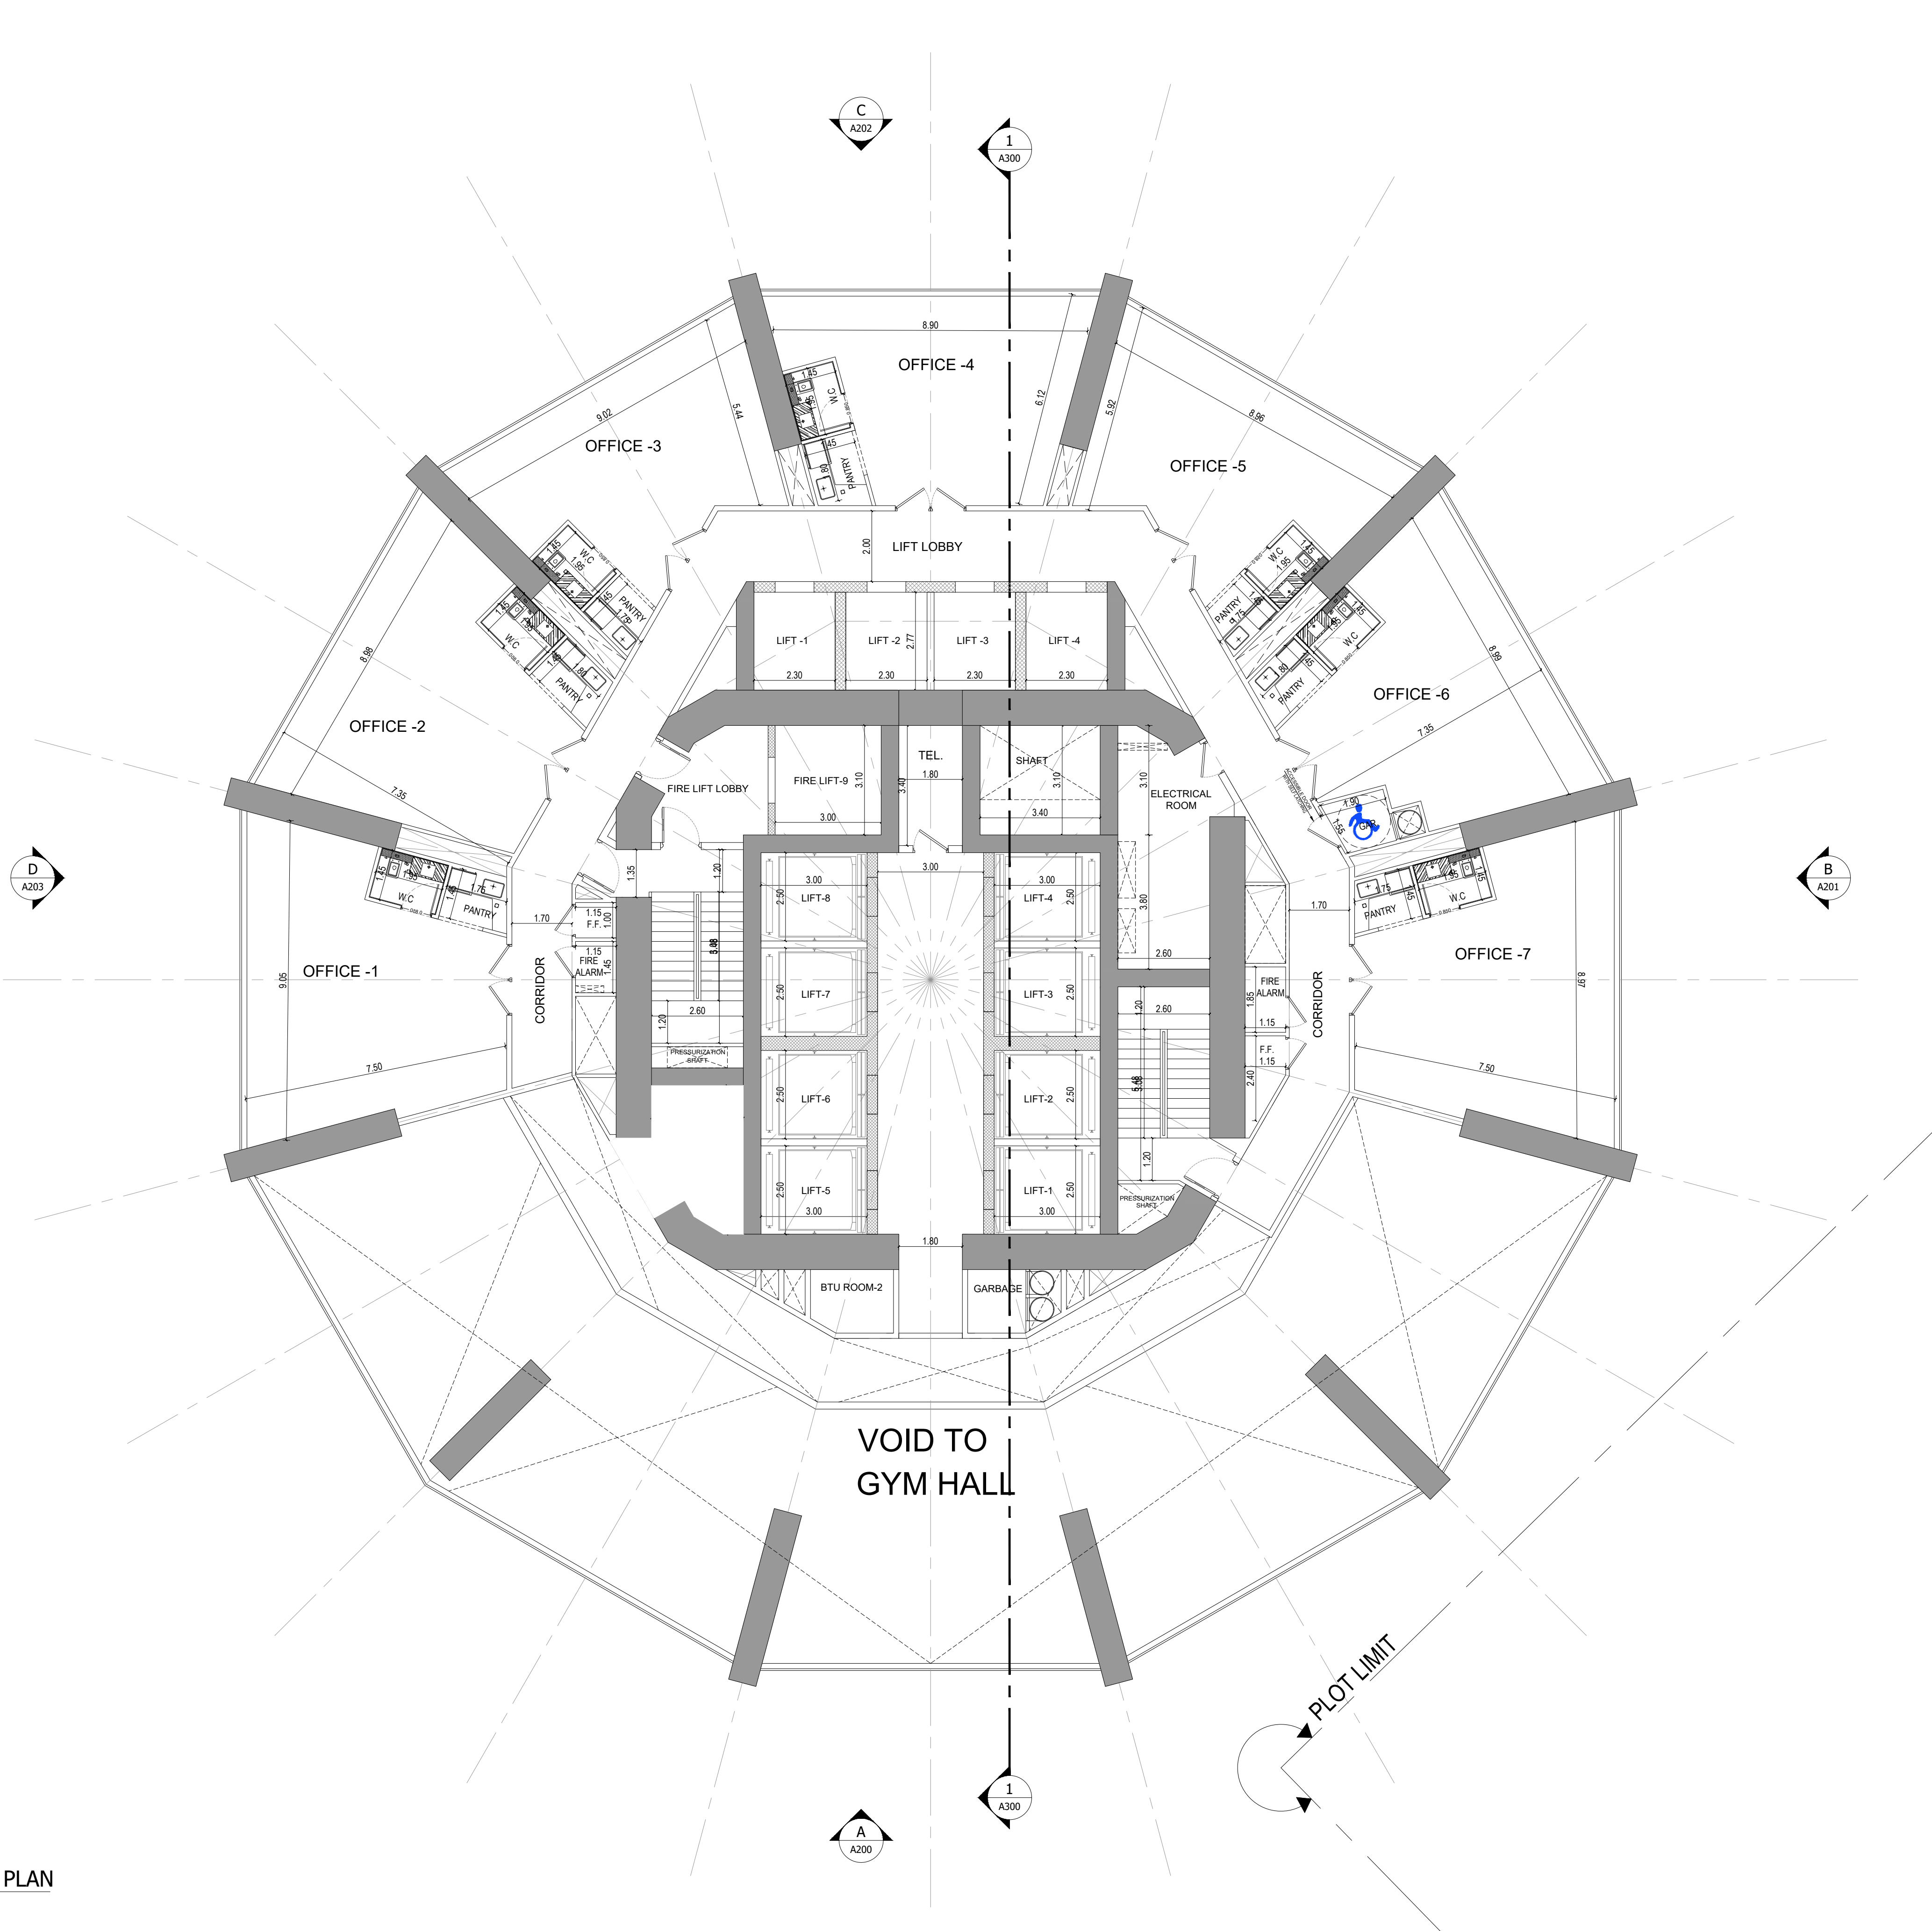

APPROVAL STAMP:

- NOTES:
- 1.) ALL DIMENSIONS TO BE VERIFIED BY CONTRACTOR ON SITE PRIOR TO COMMENCEMENT OF ANY WORK.
 - 2.) DO NOT SCALE THIS DRAWING FOR THE PURPOSE OF MEASUREMENT. ONLY SCALE DIMENSIONS WHERE SPECIFICALLY INSTRUCTED TO DO SO.
 - 3.) ALL MEASUREMENTS ARE IN MILLIMETERS UNLESS OTHERWISE SPECIFIED.
 - 4.) DIMENSIONS SHOWN ON THESE DRAWINGS ARE STRUCTURAL DIMENSIONS UNLESS CLEARLY NOTED OTHERWISE.
 - 5.) THIS DRAWING IS TO BE READ IN CONJUNCTION WITH ALL OTHER DRAWINGS, DETAIL AND SPECIFICATIONS. ANY DISCREPANCY TO BE IMMEDIATELY BROUGHT TO THE ATTENTION OF ARCHITECT PRIOR TO COMMENCING THE WORKS.

KEY PLAN:-

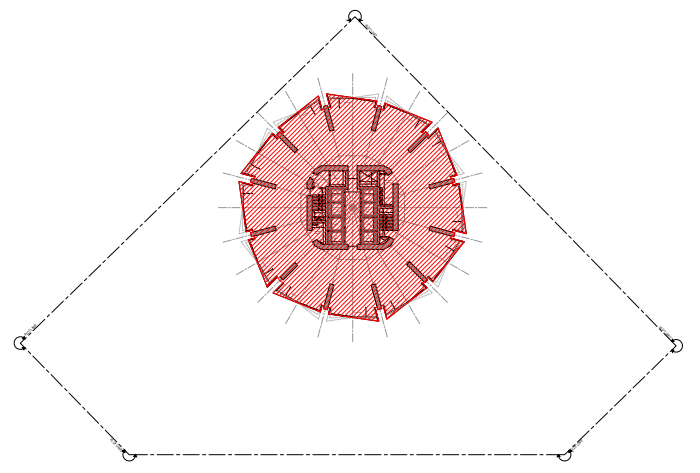

GATE LEVEL PROPOSED = (±0.00 m.) = +15.45 m. DMD LVL.

REV	DATE	DESCRIPTION	CHECK

STATUS : PRELIMINARY SUBMISSION

OWNER:
ARGENTI PROPERTIES INVESTMENTS LTD

CONSULTANT:
SILVER STONE ENGINEERING CONSULTANTS

PROJECT :
BINGHATTI CIRCLE

PLOT NO: **JVC13RHRG001**
LOCATION: **AL BARSHA SOUTH FOURTH(681)**

ARCH: **AMAR M** STR Engg: **M FLAHA**
Reg. No: **114763** Reg. No: **109115**



SCALE: **1:100**
DRAWN: **MUS** CHECKED & APPROVED: **AM**

DRAWING TITLE: **2ND FLOOR PLAN**

PROJECT NO: **P025-01** DWG NO: **A108** REV: **00**

1 2ND FLOOR PLAN
A108 SCALE - 1:100


File Path: X:\Binghatti Project\Process\025-01-Binghatti Circle\01- ARCHITECTURE\01- CONCEPT\01- DWG- Print Date: 12-Jun-25, Time: 10:23:34 AM

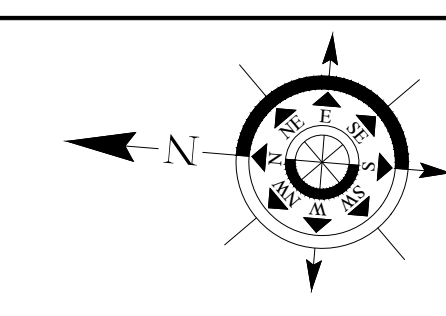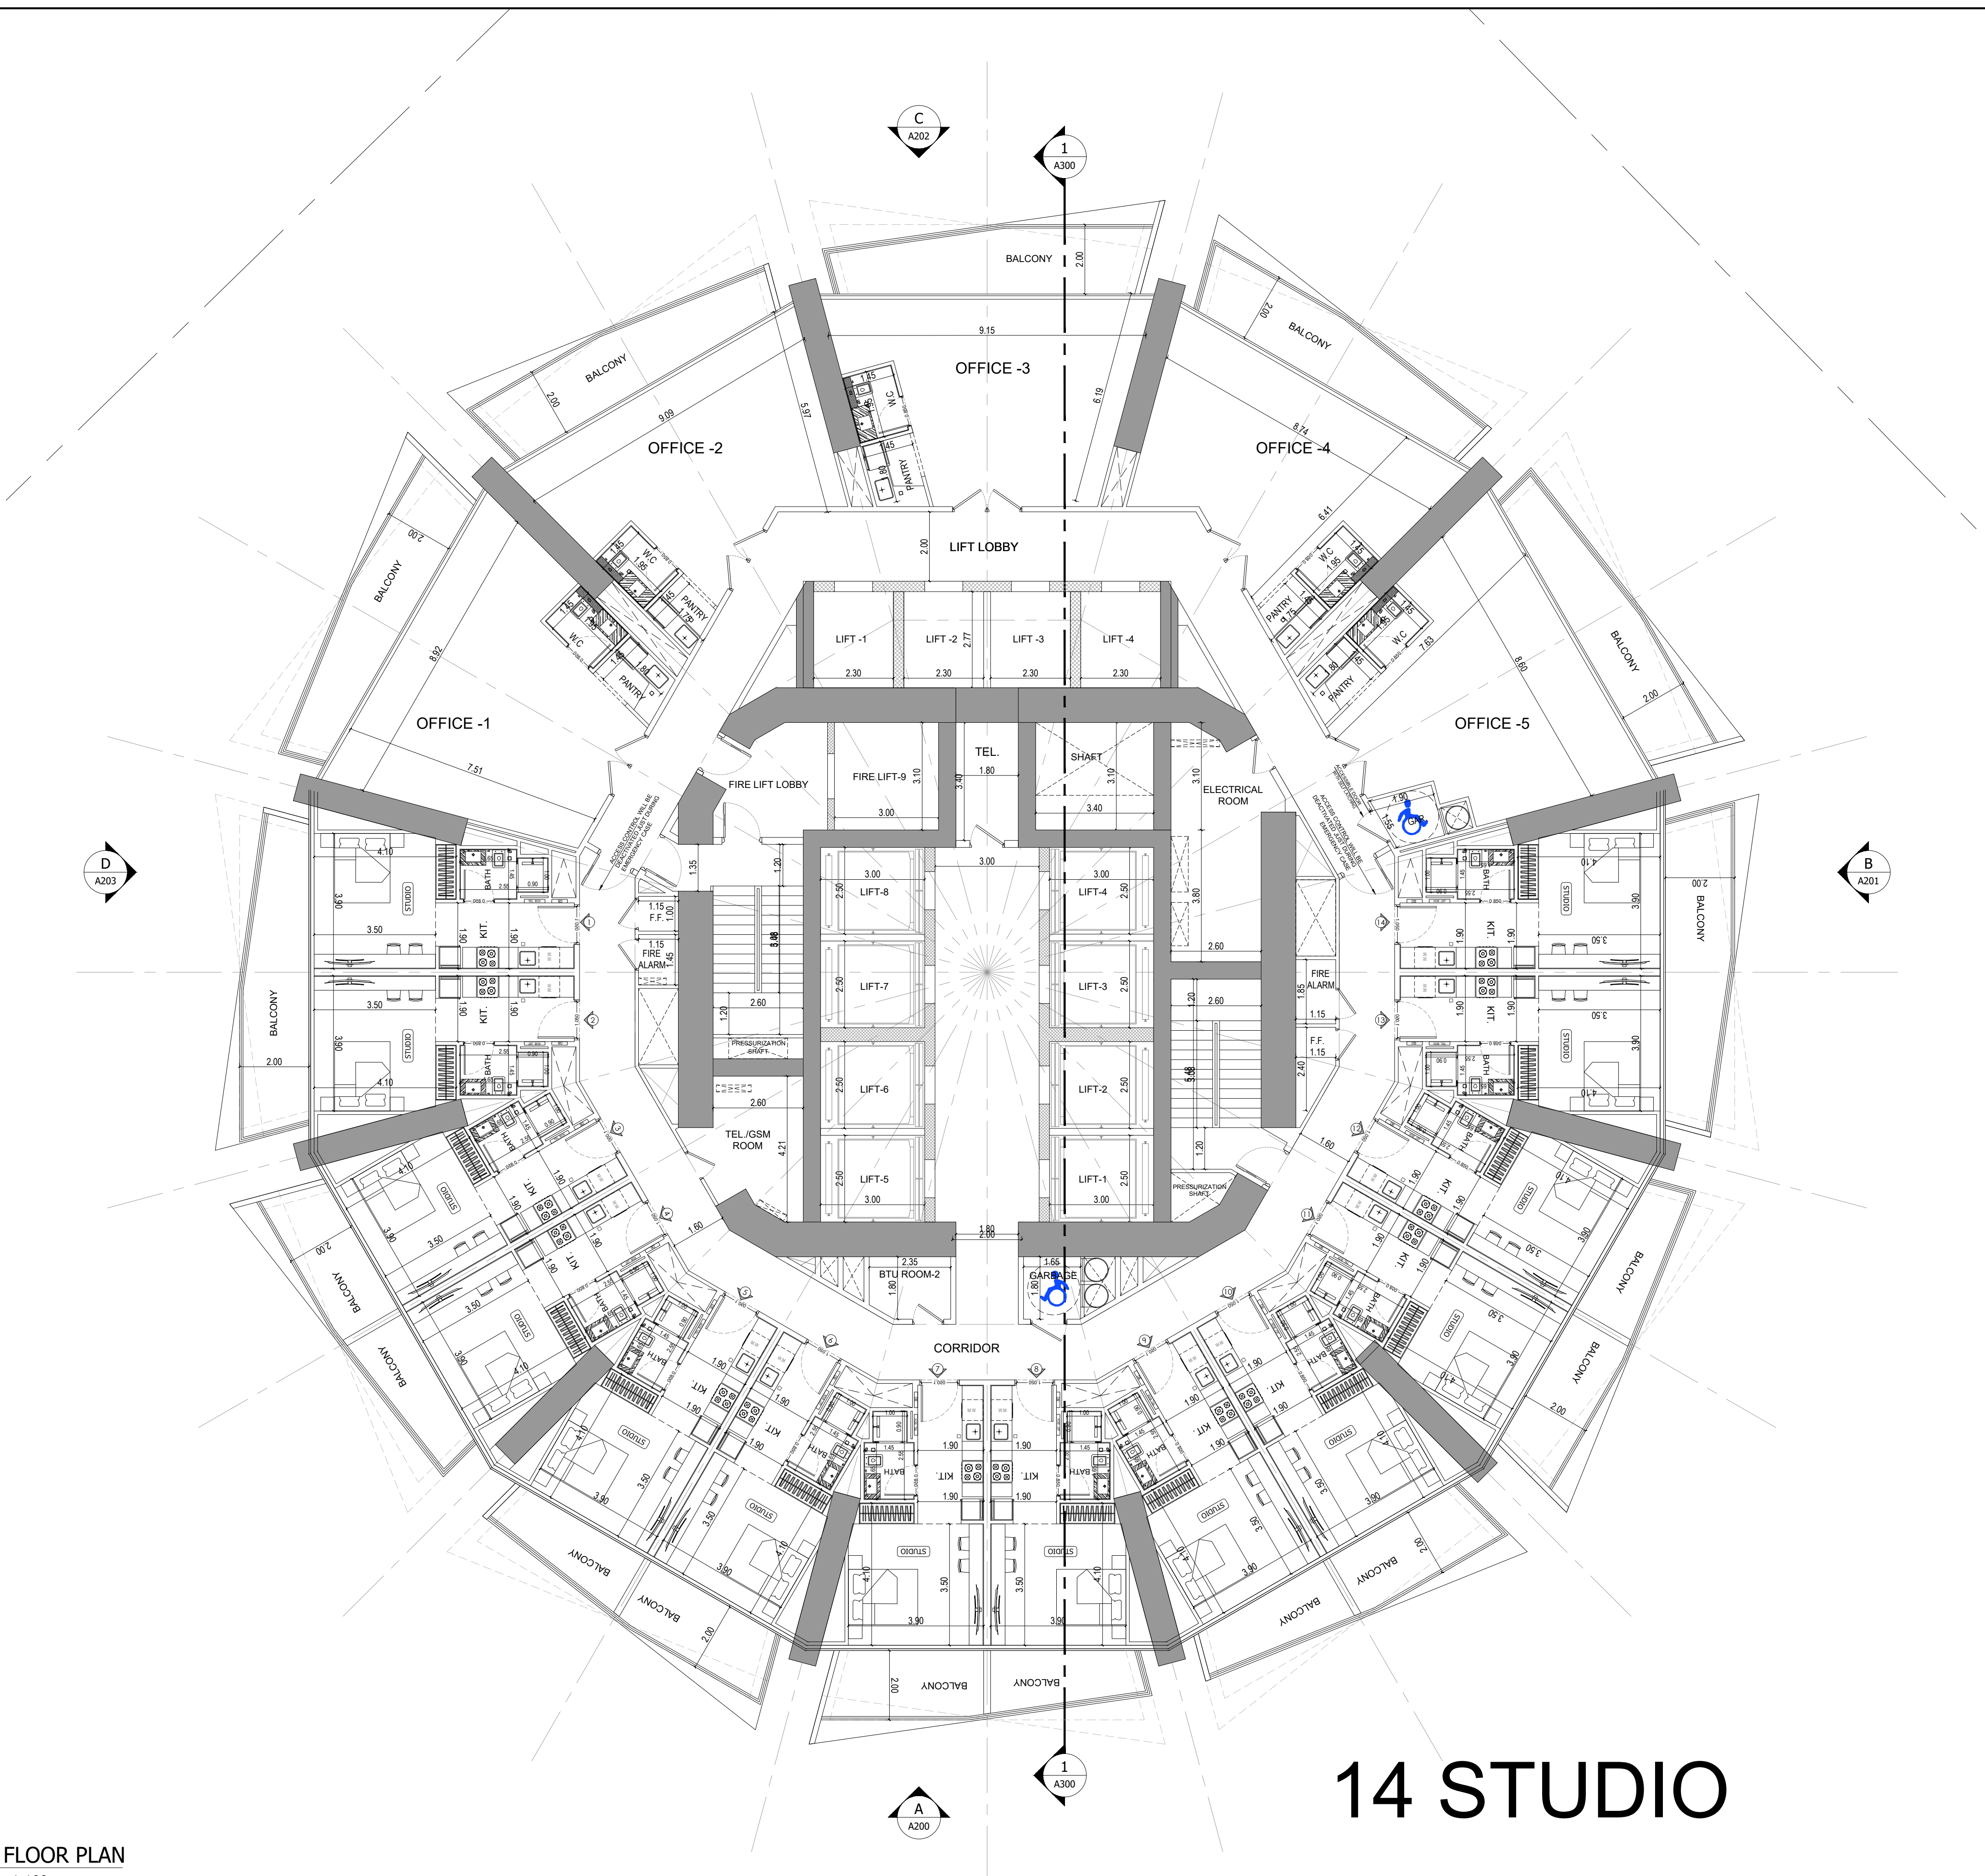

APPROVAL STAMP:

NOTES:

- 1.) ALL DIMENSIONS TO BE VERIFIED BY CONTRACTOR ON SITE PRIOR TO COMMENCEMENT OF ANY WORK.
- 2.) DO NOT SCALE THIS DRAWING FOR THE PURPOSE OF MEASUREMENT. ONLY SCALE DIMENSIONS WHERE SPECIFICALLY INSTRUCTED TO DO SO.
- 3.) ALL MEASUREMENTS ARE IN MILLIMETERS UNLESS OTHERWISE SPECIFIED.
- 4.) DIMENSIONS SHOWN ON THESE DRAWINGS ARE STRUCTURAL DIMENSIONS UNLESS CLEARLY NOTED OTHERWISE.
- 5.) THIS DRAWING IS TO BE READ IN CONJUNCTION WITH ALL OTHER DRAWINGS, DETAIL AND SPECIFICATIONS. ANY DISCREPANCY TO BE IMMEDIATELY BROUGHT TO THE ATTENTION OF ARCHITECT PRIOR TO COMMENCING THE WORKS.

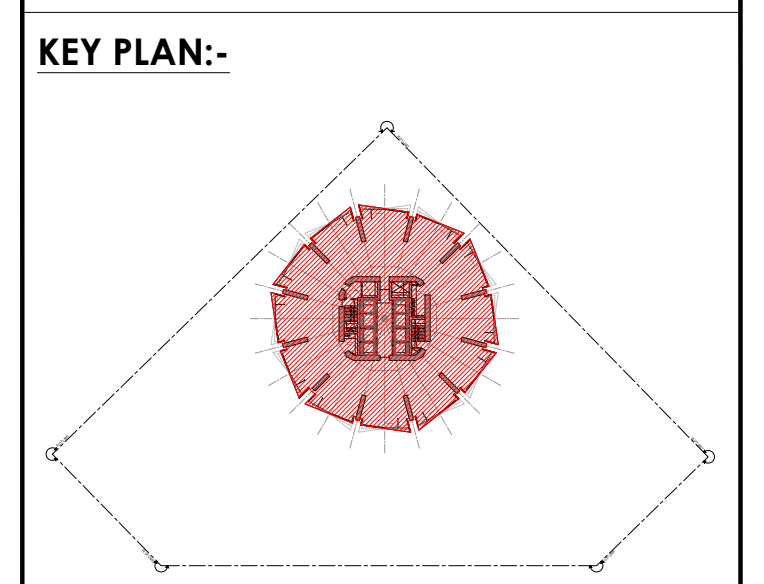


سلفر ستون
للمهندسة
SILVER STONE
ENGINEERING CONSULTANTS
P.O. BOX 3096, DUBAI UAE

GATE LEVEL PROPOSED = (±0.00 m.) = +15.45 m. DMD LVL.

GATE LEVEL PROPOSED = (±0.00 m.) = +15.45 m. DMD LVL.			
REV	DATE	DESCRIPTION	CHECK
STATUS :			
PRELIMINARY SUBMISSION			
OWNER:			
ARGENTI PROPERTIES INVESTMENTS LTD			
CONSULTANT:			
 سلفر ستون للمهندسة SILVER STONE ENGINEERING CONSULTANTS			
PROJECT :			
 BINGHATTI CIRCLE 2B + G + 4P + S8 TYP. FLOORS +3 MECH.+3 STR.+ ROOF			
PLOT NO:		LOCATION:	
JVC13RHRG001		AL BARSHA SOUTH FOURTH(681)	
ARCH: AMAR M		STR Engg: M FLAHA	
Reg. No: 114763		Reg. No: 109115	
SCALE: DRAWN: MUS		CHECKED & APPROVED: AM	
1:100			
DRAWING TITLE:			
3RD FLOOR PLAN			
PROJECT NO:		DWG NO:	REV:
P025-01		A109	00

Path X:\Binghatti Process\025-01-ARGHETTI Circle\1-DWG Print Date: 12-Jun-25 Time: 10:23:34 AM

14 STUDIO

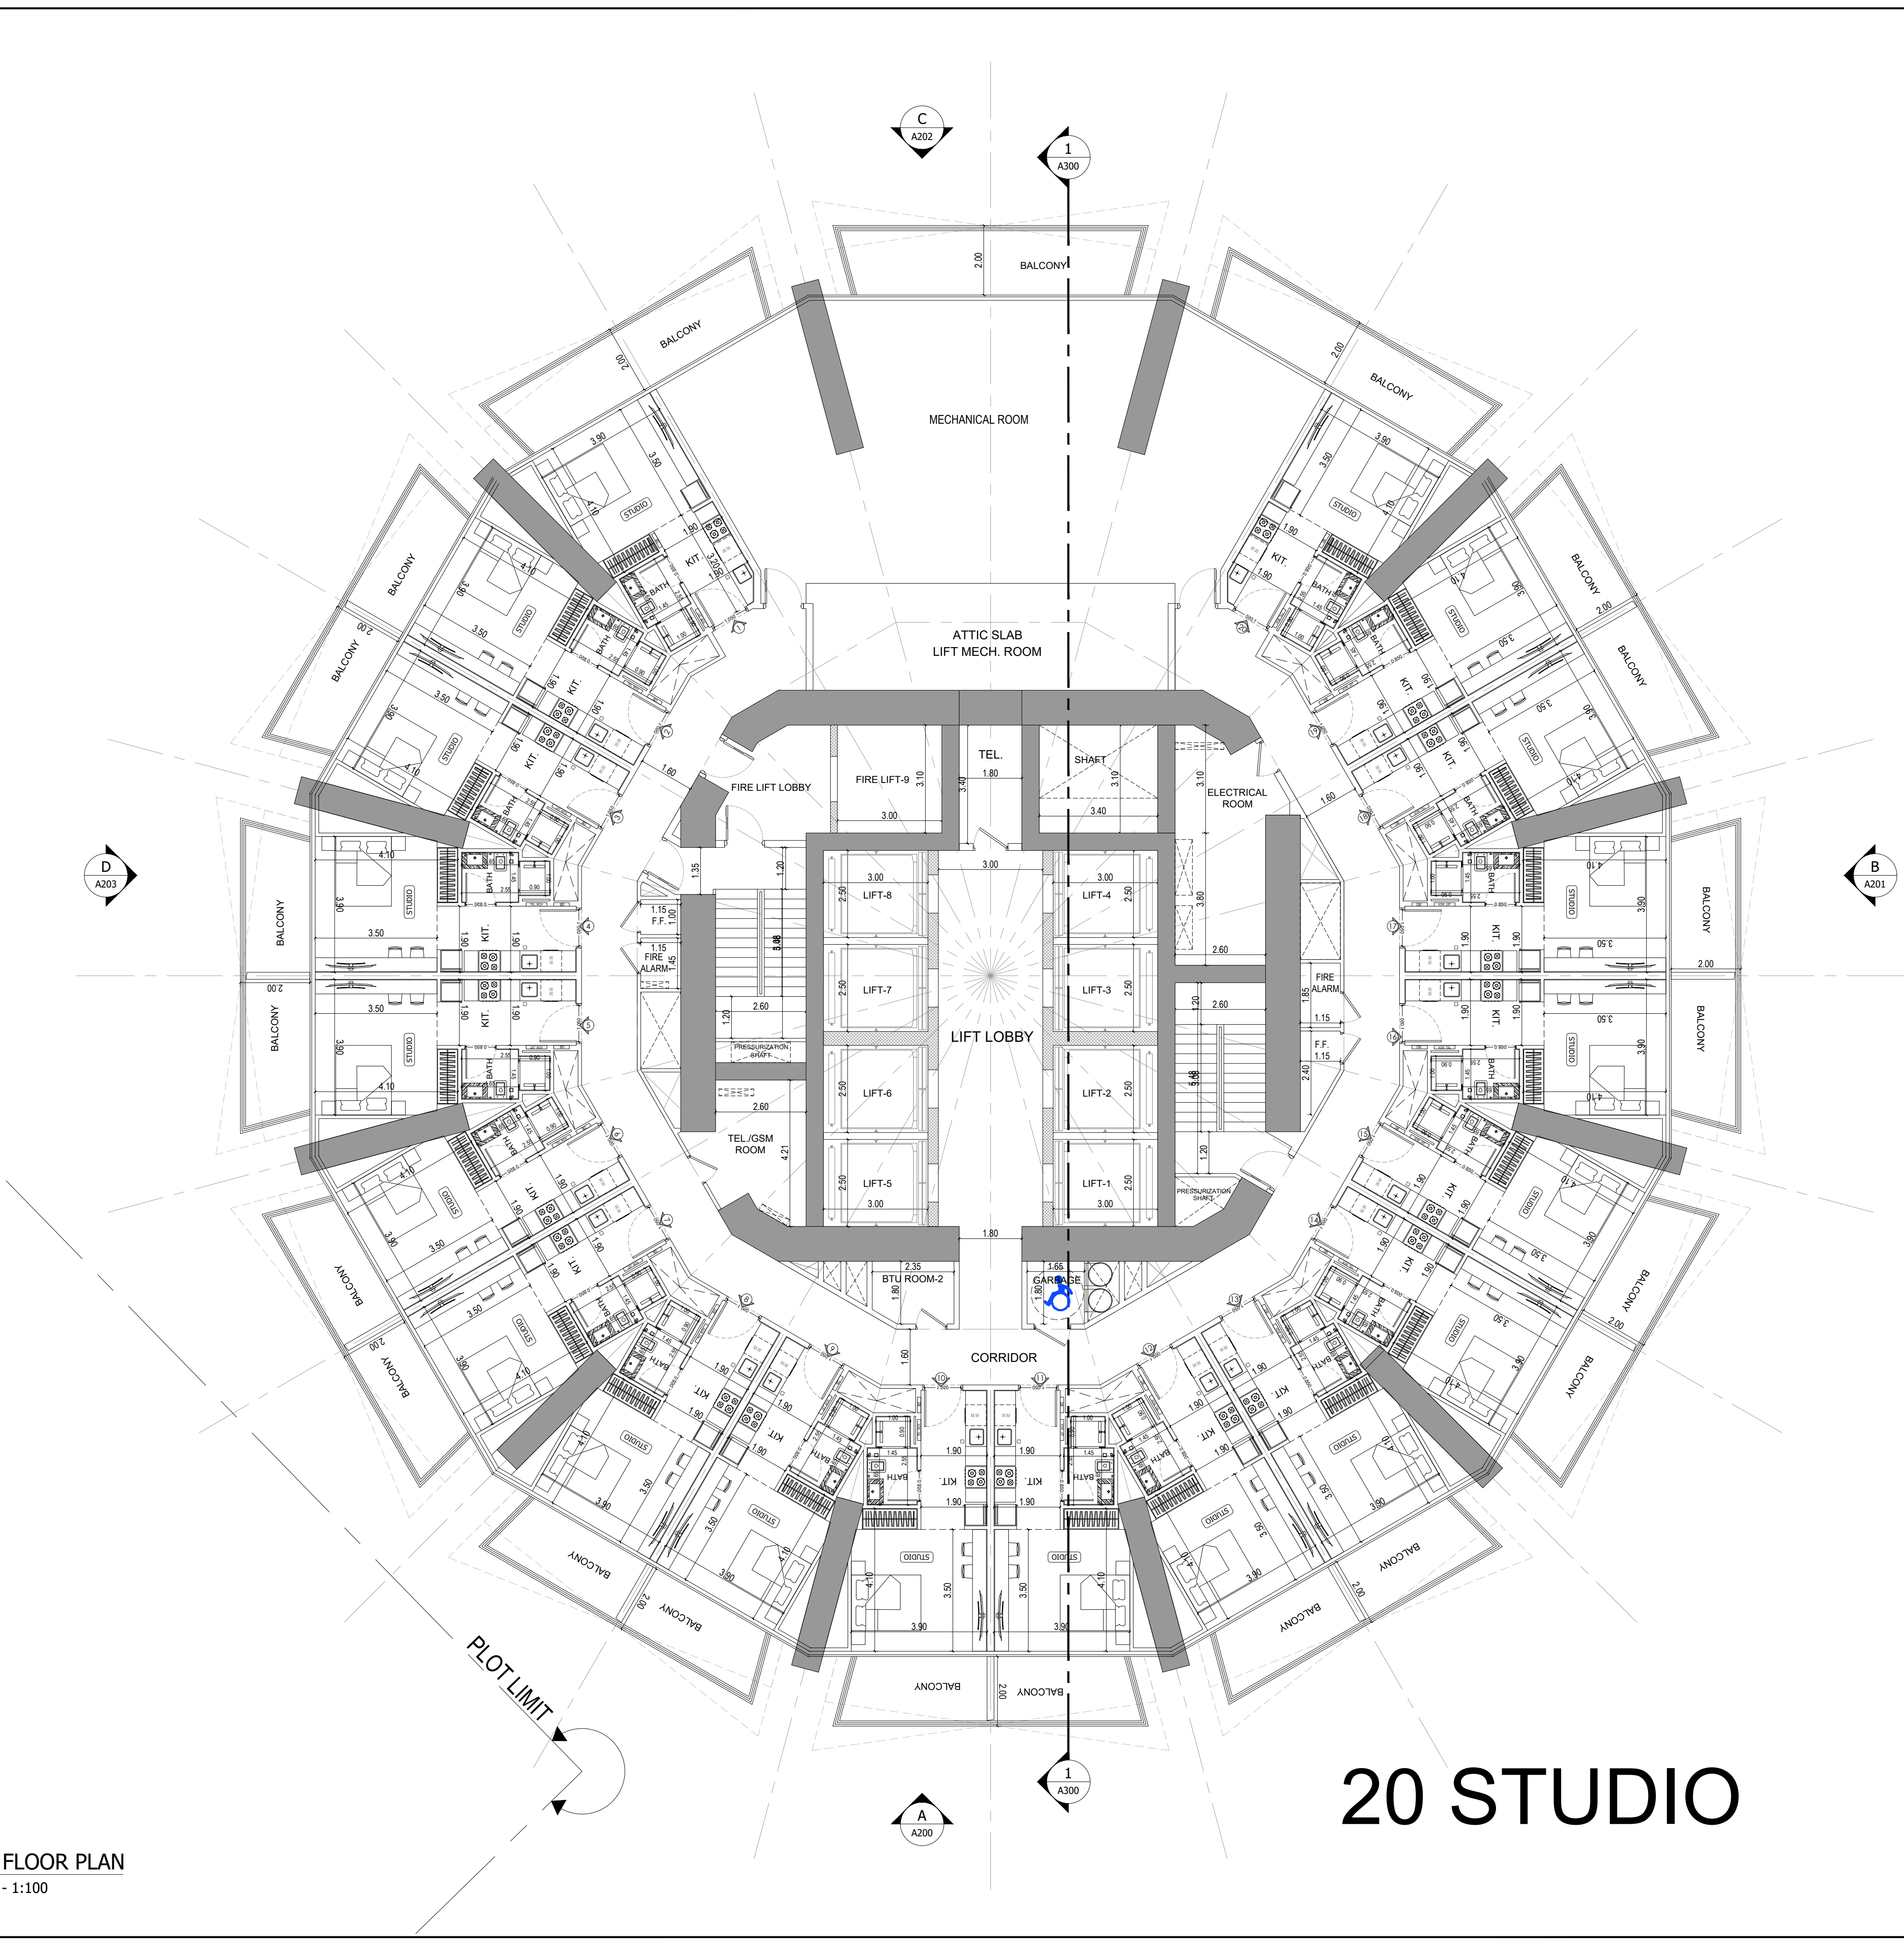

1 4TH FLOOR PLAN
A110 SCALE - 1:100

20 STUDIO

APPROVAL STAMP:

NOTES:
1.) ALL DIMENSIONS TO BE VERIFIED BY CONTRACTOR ON SITE PRIOR TO COMMENCEMENT OF ANY WORK.
2.) DO NOT SCALE THIS DRAWING FOR THE PURPOSE OF MEASUREMENT. ONLY SCALE DIMENSIONS WHERE SPECIFICALLY INSTRUCTED TO DO SO.
3.) ALL MEASUREMENTS ARE IN MILLIMETERS UNLESS OTHERWISE SPECIFIED.
4.) DIMENSIONS SHOWN ON THESE DRAWINGS ARE STRUCTURAL DIMENSIONS UNLESS CLEARLY NOTED OTHERWISE.
5.) THIS DRAWING IS TO BE READ IN CONJUNCTION WITH ALL OTHER DRAWINGS, DETAIL AND SPECIFICATIONS. ANY DISCREPANCY TO BE IMMEDIATELY BROUGHT TO THE ATTENTION OF ARCHITECT PRIOR TO COMMENCING THE WORKS.

KEY PLAN:-

سلفر ستون
للمهندسين
SILVER STONE
ENGINEERING CONSULTANTS
P.O. BOX 3096, DUBAI UAE

GATE LEVEL PROPOSED = (±0.00 m.) = +15.45 m. DMD LVL.

REV	DATE	DESCRIPTION	CHECK

STATUS :
PRELIMINARY SUBMISSION

OWNER:
ARGENTI PROPERTIES INVESTMENTS LTD

CONSULTANT:

سلفر ستون
للمهندسين
SILVER STONE
ENGINEERING CONSULTANTS

PROJECT :

بني غاطي
BINGHATTI
BINGHATTI CIRCLE
2B + G + 4P + S8 TYP. FLOORS +3 MECH.+3 STR.+ ROOF


LOCATION:	AL BARSHA SOUTH FOURTH(681)
ARCH:	AMAR M
STR Engg:	M FLAHA
Reg. No:	114763
Reg. No:	109115
SCALE:	DRAWN: MUS
CHECKED & APPROVED:	AM

1:100	

DRAWING TITLE:
4TH FLOOR PLAN

PROJECT NO:	DWG NO:	REV:
P025-01	A110	00

File Path: X:\Binghatti Project\2025-01-Binghatti Circle\01- ARCHITECTURE\01- CONCEPT\01- DWG- Prit Date: 12-Jun-25, Time: 10:23:34 AM

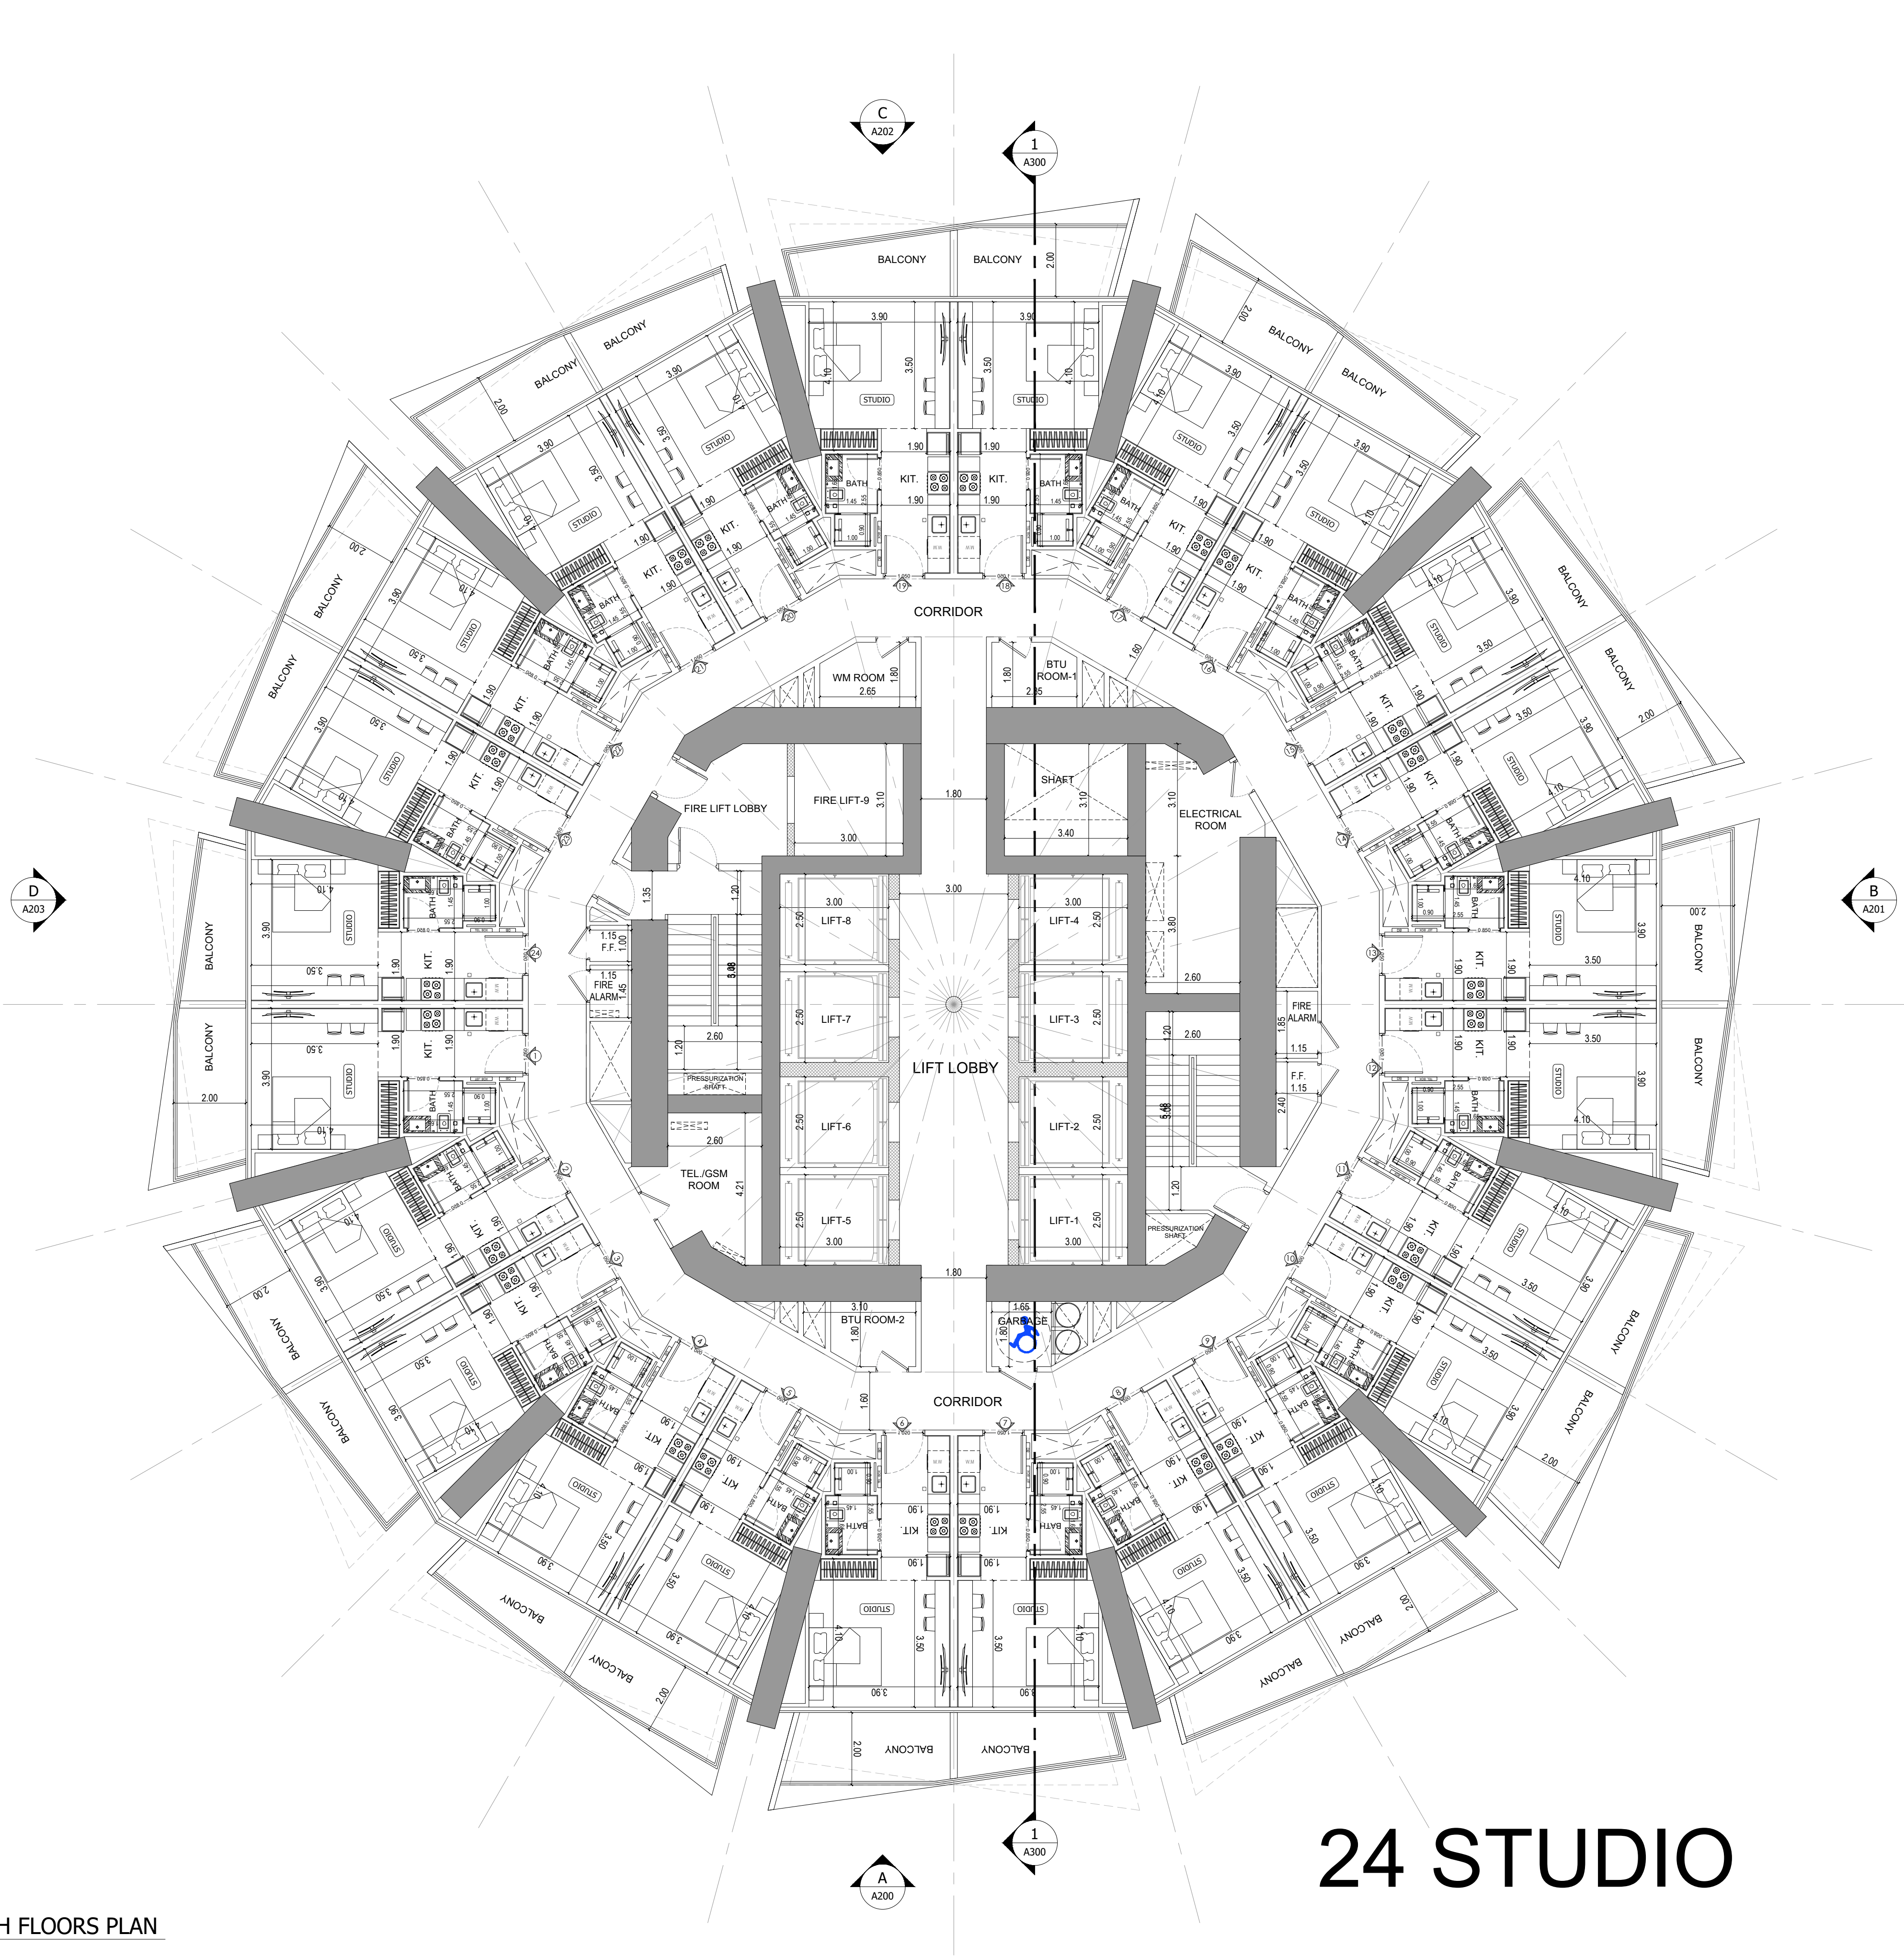


24 STUDIO

1 7,11 & 15TH FLOORS PLAN
A111 SCALE - 1:100

APPROVAL STAMP:

NOTES:

- 1.) ALL DIMENSIONS TO BE VERIFIED BY CONTRACTOR ON SITE PRIOR TO COMMENCEMENT OF ANY WORK.
- 2.) DO NOT SCALE THIS DRAWING FOR THE PURPOSE OF MEASUREMENT. ONLY SCALE DIMENSIONS WHERE SPECIFICALLY INSTRUCTED TO DO SO.
- 3.) ALL MEASUREMENTS ARE IN MILLIMETERS UNLESS OTHERWISE SPECIFIED.
- 4.) DIMENSIONS SHOWN ON THESE DRAWINGS ARE STRUCTURAL DIMENSIONS UNLESS CLEARLY NOTED OTHERWISE.
- 5.) THIS DRAWING IS TO BE READ IN CONJUNCTION WITH ALL OTHER DRAWINGS, DETAIL AND SPECIFICATIONS. ANY DISCREPANCY TO BE IMMEDIATELY BROUGHT TO THE ATTENTION OF ARCHITECT PRIOR TO COMMENCING THE WORKS.

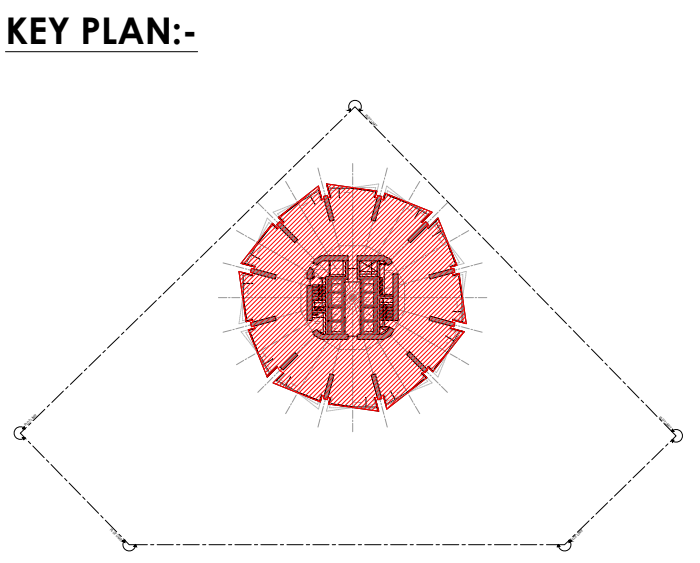

GATE LEVEL PROPOSED = (±0.00 m.) = +15.45 m. DMD LVL.

REV	DATE	DESCRIPTION	CHECK

STATUS: PRELIMINARY SUBMISSION

OWNER: ARGENTI PROPERTIES INVESTMENTS LTD

CONSULTANT: SILVER STONE ENGINEERING CONSULTANTS



PROJECT: BINGHATTI CIRCLE
2B + G + 4P + S8 TYP. FLOORS +3 MECH.+3 STR.+ ROOF

PLOT NO: JVC13RHRG001	LOCATION: AL BARSHA SOUTH FOURTH(681)
ARCH: AMAR M	STR Engg: M FLAHA
Reg. No: 114763	Reg. No: 109115
SCALE: 1:100	DRAWN: MUS
CHECKED & APPROVED: AM	

DRAWING TITLE: 7,11 & 15TH FLOORS PLAN


PROJECT NO: P025-01	DWG NO: A111	REV: 00
---------------------	--------------	---------

File Path: X:\Binghatti Project\2025-01-Binghatti Circle\01- ARCHITECTURE\01- CONCEPT\01- DWG- Pnt Date: 12-Jun-25, Time: 10:23:34 AM

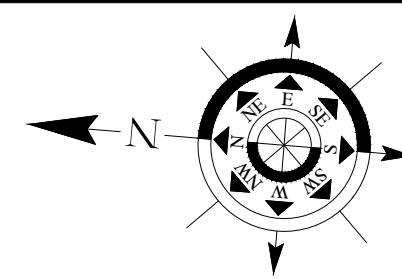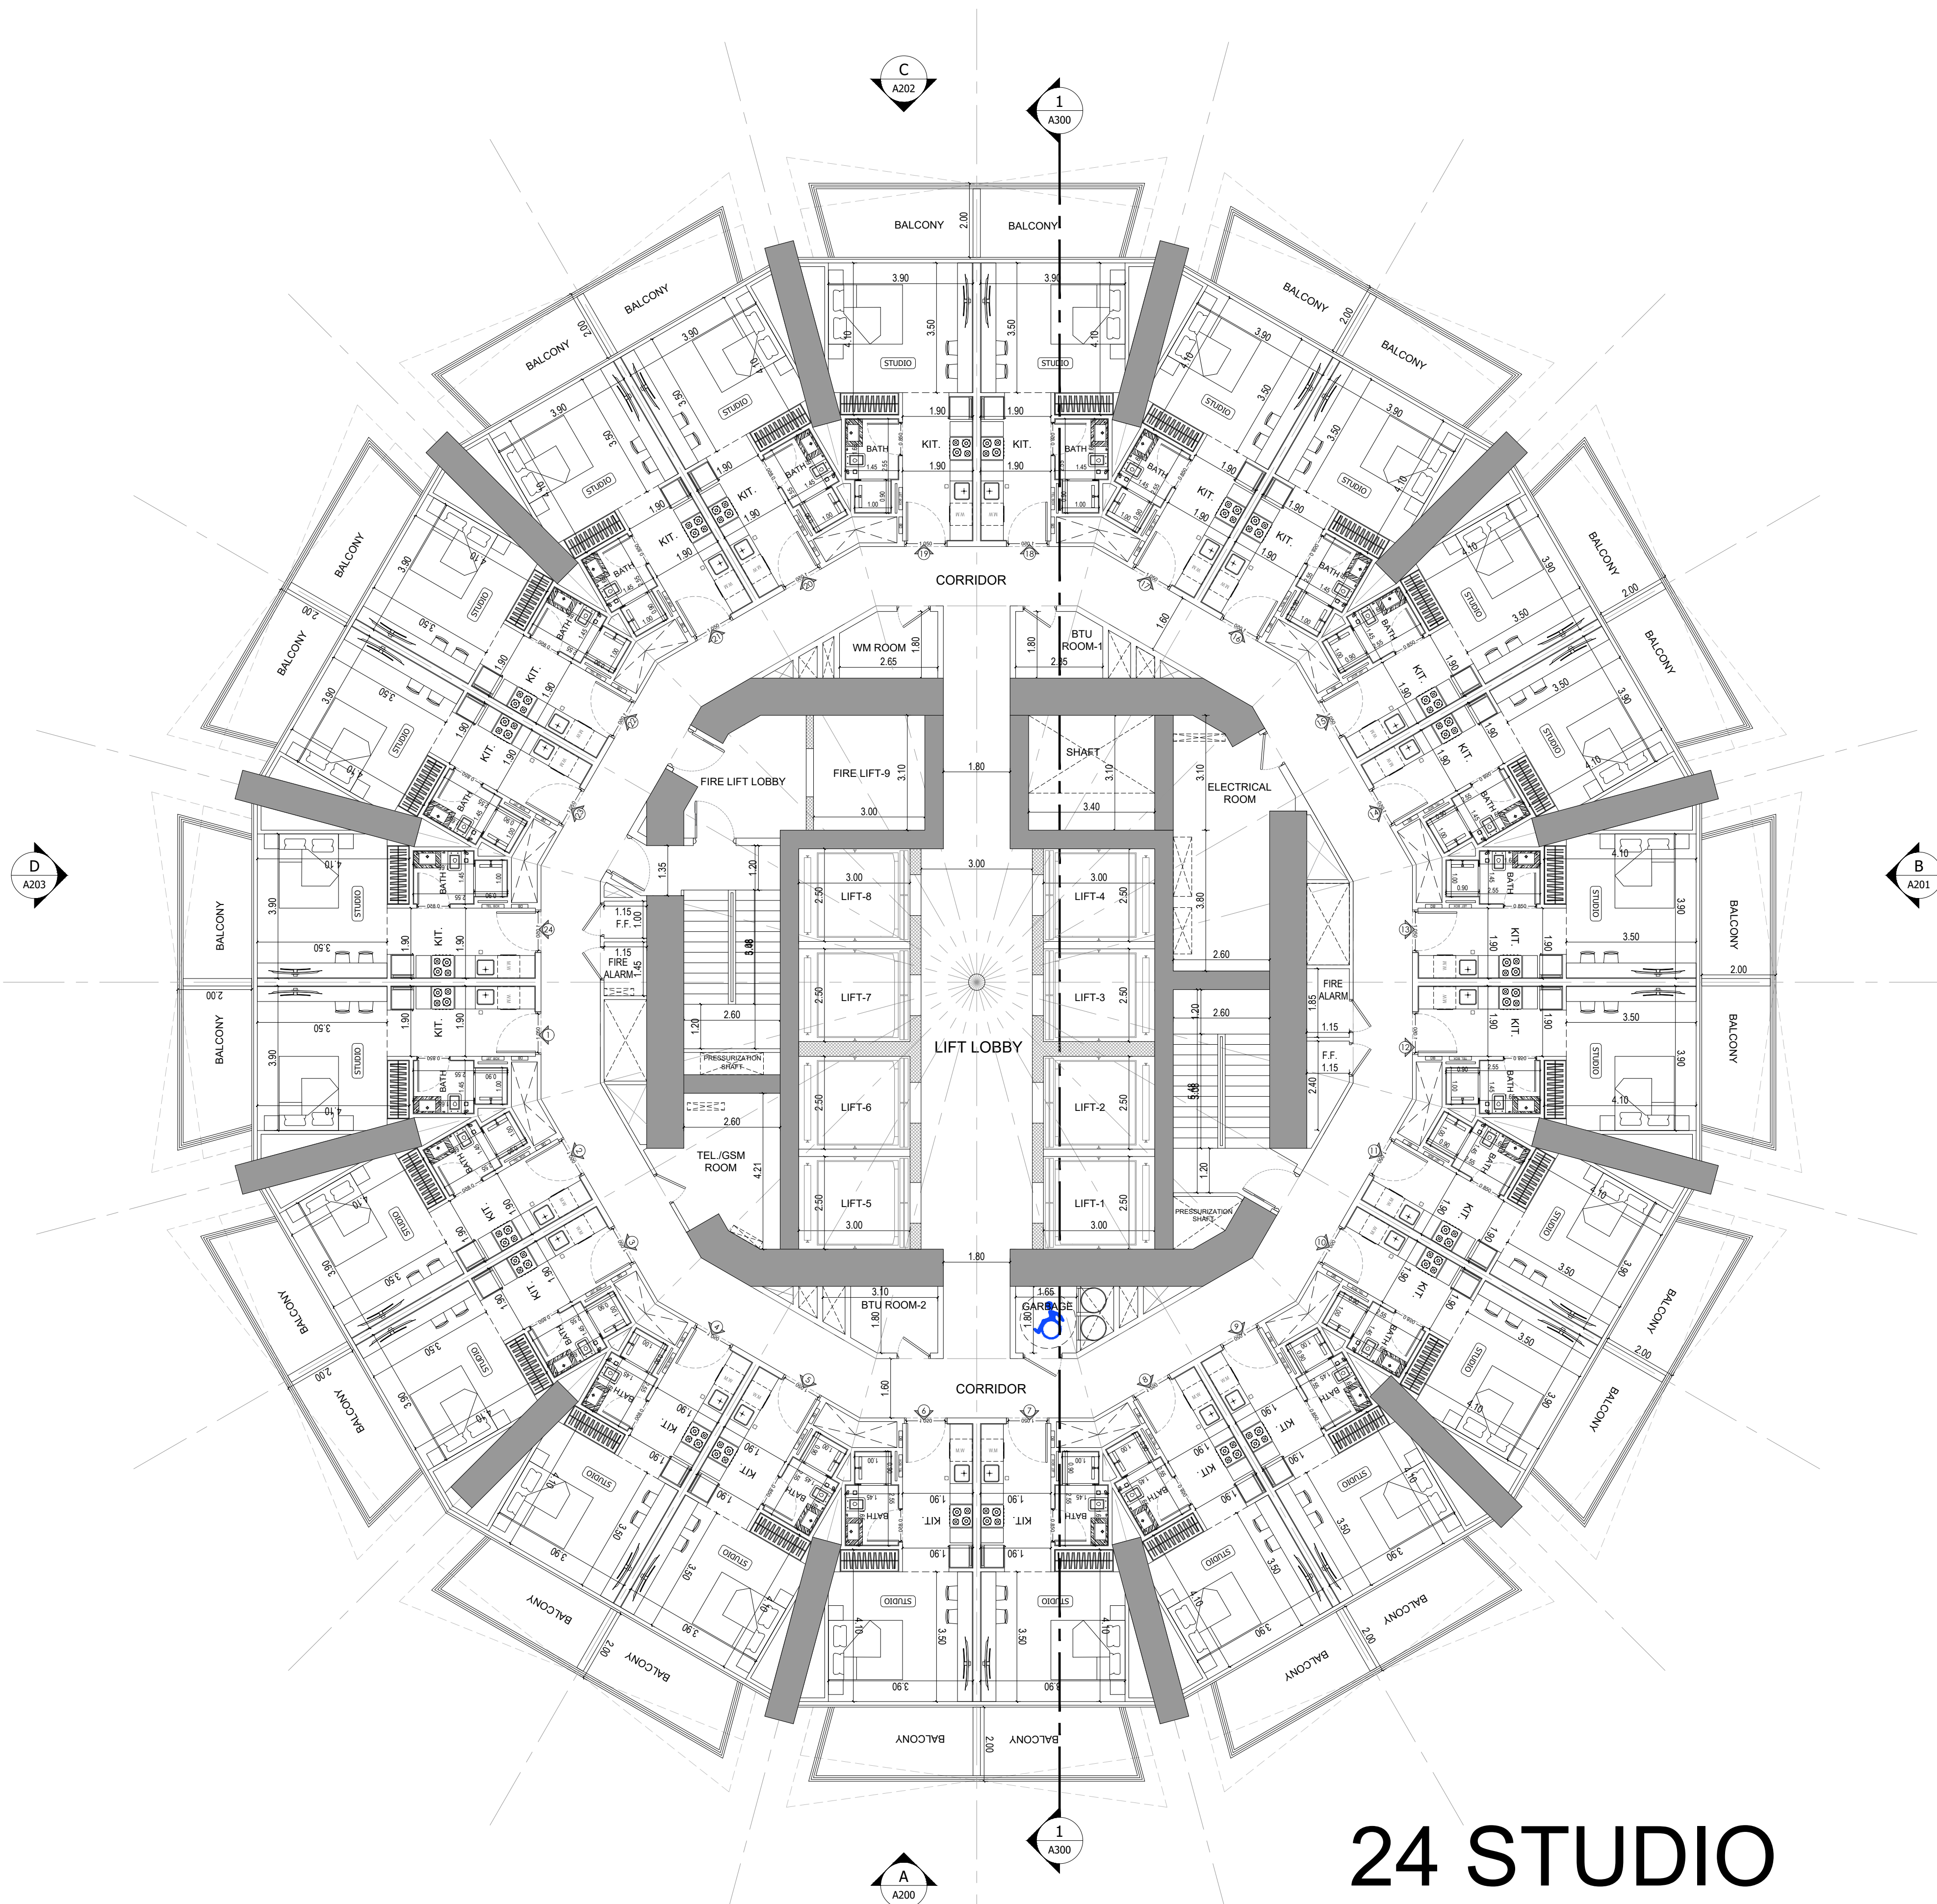

- APPROVAL STAMP:
- NOTES:
- 1.) ALL DIMENSIONS TO BE VERIFIED BY CONTRACTOR ON SITE PRIOR TO COMMENCEMENT OF ANY WORK.
 - 2.) DO NOT SCALE THIS DRAWING FOR THE PURPOSE OF MEASUREMENT. ONLY SCALE DIMENSIONS WHERE SPECIFICALLY INSTRUCTED TO DO SO.
 - 3.) ALL MEASUREMENTS ARE IN MILLIMETERS UNLESS OTHERWISE SPECIFIED.
 - 4.) DIMENSIONS SHOWN ON THESE DRAWINGS ARE STRUCTURAL DIMENSIONS UNLESS CLEARLY NOTED OTHERWISE.
 - 5.) THIS DRAWING IS TO BE READ IN CONJUNCTION WITH ALL OTHER DRAWINGS, DETAIL AND SPECIFICATIONS. ANY DISCREPANCY TO BE IMMEDIATELY BROUGHT TO THE ATTENTION OF ARCHITECT PRIOR TO COMMENCING THE WORKS.

KEY PLAN:-

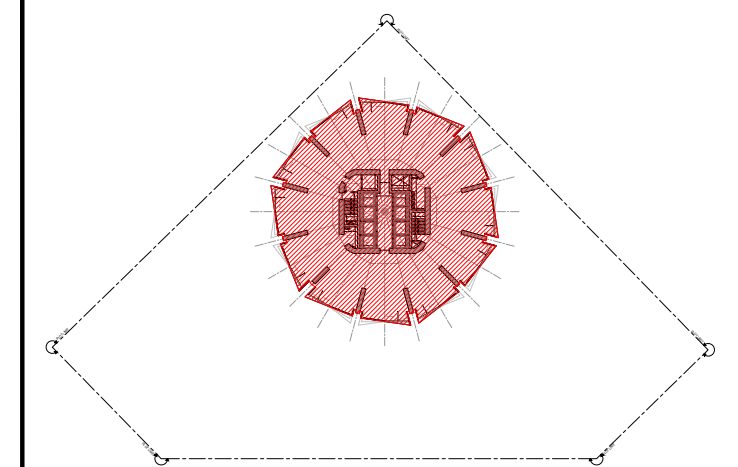

GATE LEVEL PROPOSED = (±0.00 m.) = +15.45 m. DMD LVL.

REV	DATE	DESCRIPTION	CHECK
-----	------	-------------	-------

STATUS: PRELIMINARY SUBMISSION

OWNER: ARGENTI PROPERTIES INVESTMENTS LTD

CONSULTANT: SILVER STONE ENGINEERING CONSULTANTS

PROJECT: BINGHATTI BINGHATTI CIRCLE

2B + G + 4P + 58 TYP. FLOORS +3 MECH.+3 STR.+ ROOF


1:100

DRAWING TITLE: 6,10,12 & 14TH FLOORS PLAN

PROJECT NO: P025-01 DWG NO: A112 REV: 00

1 6,10,12 & 14TH FLOORS PLAN
A112 SCALE - 1:100

24 STUDIO

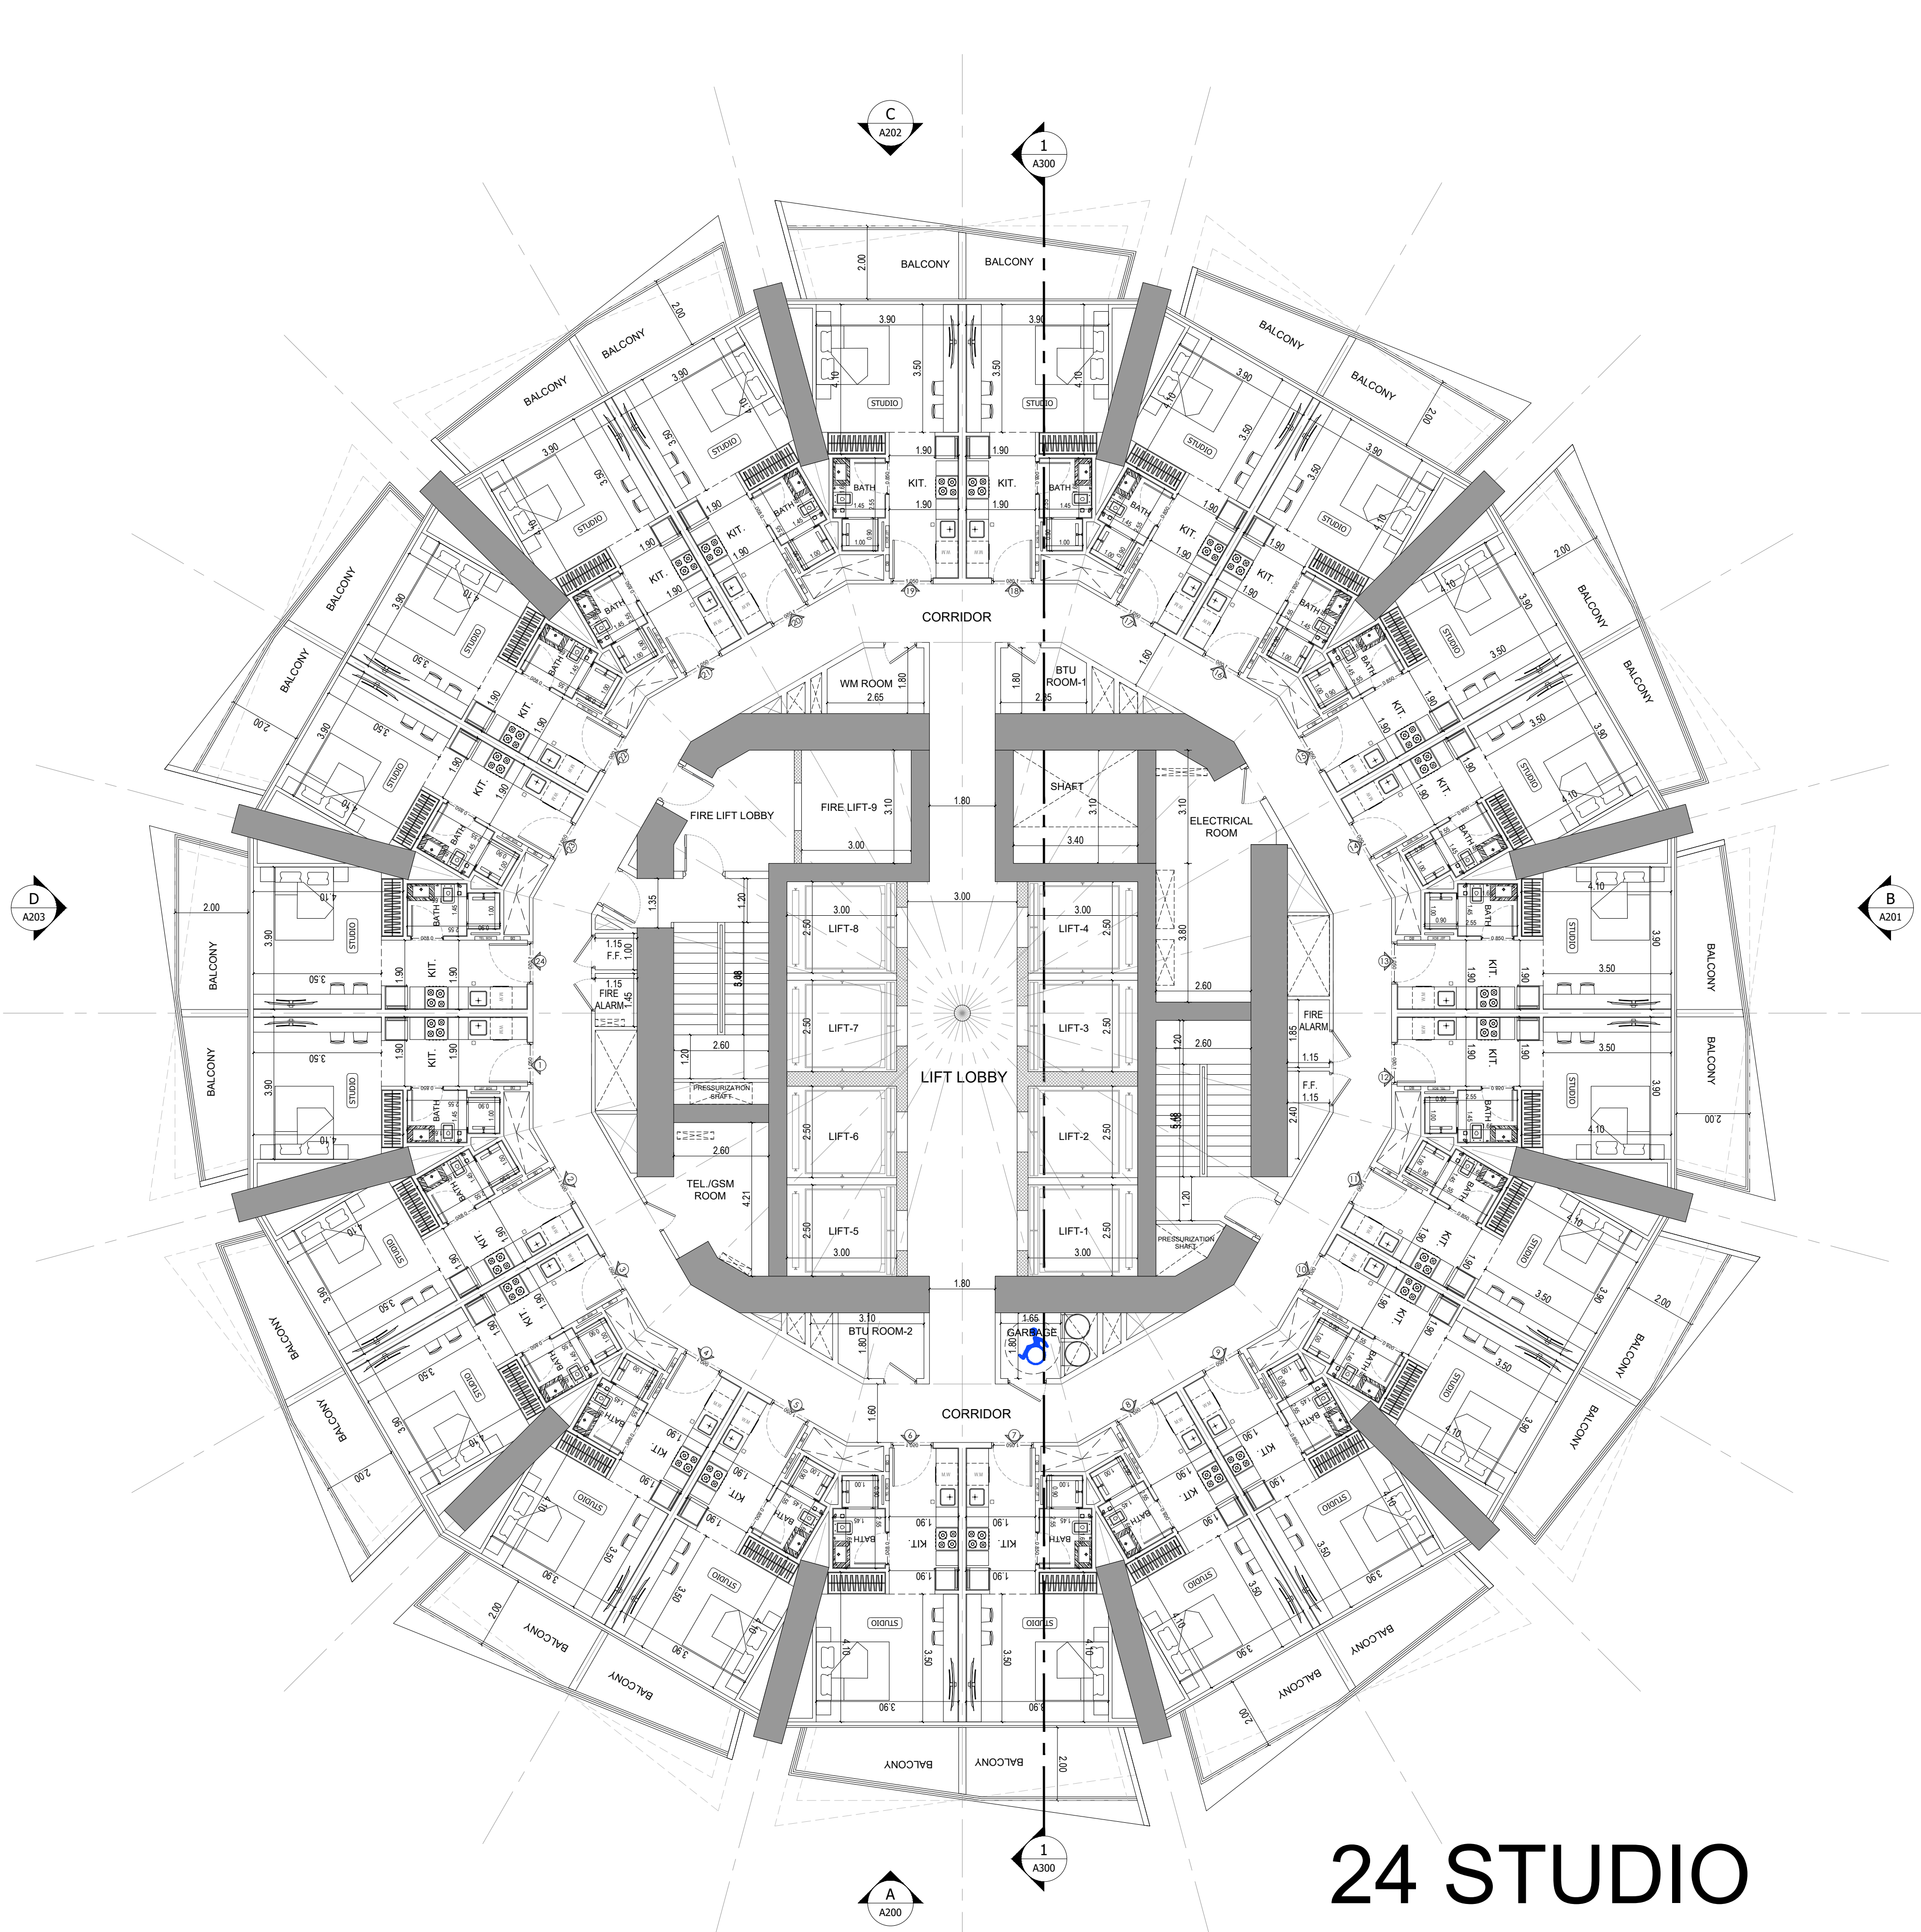


24 STUDIO

1 5TH & 13TH FLOORS PLAN
A113 SCALE - 1:100

APPROVAL STAMP:

NOTES:

- 1.) ALL DIMENSIONS TO BE VERIFIED BY CONTRACTOR ON SITE PRIOR TO COMMENCEMENT OF ANY WORK.
- 2.) DO NOT SCALE THIS DRAWING FOR THE PURPOSE OF MEASUREMENT. ONLY SCALE DIMENSIONS WHERE SPECIFICALLY INSTRUCTED TO DO SO.
- 3.) ALL MEASUREMENTS ARE IN MILLIMETERS UNLESS OTHERWISE SPECIFIED.
- 4.) DIMENSIONS SHOWN ON THESE DRAWINGS ARE STRUCTURAL DIMENSIONS UNLESS CLEARLY NOTED OTHERWISE.
- 5.) THIS DRAWING IS TO BE READ IN CONJUNCTION WITH ALL OTHER DRAWINGS, DETAIL AND SPECIFICATIONS. ANY DISCREPANCY TO BE IMMEDIATELY BROUGHT TO THE ATTENTION OF ARCHITECT PRIOR TO COMMENCING THE WORKS.

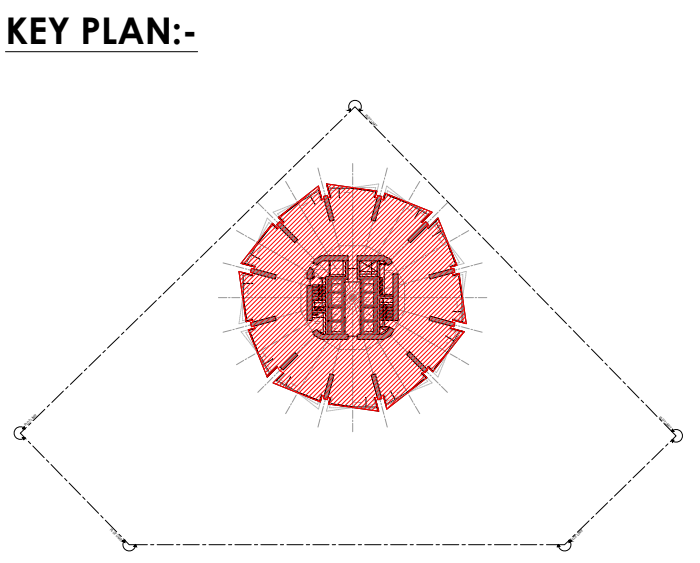

GATE LEVEL PROPOSED = (±0.00 m.) = +15.45 m. DMD LVL.

REV	DATE	DESCRIPTION	CHECK

STATUS: PRELIMINARY SUBMISSION

OWNER: ARGENTI PROPERTIES INVESTMENTS LTD


CONSULTANT: SILVER STONE ENGINEERING CONSULTANTS

PROJECT: BINGHATTI CIRCLE
2B + G + 4P + S8 TYP. FLOORS +3 MECH.+3 STR.+ ROOF

PLOT NO: JVC13RHRG001	LOCATION: AL BARSHA SOUTH FOURTH(681)
ARCH: AMAR M	STR Engg: M FLAHA
Reg. No: 114763	Reg. No: 109115
SCALE: 1:100	DRAWN: MUS
CHECKED & APPROVED: AM	

DRAWING TITLE: 5TH & 13TH FLOORS PLAN

PROJECT NO: P025-01	DWG NO: A113	REV: 00
---------------------	--------------	---------

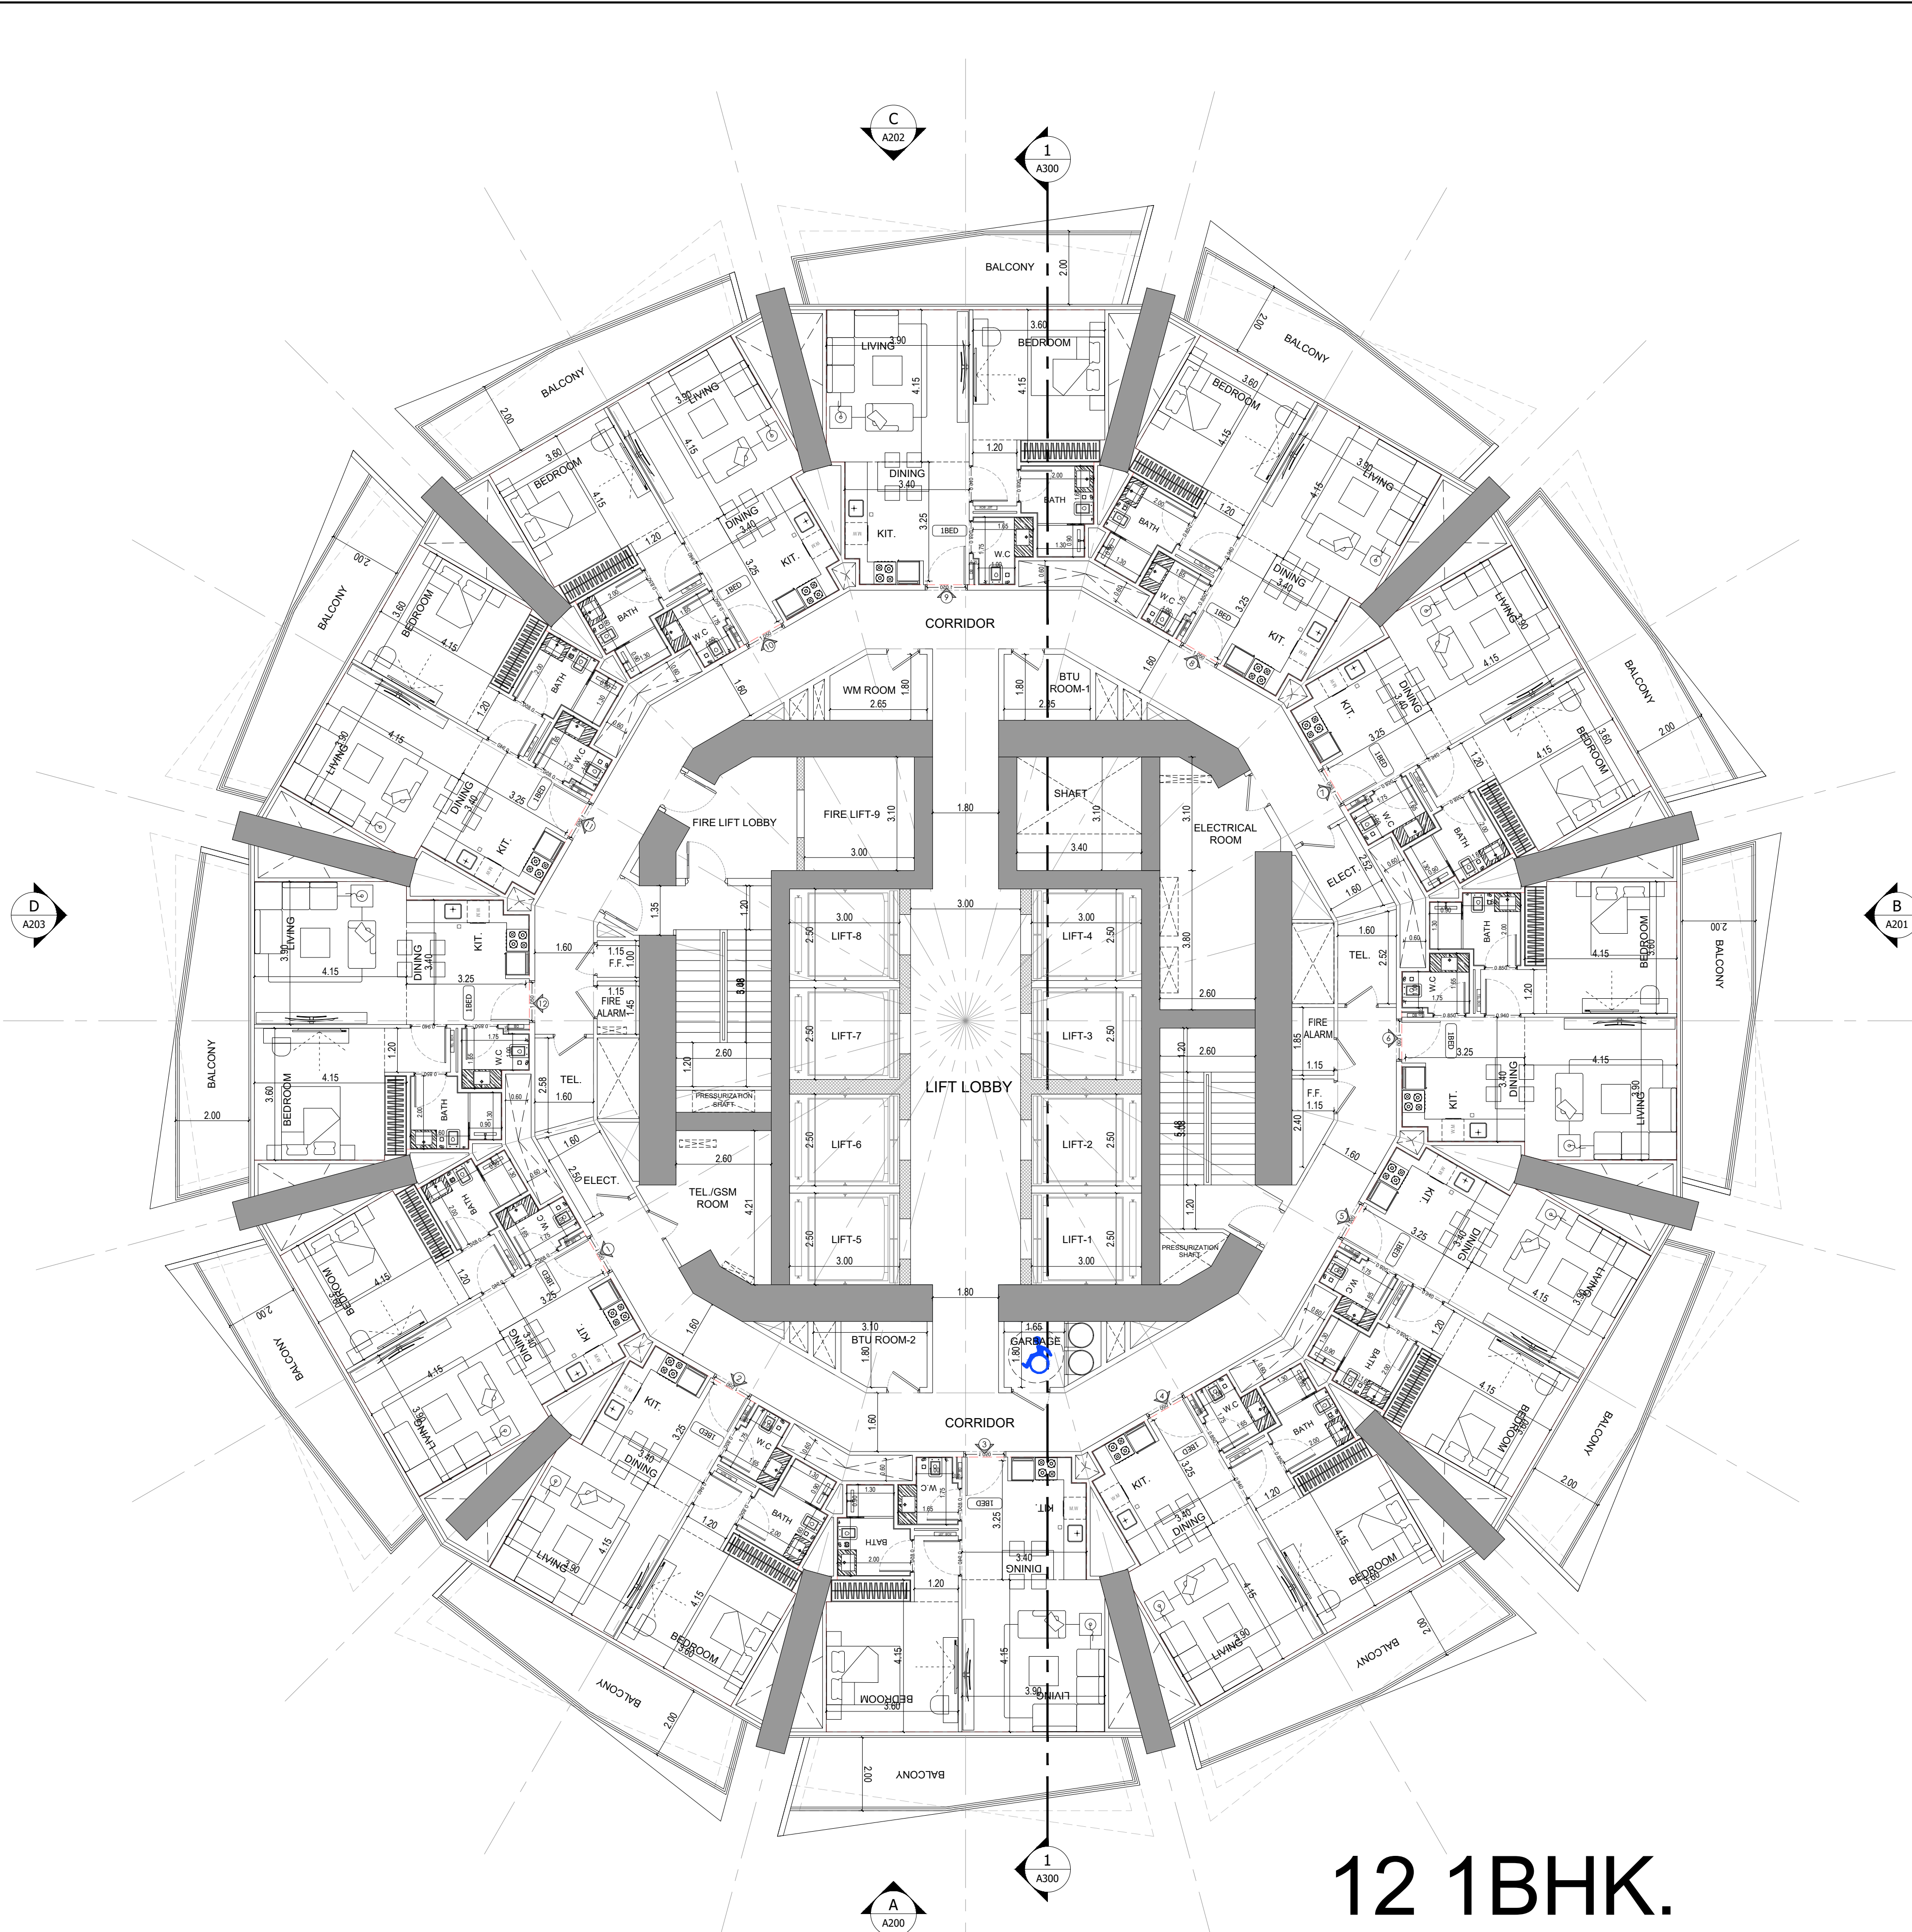


12 1BHK.

1 19,23,31,35,39,43,47,51,55 & 59TH FLOORS PLAN
A114 SCALE - 1:100

APPROVAL STAMP:

NOTES:

- 1.) ALL DIMENSIONS TO BE VERIFIED BY CONTRACTOR ON SITE PRIOR TO COMMENCEMENT OF ANY WORK.
- 2.) DO NOT SCALE THIS DRAWING FOR THE PURPOSE OF MEASUREMENT. ONLY SCALE DIMENSIONS WHERE SPECIFICALLY INSTRUCTED TO DO SO.
- 3.) ALL MEASUREMENTS ARE IN MILLIMETERS UNLESS OTHERWISE SPECIFIED.
- 4.) DIMENSIONS SHOWN ON THESE DRAWINGS ARE STRUCTURAL DIMENSIONS UNLESS CLEARLY NOTED OTHERWISE.
- 5.) THIS DRAWING IS TO BE READ IN CONJUNCTION WITH ALL OTHER DRAWINGS, DETAIL AND SPECIFICATIONS. ANY DISCREPANCY TO BE IMMEDIATELY BROUGHT TO THE ATTENTION OF ARCHITECT PRIOR TO COMMENCING THE WORKS.

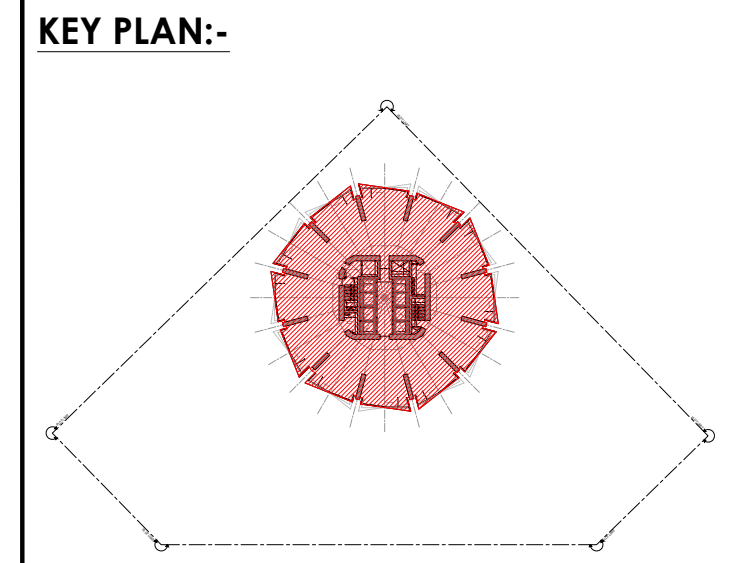

GATE LEVEL PROPOSED = (±0.00 m.) = +15.45 m. DMD LVL.

REV	DATE	DESCRIPTION	CHECK

STATUS : **PRELIMINARY SUBMISSION**

OWNER: **ARGENTI PROPERTIES INVESTMENTS LTD**


CONSULTANT: **SILVER STONE ENGINEERING CONSULTANTS**

PROJECT : **BINGHATTI CIRCLE**
2B + G + 4P + 58 TYP. FLOORS +3 MECH.+3 STR.+ ROOF

PLOT NO: JVC13RHRG001	LOCATION: AL BARSHA SOUTH FOURTH(681)
ARCH: AMAR M	STR Engg: M FLAHA
Reg. No: 114763	Reg. No: 109115
SCALE: 1:100	DRAWN: MUS
CHECKED & APPROVED: AM	

DRAWING TITLE: **19,23,31,35,39,43,47,51,55 & 59TH FLOORS PLAN**

PROJECT NO: P025-01	DWG NO: A114	REV: 00
-------------------------------	------------------------	-------------------

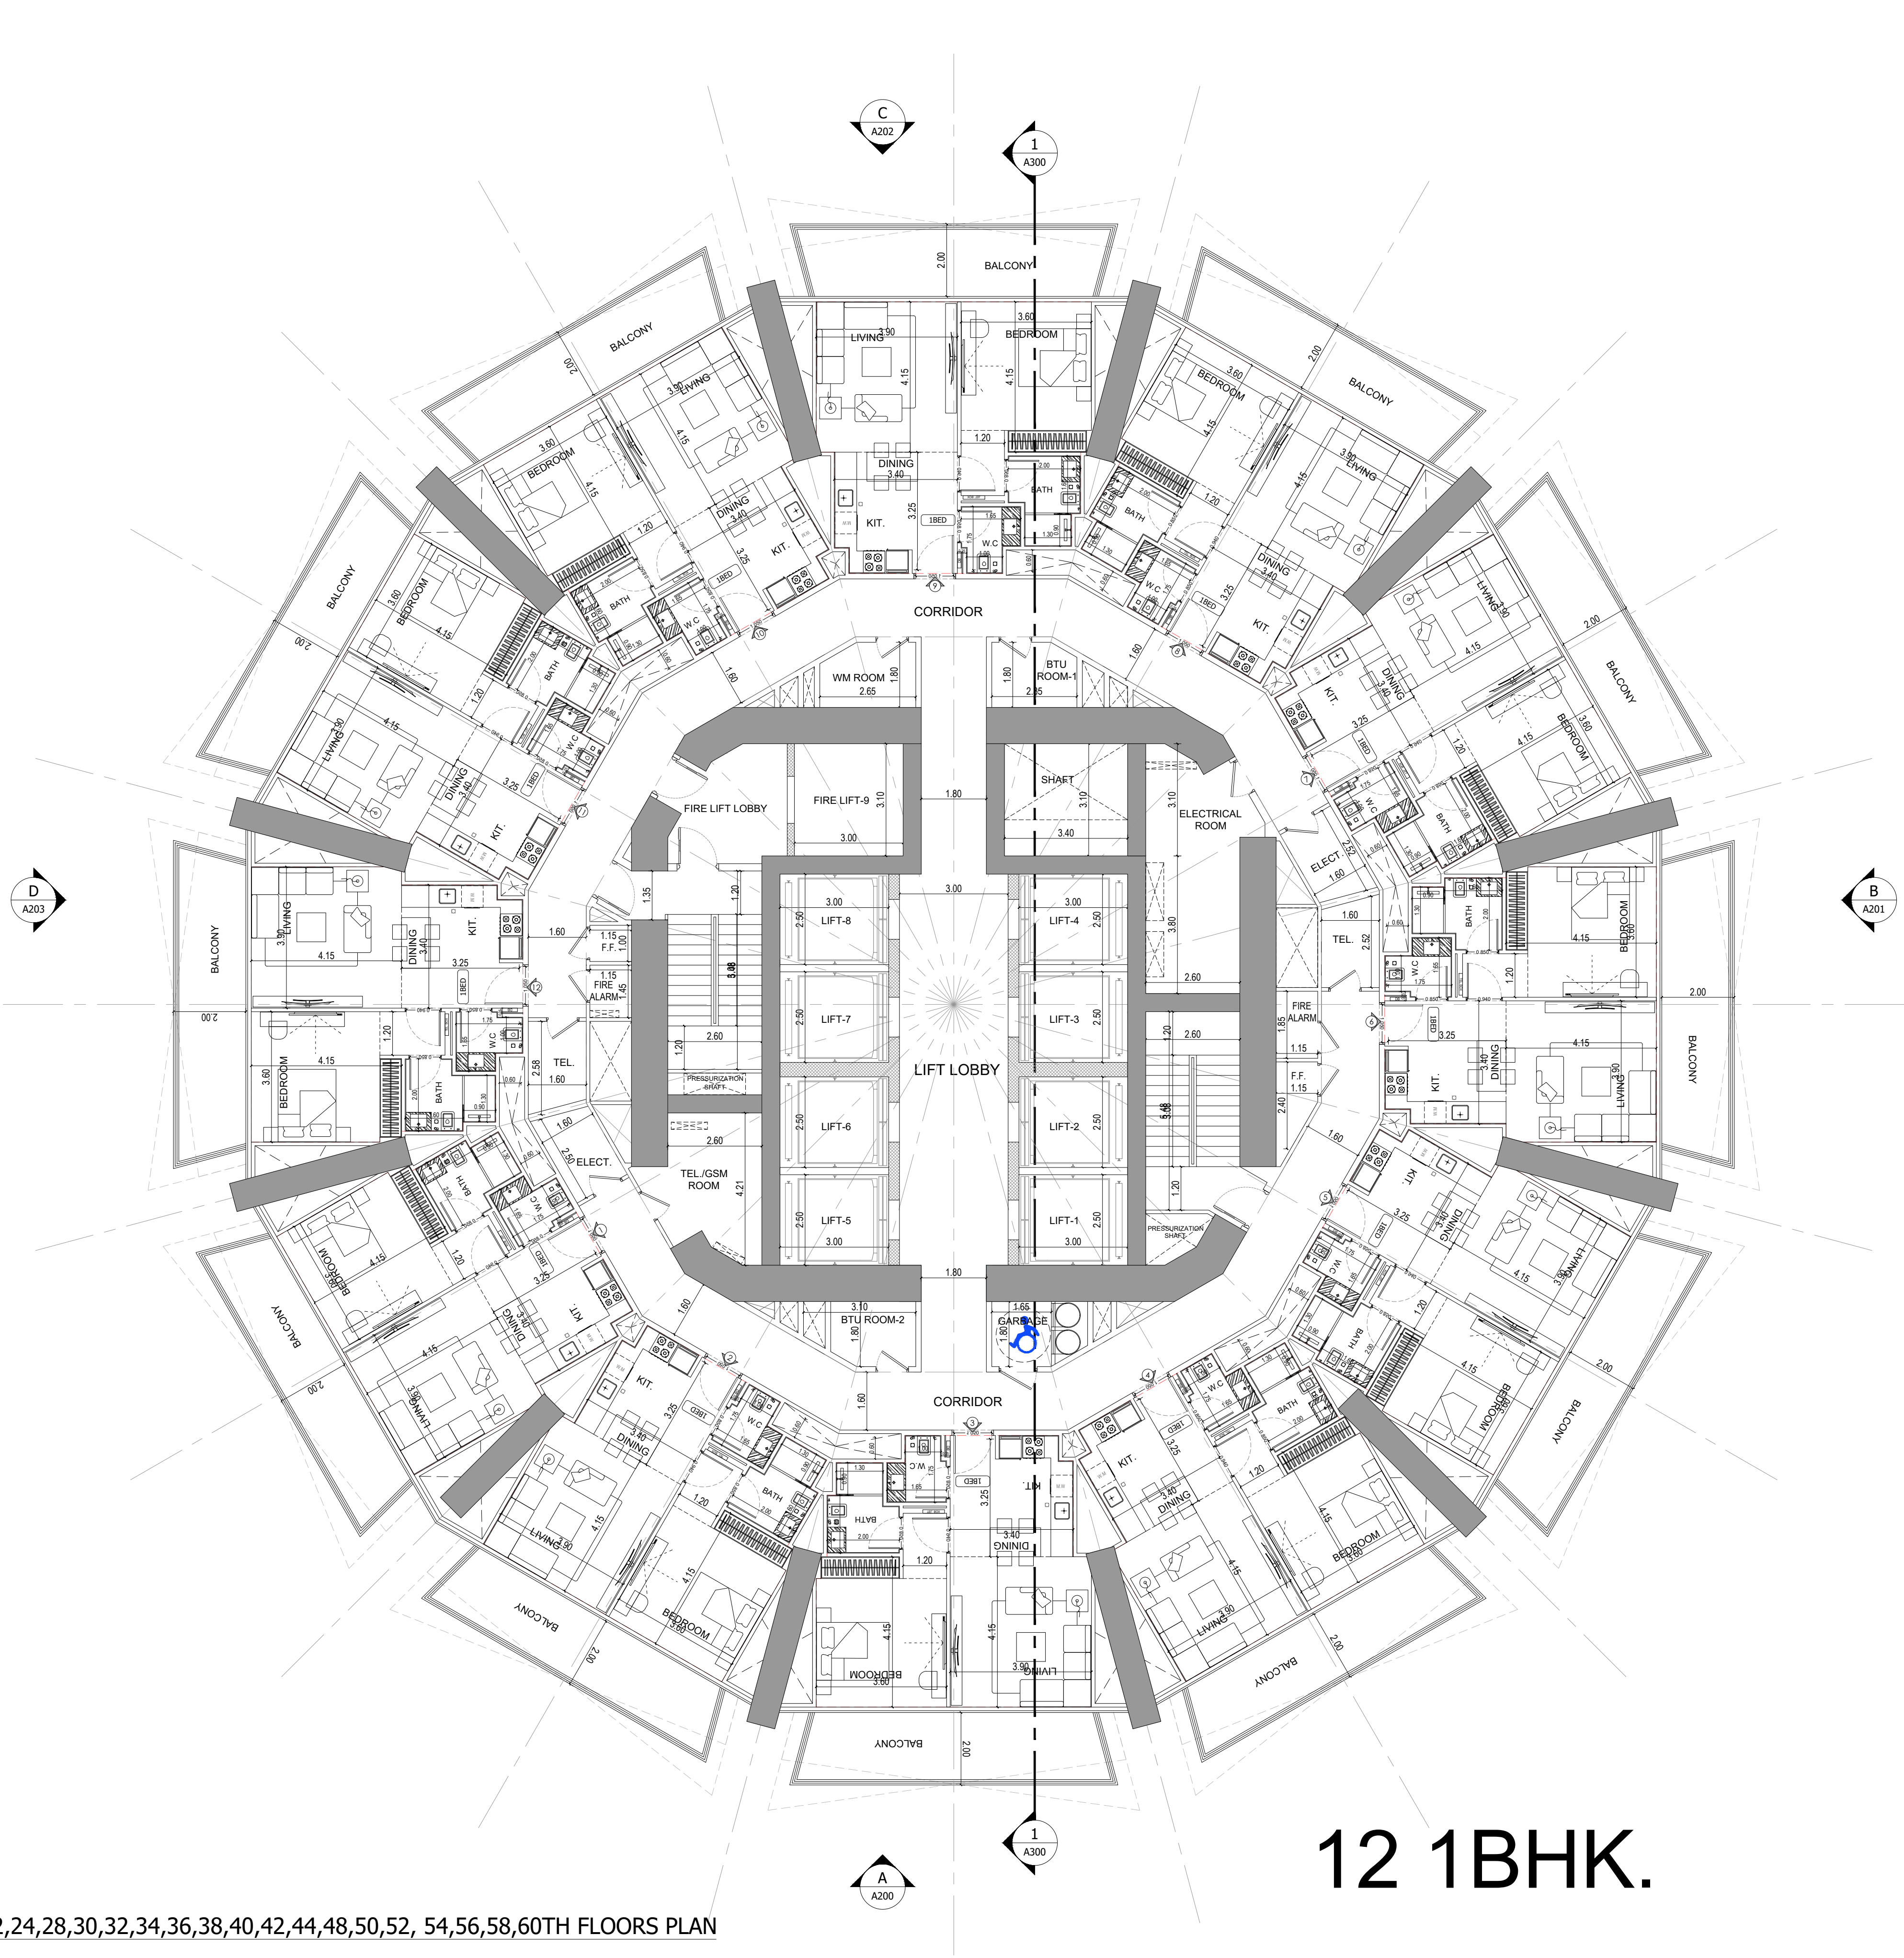


12 1BHK.

1 16,18,20,22,24,28,30,32,34,36,38,40,42,44,48,50,52, 54,56,58,60TH FLOORS PLAN
A115 SCALE - 1:100

APPROVAL STAMP:

NOTES:

- 1.) ALL DIMENSIONS TO BE VERIFIED BY CONTRACTOR ON SITE PRIOR TO COMMENCEMENT OF ANY WORK.
- 2.) DO NOT SCALE THIS DRAWING FOR THE PURPOSE OF MEASUREMENT. ONLY SCALE DIMENSIONS WHERE SPECIFICALLY INSTRUCTED TO DO SO.
- 3.) ALL MEASUREMENTS ARE IN MILLIMETERS UNLESS OTHERWISE SPECIFIED.
- 4.) DIMENSIONS SHOWN ON THESE DRAWINGS ARE STRUCTURAL DIMENSIONS UNLESS CLEARLY NOTED OTHERWISE.
- 5.) THIS DRAWING IS TO BE READ IN CONJUNCTION WITH ALL OTHER DRAWINGS, DETAIL AND SPECIFICATIONS. ANY DISCREPANCY TO BE IMMEDIATELY BROUGHT TO THE ATTENTION OF ARCHITECT PRIOR TO COMMENCING THE WORKS.

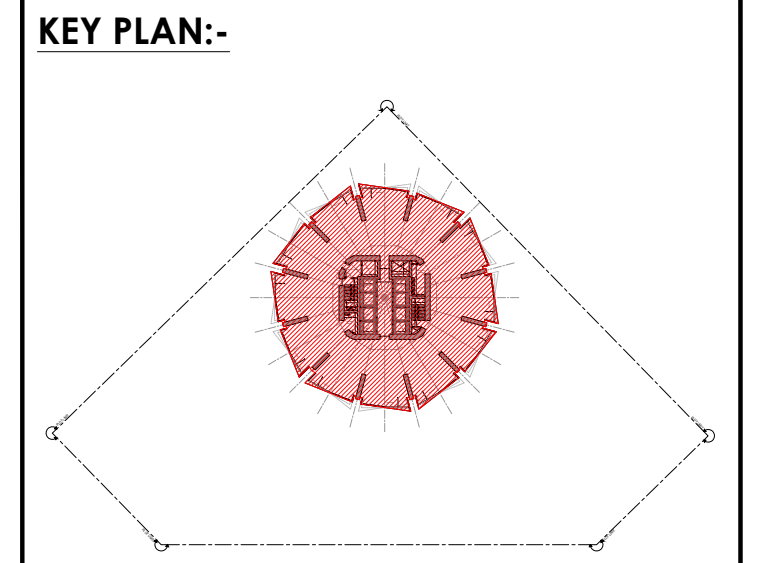

GATE LEVEL PROPOSED = (±0.00 m.) = +15.45 m. DMD LVL.

REV	DATE	DESCRIPTION	CHECK

STATUS : PRELIMINARY SUBMISSION

OWNER: ARGENTI PROPERTIES INVESTMENTS LTD

CONSULTANT: SILVER STONE ENGINEERING CONSULTANTS

PROJECT : BINGHATTI CIRCLE
2B + G + 4P + S8 TYP. FLOORS +3 MECH.+3 STR.+ ROOF



PLOT NO: JVC13RHRG001	LOCATION: AL BARSHA SOUTH FOURTH(681)
ARCH: AMAR M	STR Engg: M FLAHA
Reg. No: 114763	Reg. No: 109115
SCALE: DRAWN: MUS	CHECKED & APPROVED: AM

1:100

DRAWING TITLE: 16,18,20,22,24,28,30,32,34,36,38,40,42,44,48,50, 52, 54,56,58,60TH FLOORS PLAN

PROJECT NO: P025-01	DWG NO: A115	REV: 00
---------------------	--------------	---------


File Path: X:\Binghatti Project\2025-01-Binghatti Circle\01- ARCHITECTURE\01- CONCEPT\01- DWG- Prit Date: 12-Jun-25, Time: 10:23:34 AM

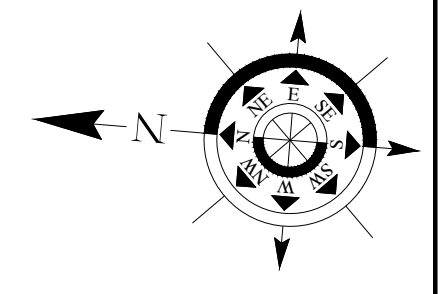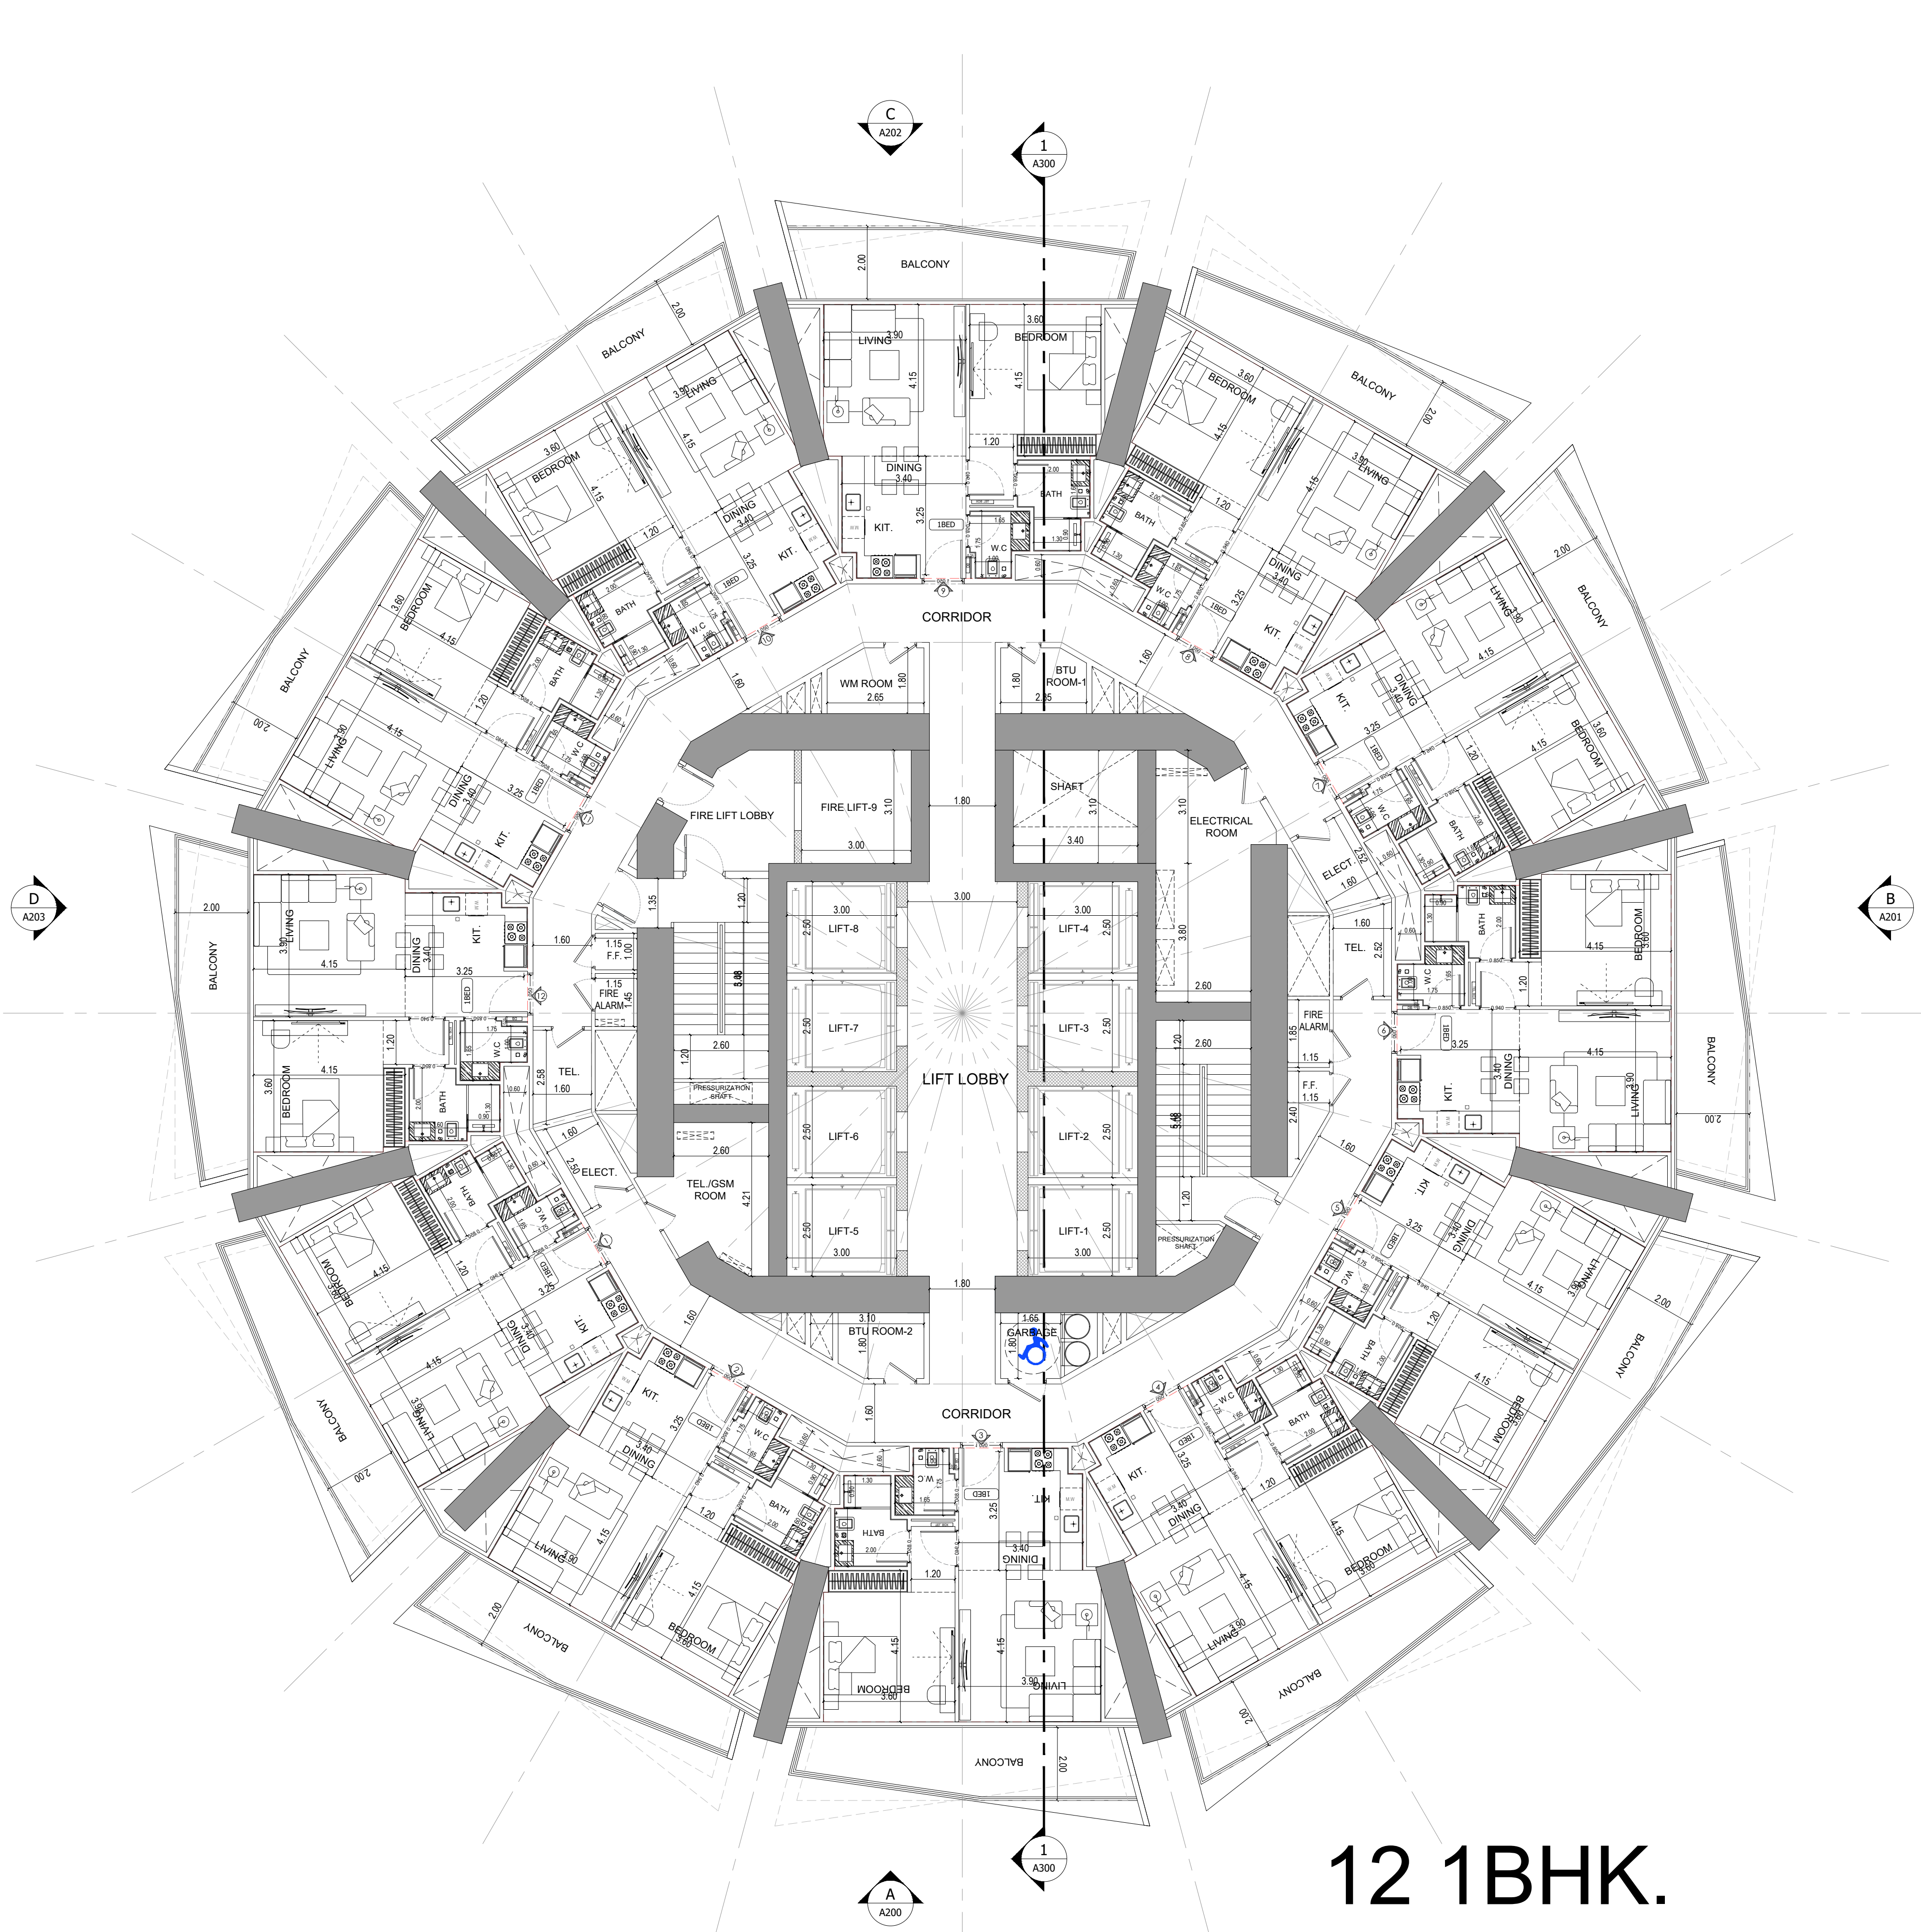

APPROVAL STAMP:

NOTES:

- 1.) ALL DIMENSIONS TO BE VERIFIED BY CONTRACTOR ON SITE PRIOR TO COMMENCEMENT OF ANY WORK.
- 2.) DO NOT SCALE THIS DRAWING FOR THE PURPOSE OF MEASUREMENT. ONLY SCALE DIMENSIONS WHERE SPECIFICALLY INSTRUCTED TO DO SO.
- 3.) ALL MEASUREMENTS ARE IN MILLIMETERS UNLESS OTHERWISE SPECIFIED.
- 4.) DIMENSIONS SHOWN ON THESE DRAWINGS ARE STRUCTURAL DIMENSIONS UNLESS CLEARLY NOTED OTHERWISE.
- 5.) THIS DRAWING IS TO BE READ IN CONJUNCTION WITH ALL OTHER DRAWINGS, DETAIL AND SPECIFICATIONS. ANY DISCREPANCY TO BE IMMEDIATELY BROUGHT TO THE ATTENTION OF ARCHITECT PRIOR TO COMMENCING THE WORKS.

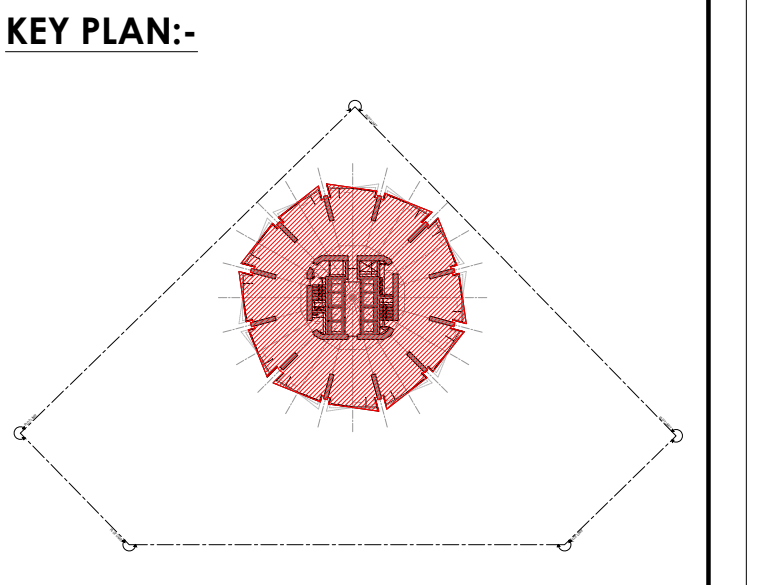

GATE LEVEL PROPOSED = (±0.00 m.) = +15.45 m. DMD LVL.

REV	DATE	DESCRIPTION	CHECK

STATUS: PRELIMINARY SUBMISSION

OWNER: ARGENTI PROPERTIES INVESTMENTS LTD

CONSULTANT: SILVER STONE ENGINEERING CONSULTANTS

PROJECT: BINGHATTI CIRCLE
2B + G + 4P + S8 TYP. FLOORS +3 MECH.+3 STR.+ ROOF

PLOT NO: JVC13RHRG001	LOCATION: AL BARSHA SOUTH FOURTH(681)
ARCH: AMAR M	STR Engg: M FLAHA
Reg. No: 114763	Reg. No: 109115
SCALE: DRAWN: MUS	CHECKED & APPROVED: AM


1:100

DRAWING TITLE: 17,21,25,29,33,37,41,49,53,57 & 61ST FLOORS PLAN

PROJECT NO: P025-01	DWG NO: A116	REV: 00
------------------------	-----------------	------------


1 17,21,25,29,33,37,41,49,53,57 & 61ST FLOORS PLAN
A116 SCALE - 1:100

12 1BHK.

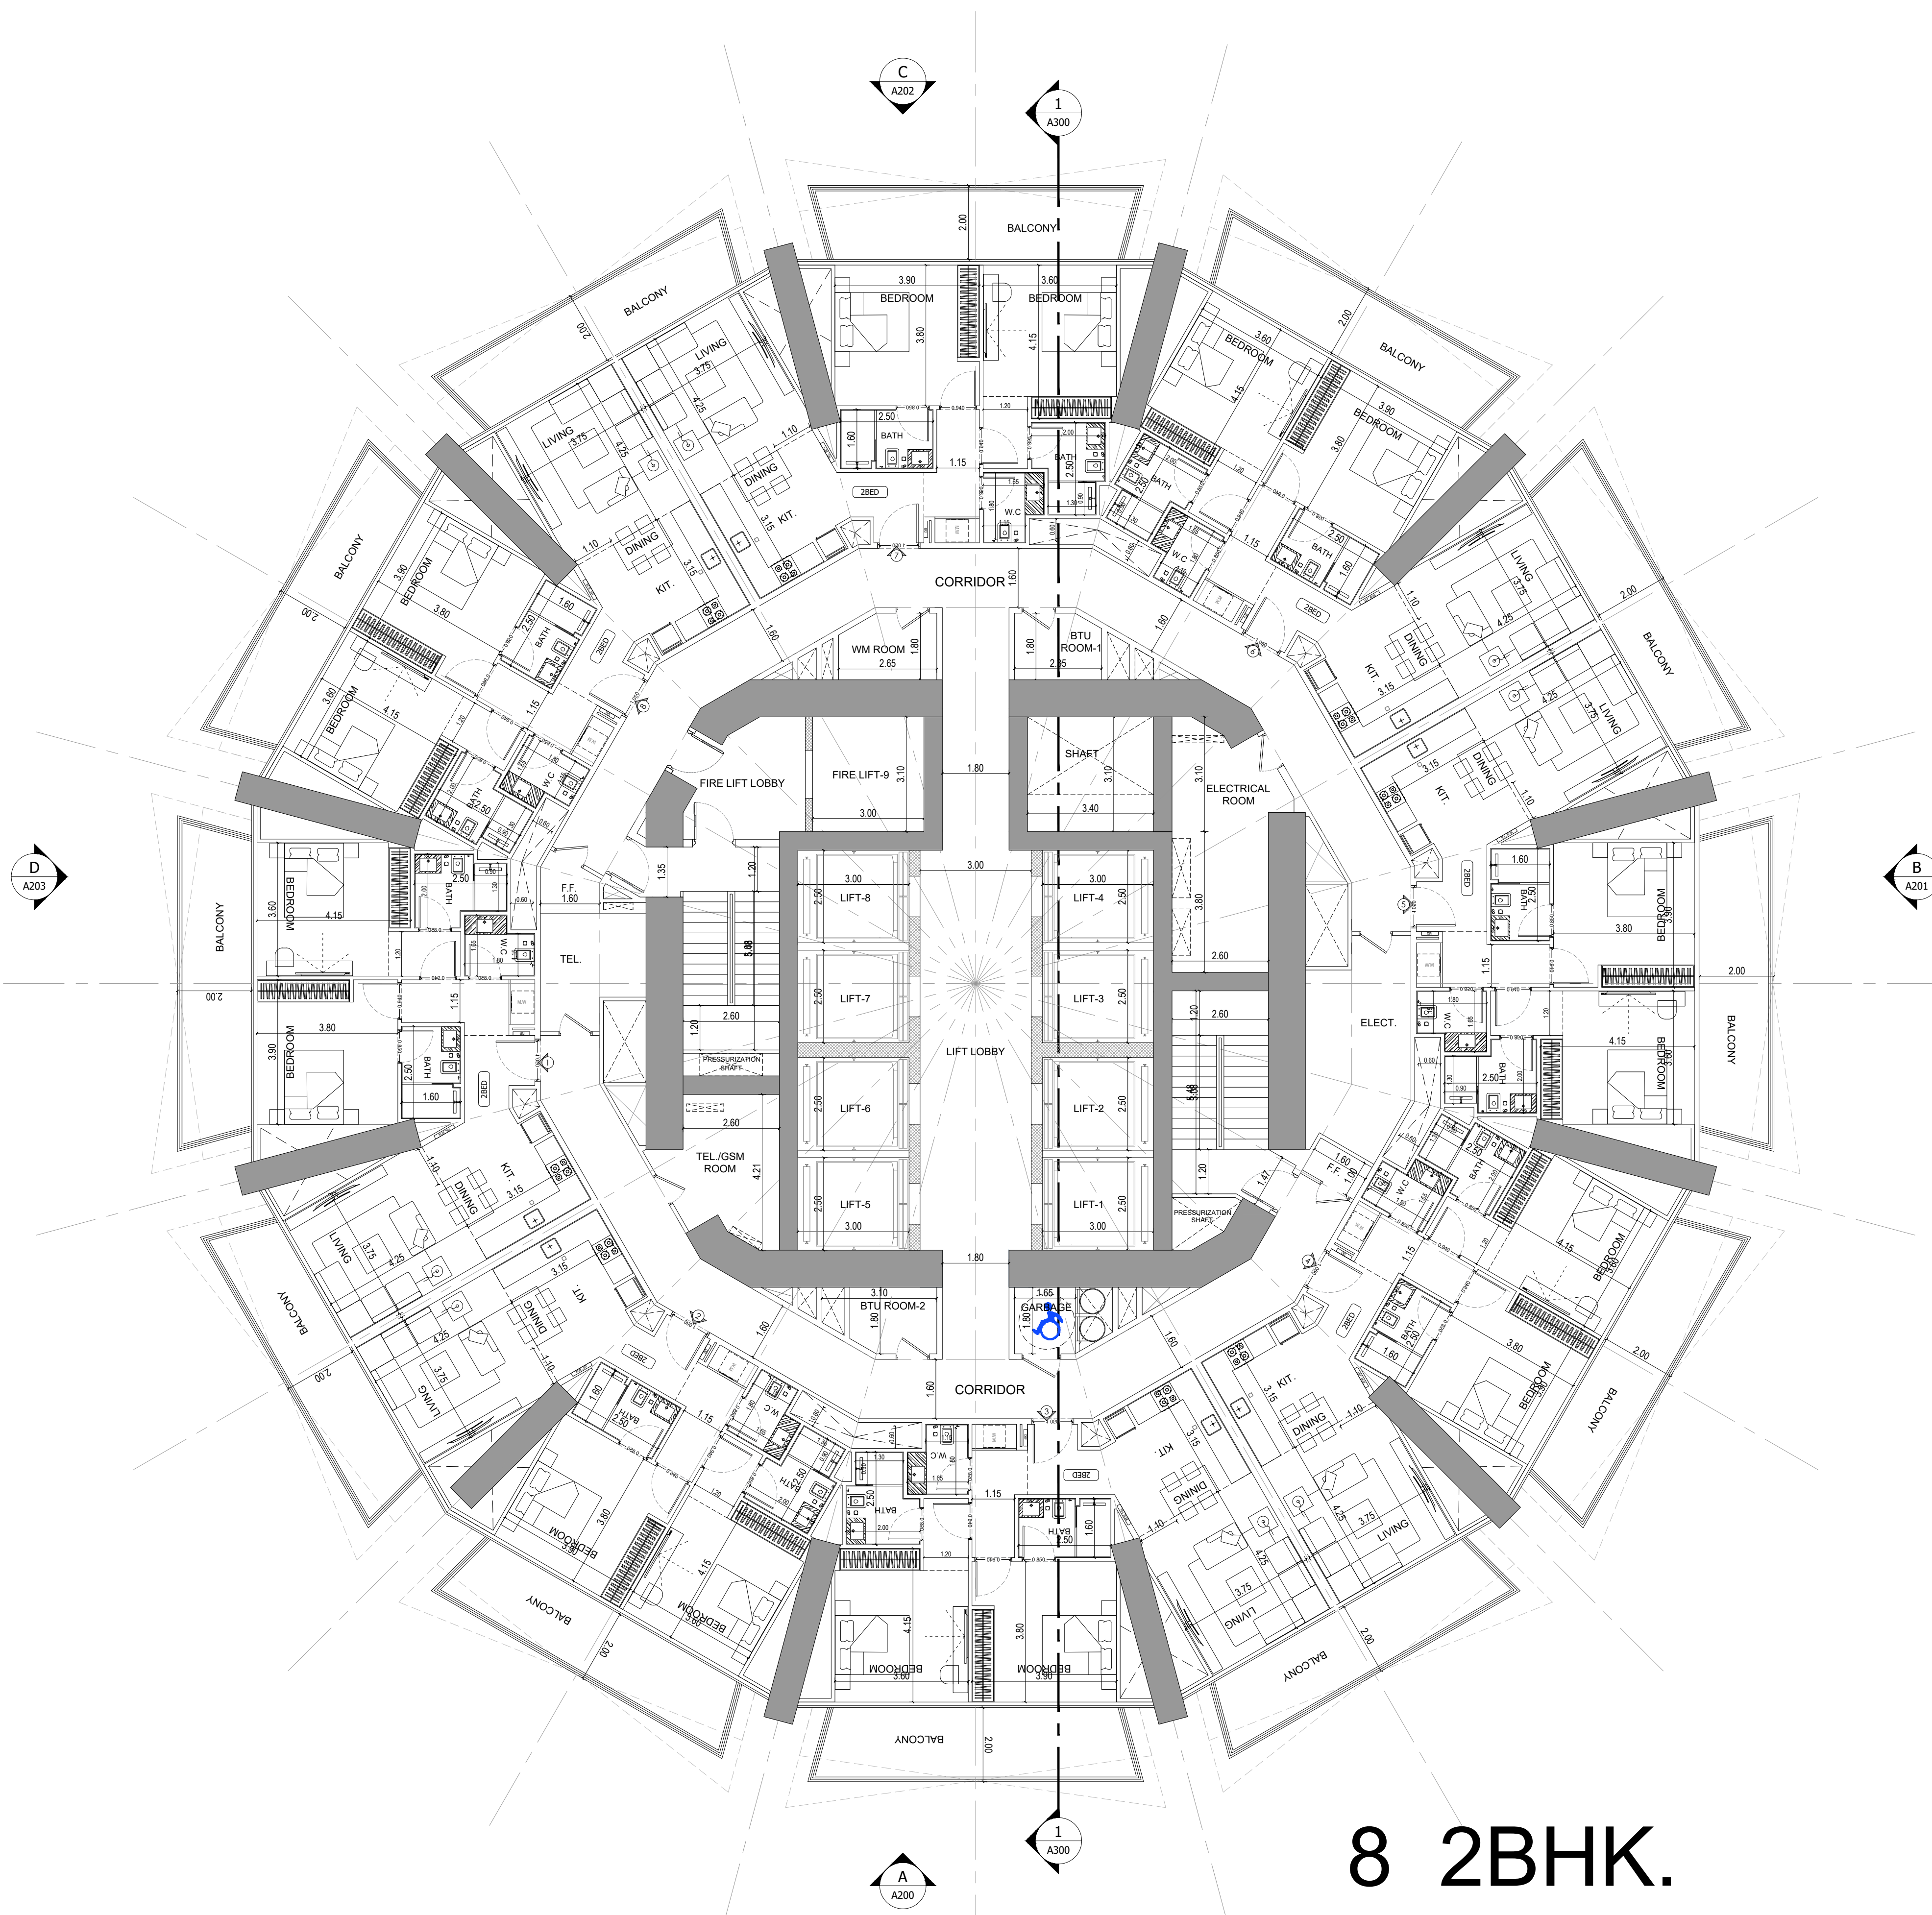

1 62ND FLOOR PLAN
A117 SCALE - 1:100


8 2BHK.

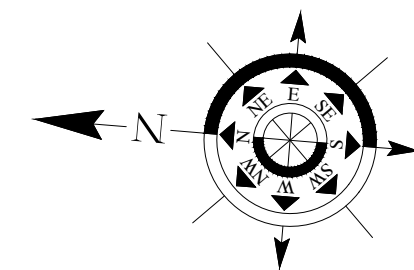

APPROVAL STAMP:

NOTES:

- 1.) ALL DIMENSIONS TO BE VERIFIED BY CONTRACTOR ON SITE PRIOR TO COMMENCEMENT OF ANY WORK.
- 2.) DO NOT SCALE THIS DRAWING FOR THE PURPOSE OF MEASUREMENT. ONLY SCALE DIMENSIONS WHERE SPECIFICALLY INSTRUCTED TO DO SO.
- 3.) ALL MEASUREMENTS ARE IN MILLIMETERS UNLESS OTHERWISE SPECIFIED.
- 4.) DIMENSIONS SHOWN ON THESE DRAWINGS ARE STRUCTURAL DIMENSIONS UNLESS CLEARLY NOTED OTHERWISE.
- 5.) THIS DRAWING IS TO BE READ IN CONJUNCTION WITH ALL OTHER DRAWINGS, DETAIL AND SPECIFICATIONS. ANY DISCREPANCY TO BE IMMEDIATELY BROUGHT TO THE ATTENTION OF ARCHITECT PRIOR TO COMMENCING THE WORKS.

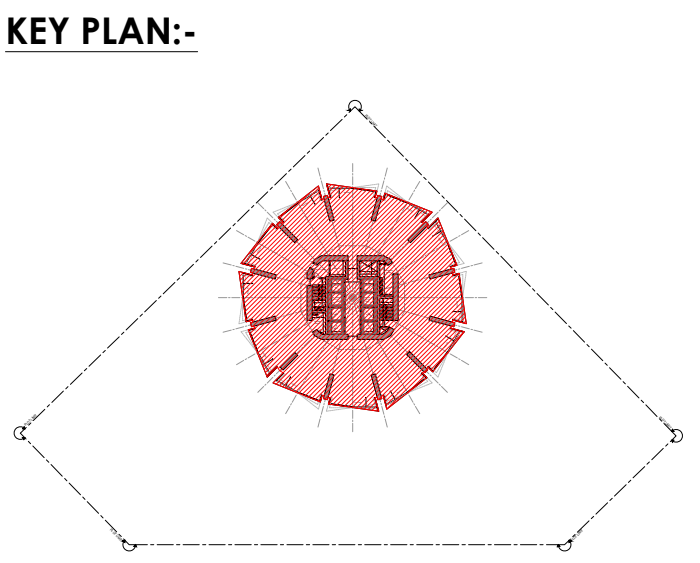

GATE LEVEL PROPOSED = (±0.00 m.) = +15.45 m. DMD LVL.

REV	DATE	DESCRIPTION	CHECK

STATUS: PRELIMINARY SUBMISSION

OWNER: ARGENTI PROPERTIES INVESTMENTS LTD

CONSULTANT: SILVER STONE ENGINEERING CONSULTANTS


PROJECT: BINGHATTI CIRCLE
2B + G + 4P + S8 TYP. FLOORS +3 MECH.+3 STR.+ ROOF

PROJECT NO: JVC13RHRG001	LOCATION: AL BARSHA SOUTH FOURTH(681)
ARCH: AMAR M	STR Engg: M FLAHA
Reg. No: 114763	Reg. No: 109115
SCALE: 1:100	DRAWN: MUS
CHECKED & APPROVED: AM	

DRAWING TITLE: 62ND FLOOR PLAN


PROJECT NO: P025-01	DWG NO: A117	REV: 00
------------------------	-----------------	------------

File Path: X:\Binghatti Project\025-01-Binghatti Circle\01- ARCHITECTURE\01- CONCEPT\01- DWG- P11 Date: 12-Jun-25, Time: 10:23:34 AM

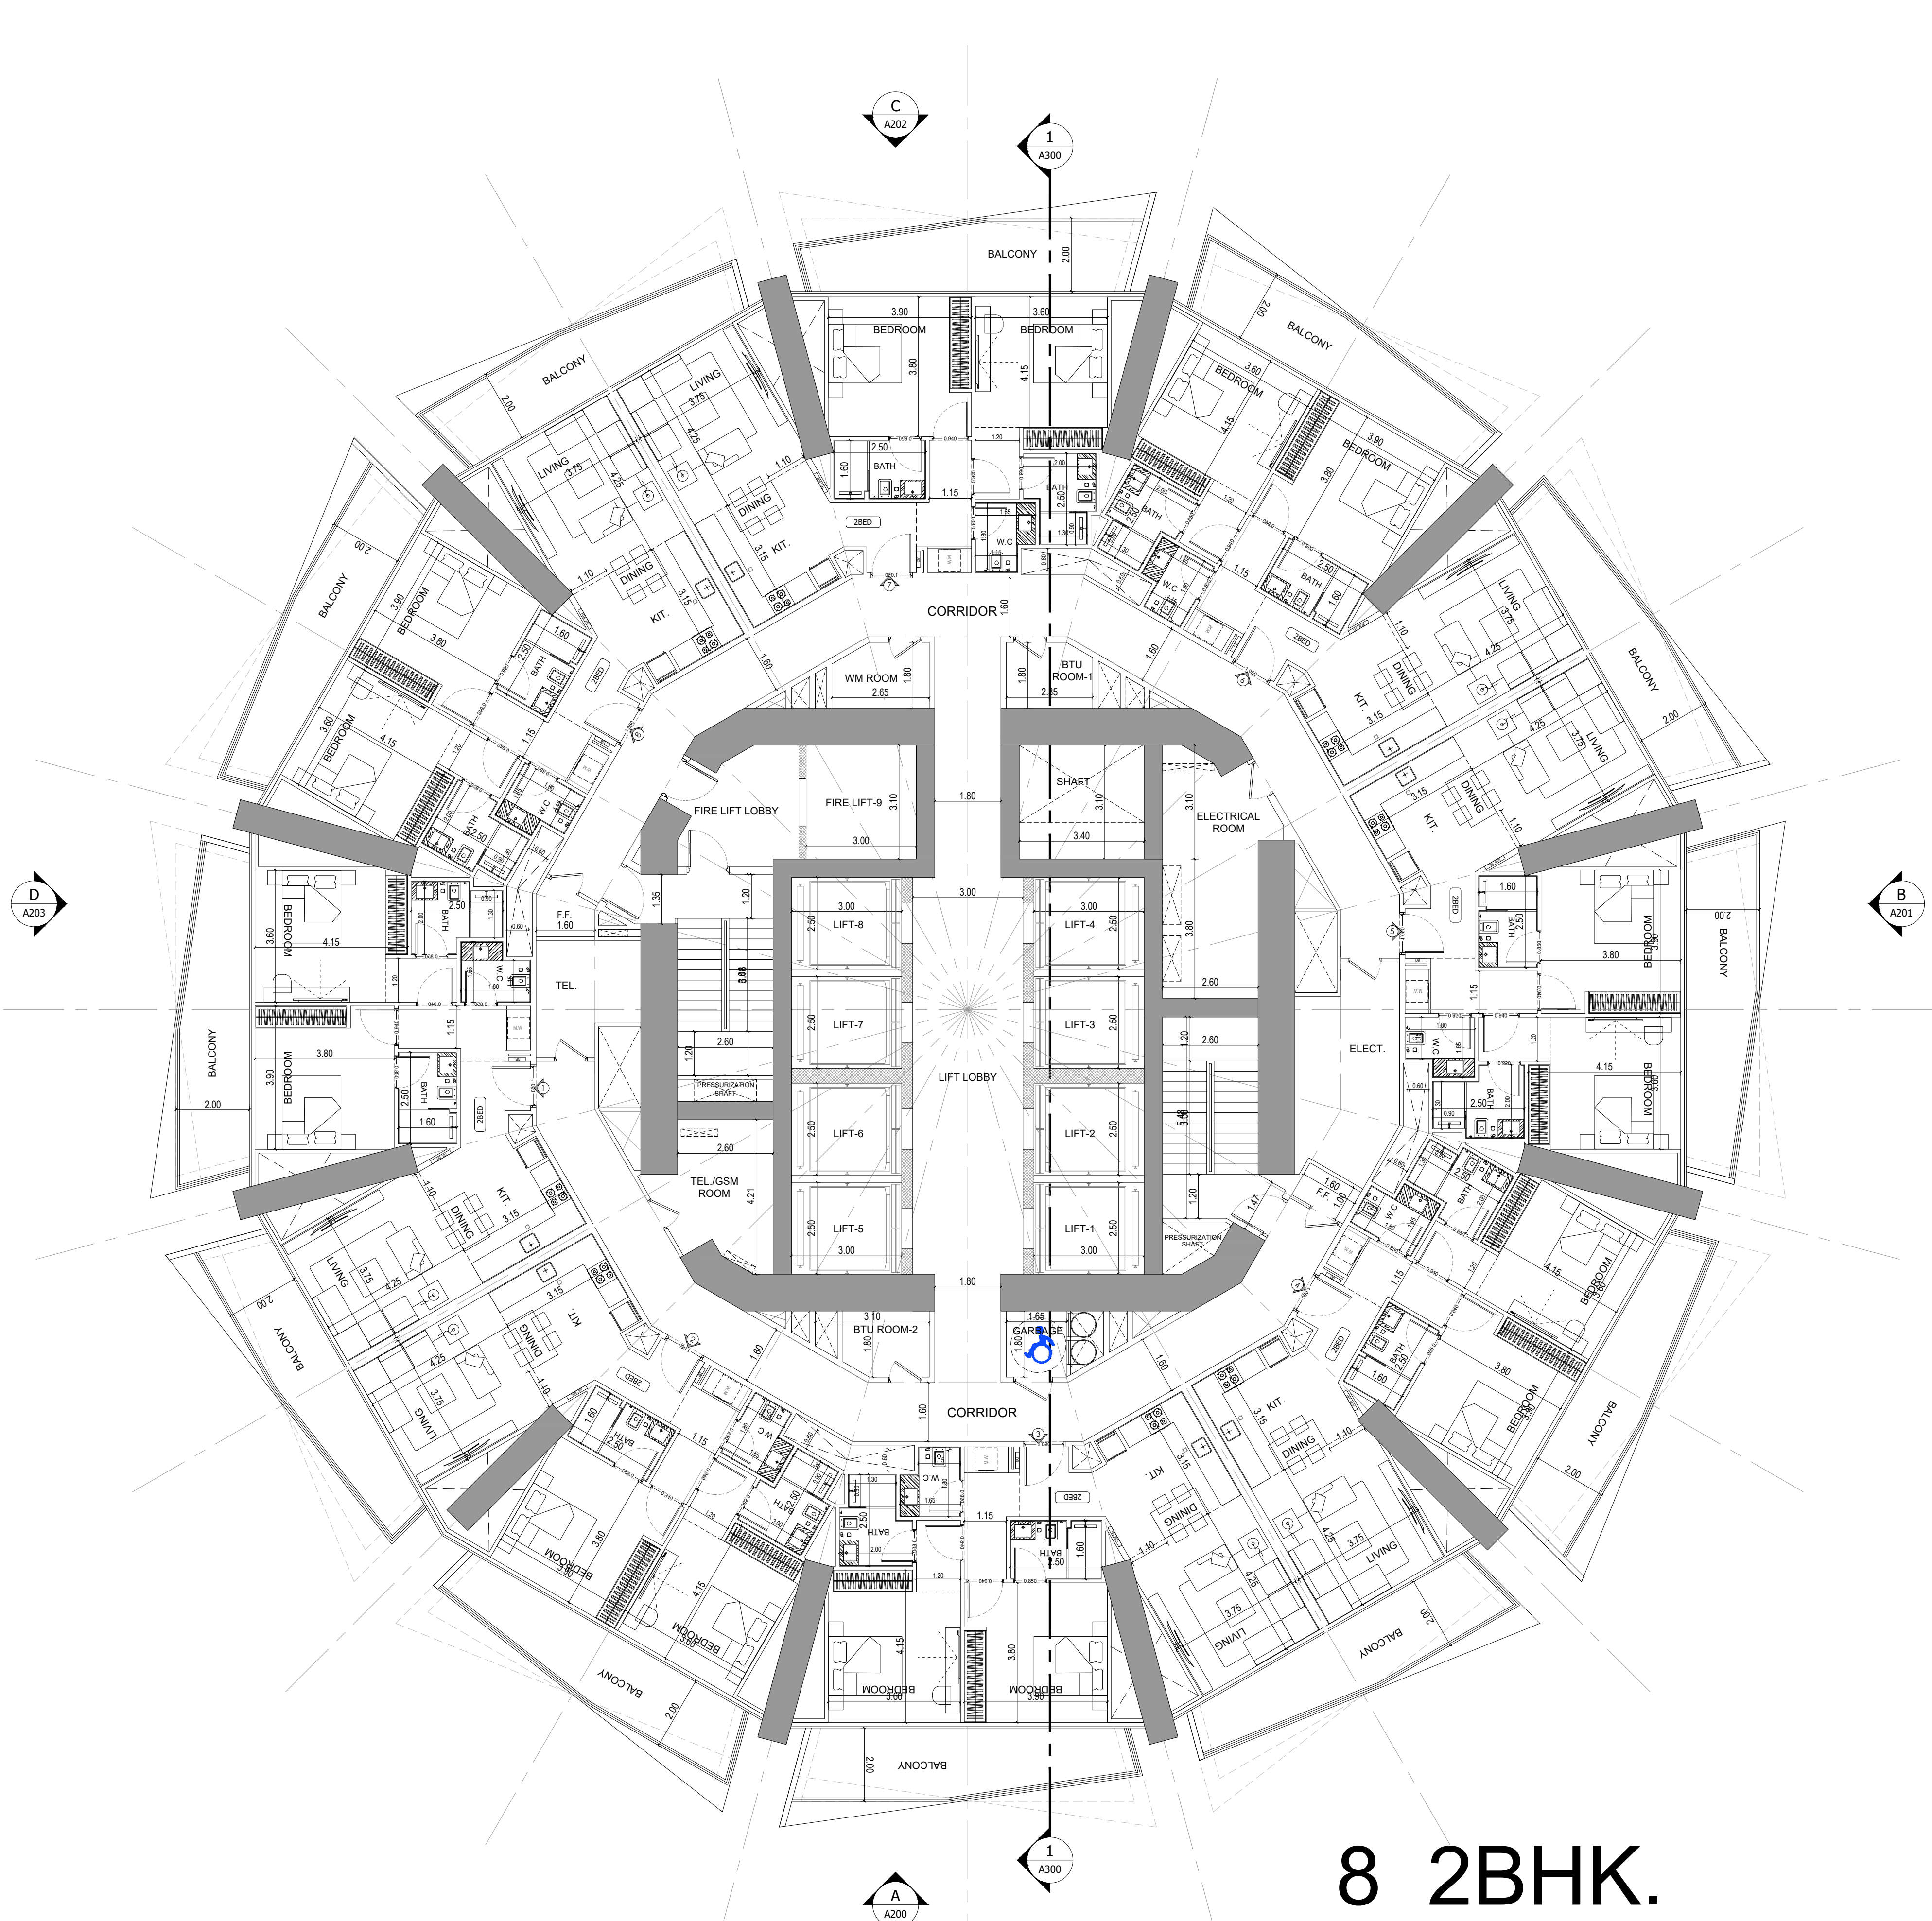

1 63RD FLOOR PLAN
A118 SCALE - 1:100


8 2BHK.

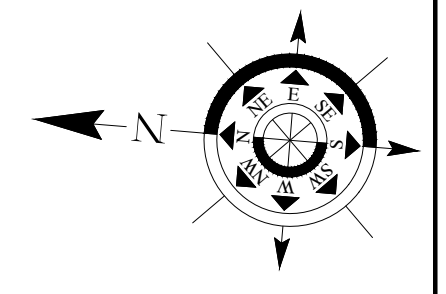

APPROVAL STAMP:

NOTES:

- 1.) ALL DIMENSIONS TO BE VERIFIED BY CONTRACTOR ON SITE PRIOR TO COMMENCEMENT OF ANY WORK.
- 2.) DO NOT SCALE THIS DRAWING FOR THE PURPOSE OF MEASUREMENT. ONLY SCALE DIMENSIONS WHERE SPECIFICALLY INSTRUCTED TO DO SO.
- 3.) ALL MEASUREMENTS ARE IN MILLIMETERS UNLESS OTHERWISE SPECIFIED.
- 4.) DIMENSIONS SHOWN ON THESE DRAWINGS ARE STRUCTURAL DIMENSIONS UNLESS CLEARLY NOTED OTHERWISE.
- 5.) THIS DRAWING IS TO BE READ IN CONJUNCTION WITH ALL OTHER DRAWINGS, DETAIL AND SPECIFICATIONS. ANY DISCREPANCY TO BE IMMEDIATELY BROUGHT TO THE ATTENTION OF ARCHITECT PRIOR TO COMMENCING THE WORKS.


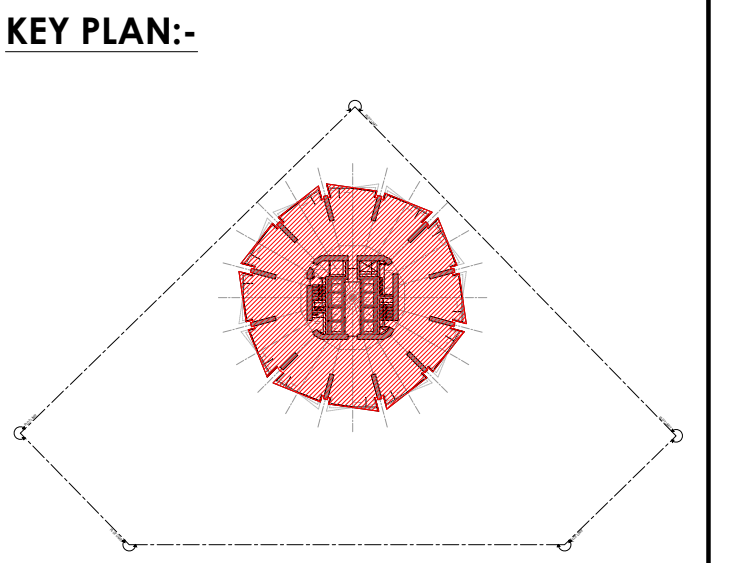


سلفر ستون
للمستشارات الهندسية
SILVER STONE
ENGINEERING CONSULTANTS
P.O. BOX 30996, DUBAI UAE

GATE LEVEL PROPOSED = (±0.00 m.) = +15.45 m. DMD LVL.

GATE LEVEL PROPOSED = (±0.00 m.) = +15.45 m. DML. LEVEL			
REV	DATE	DESCRIPTION	CHECK
STATUS:			
PRELIMINARY SUBMISSION			
OWNER:			
ARGENTI PROPERTIES INVESTMENTS LTD			
CONSULTANT:			
 سلفر ستون للمستشارات الهندسية SILVER STONE ENGINEERING CONSULTANTS			
PROJECT:			
بن غاطي BINGHATTI CIRCLE 2B + G + 4P + S8 TYP. FLOORS +3 MECH.+3 STR.+ ROOF			
PLOT NO.		LOCATION:	
JVC13RHRG001		AL BARSHA SOUTH FOURTH(681)	
ARCH:		STR Engg:	
AMAR M		M FLAHA	
Reg. No:		Reg. No:	
114763		109115	
SCALE:		DRAWN: MUS	
1:100		CHECKED & APPROVED: AM	
DRAWING TITLE:			
63RD FLOOR PLAN			
PROJECT NO:		DWG NO:	REV:
P025-01		A118	00


File Path: X:\Binghatti Project\025-01-Binghatti Circle\01- ARCHITECTURE\01- CONCEPT\01- DWG- Print Date: 12-Jun-25, Time: 10:23:34 AM

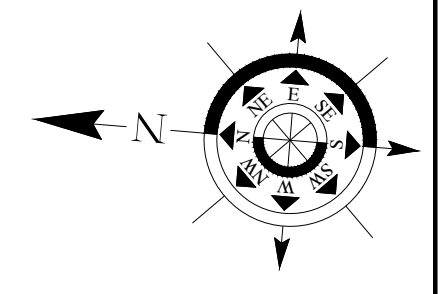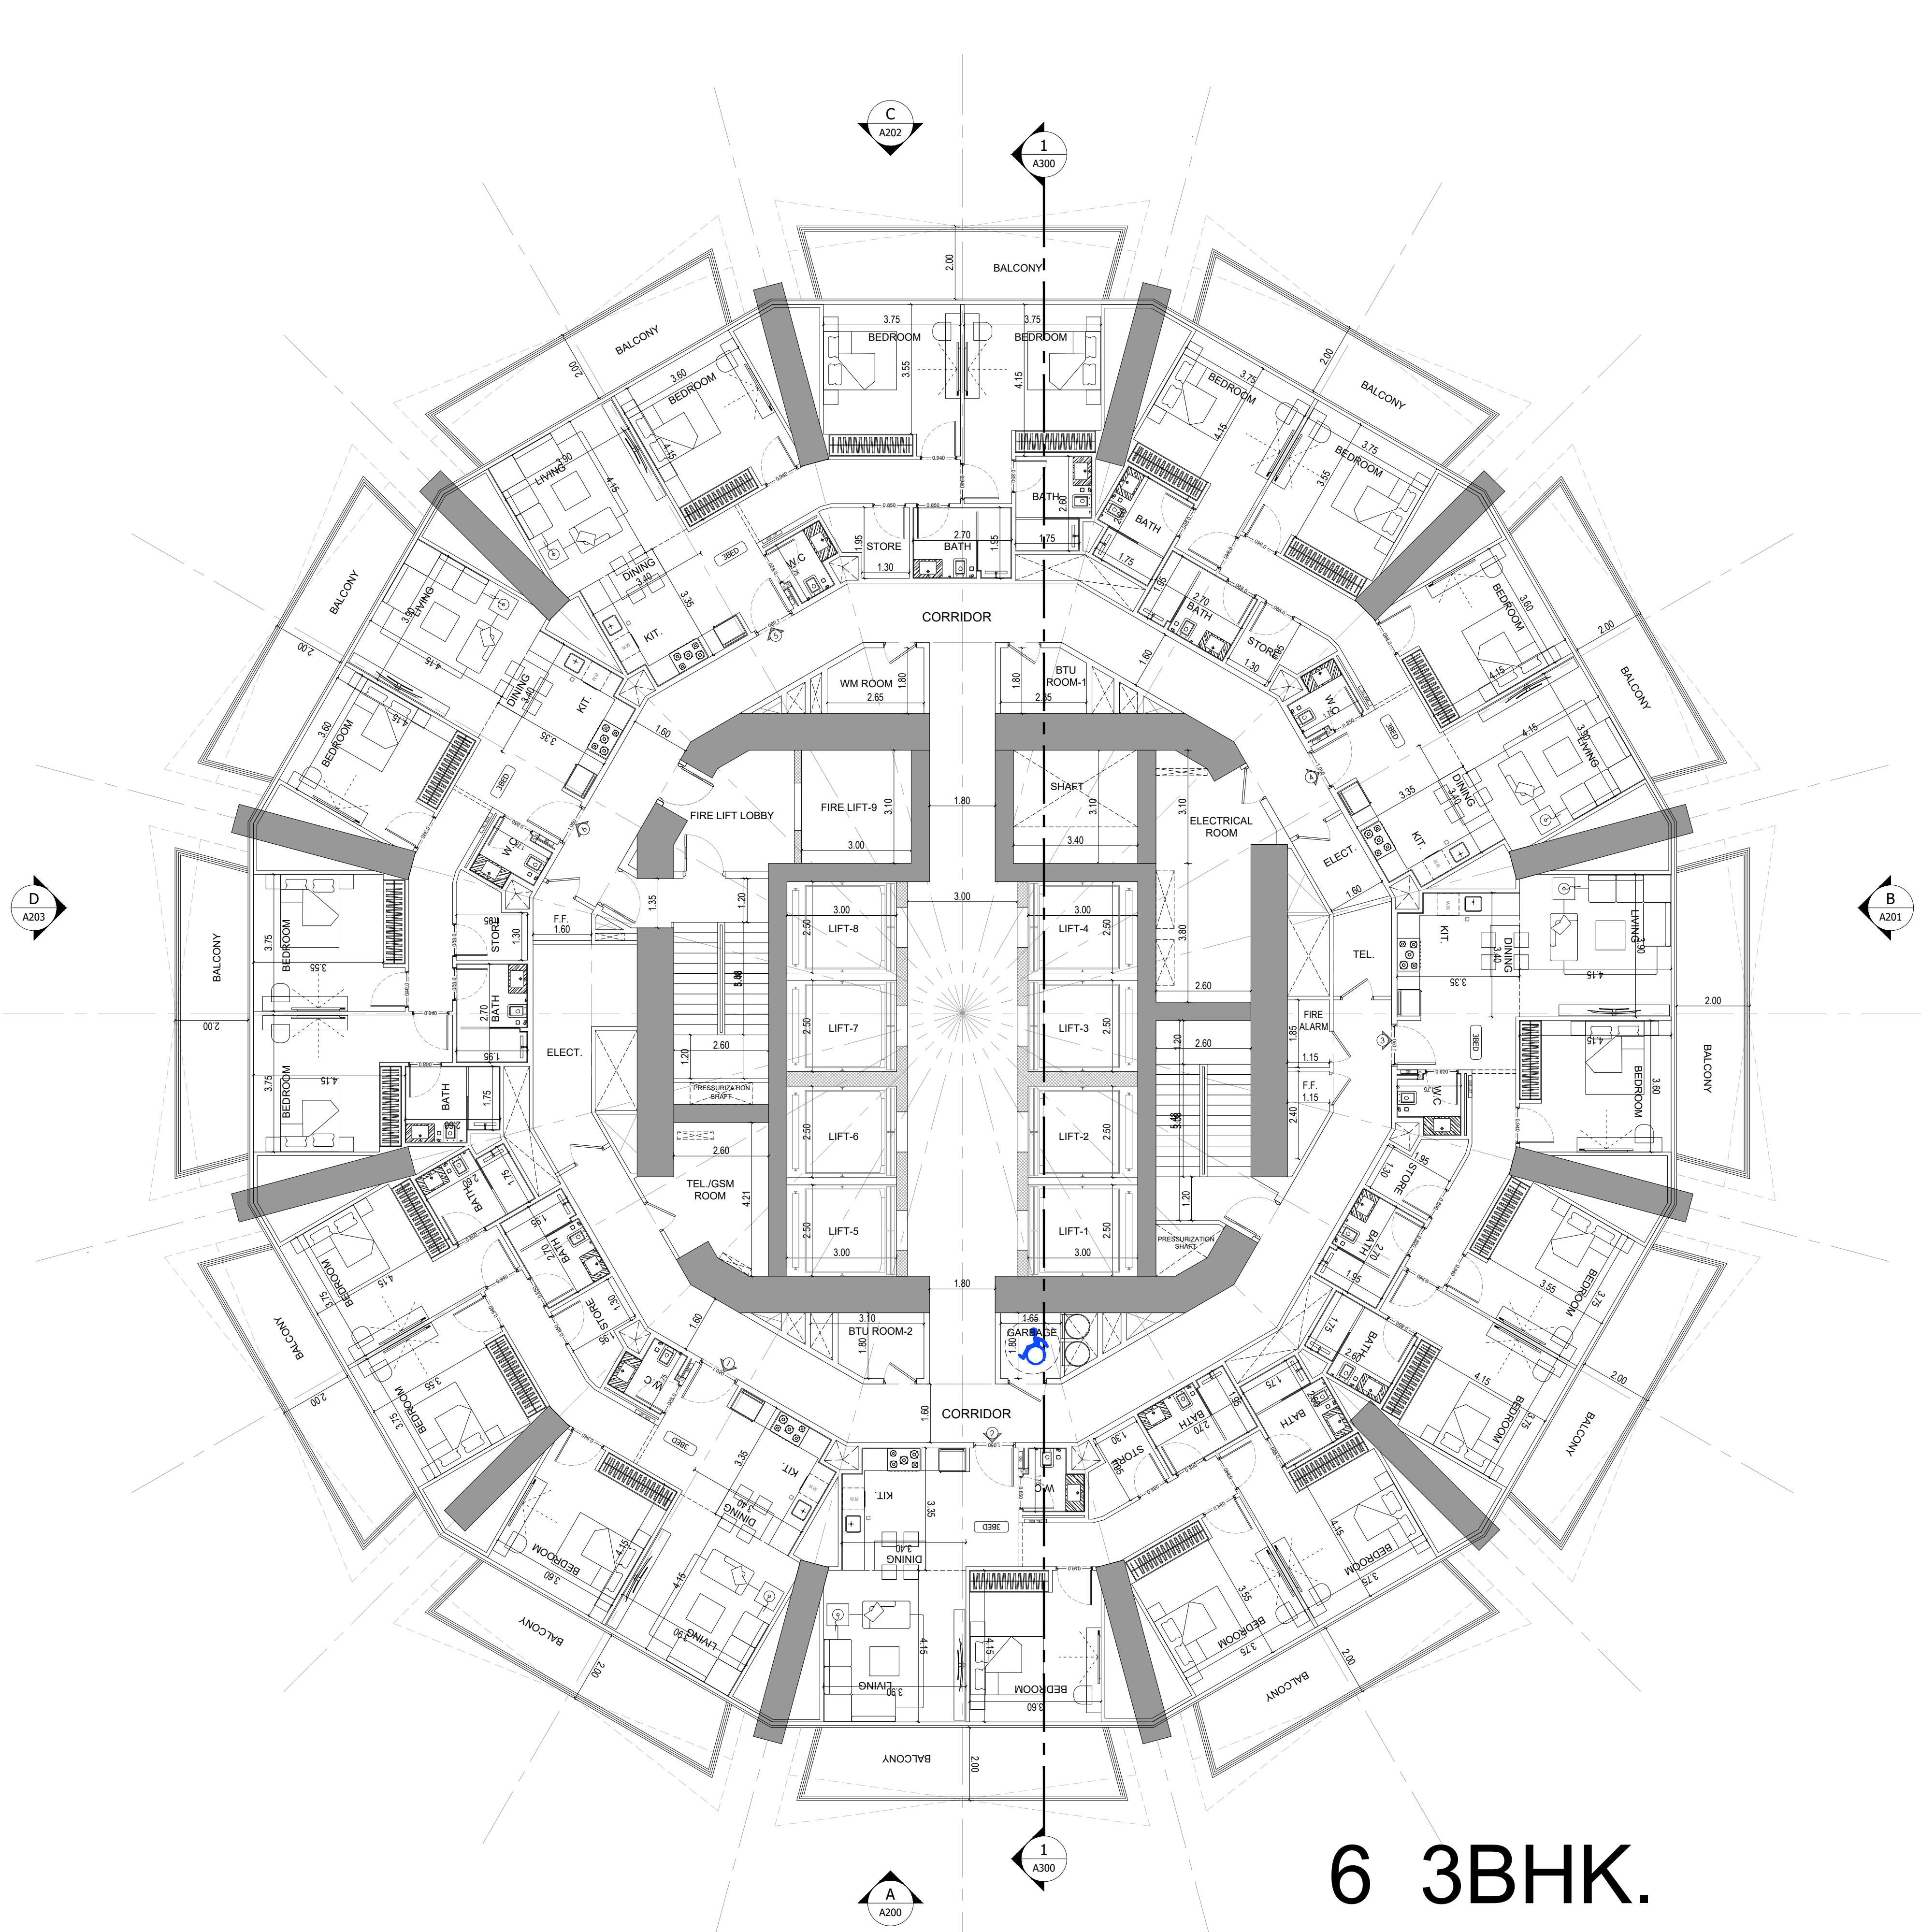

APPROVAL STAMP:

NOTES:

- 1.) ALL DIMENSIONS TO BE VERIFIED BY CONTRACTOR ON SITE PRIOR TO COMMENCEMENT OF ANY WORK.
- 2.) DO NOT SCALE THIS DRAWING FOR THE PURPOSE OF MEASUREMENT. ONLY SCALE DIMENSIONS WHERE SPECIFICALLY INSTRUCTED TO DO SO.
- 3.) ALL MEASUREMENTS ARE IN MILLIMETERS UNLESS OTHERWISE SPECIFIED.
- 4.) DIMENSIONS SHOWN ON THESE DRAWINGS ARE STRUCTURAL DIMENSIONS UNLESS CLEARLY NOTED OTHERWISE.
- 5.) THIS DRAWING IS TO BE READ IN CONJUNCTION WITH ALL OTHER DRAWINGS, DETAIL AND SPECIFICATIONS. ANY DISCREPANCY TO BE IMMEDIATELY BROUGHT TO THE ATTENTION OF ARCHITECT PRIOR TO COMMENCING THE WORKS.

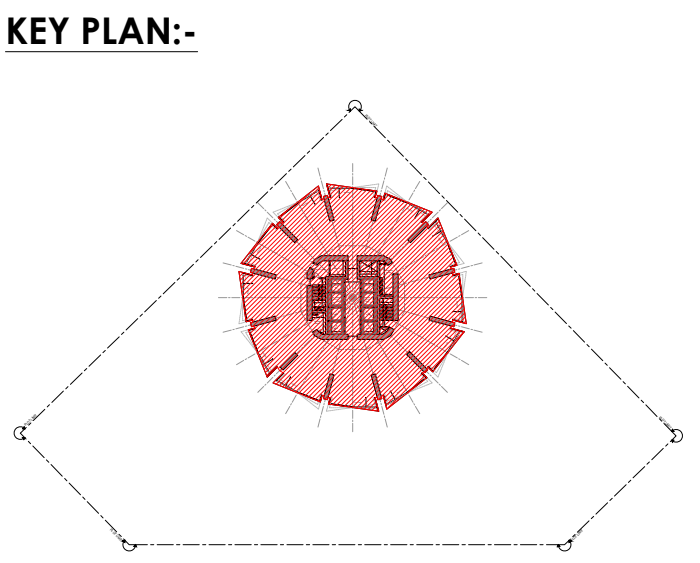

GATE LEVEL PROPOSED = (±0.00 m.) = +15.45 m. DMD LVL.

REV	DATE	DESCRIPTION	CHECK

STATUS : **PRELIMINARY SUBMISSION**

OWNER: **ARGENTI PROPERTIES INVESTMENTS LTD**

CONSULTANT: **SILVER STONE ENGINEERING CONSULTANTS**

PROJECT : **BINGHATTI CIRCLE**

2B + G + 4P + 58 TYP. FLOORS +3 MECH.+3 STR.+ ROOF

PLOT NO:	LOCATION:
JVC13RHRG001	AL BARSHA SOUTH FOURTH(681)
ARCH: AMAR M	STR Engg: M.FLAHA
Reg. No: 114763	Reg. No: 109115
SCALE:	DRAWN: MUS
	CHECKED & APPROVED: AM

1:100



DRAWING TITLE: **64TH FLOOR PLAN**

PROJECT NO:	DWG NO:	REV:
P025-01	A119	00

1 64TH FLOOR PLAN
A119 SCALE - 1:100

6 3BHK.


File Path: X:\Binghatti Project\2025-01-Binghatti Circle\01- ARCHITECTURE\01- CONCEPT\01- DWG- Pmt Date: 12-Jun-25, Time: 10:23:34 AM

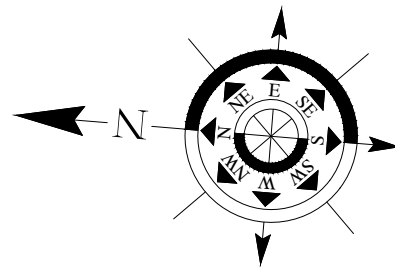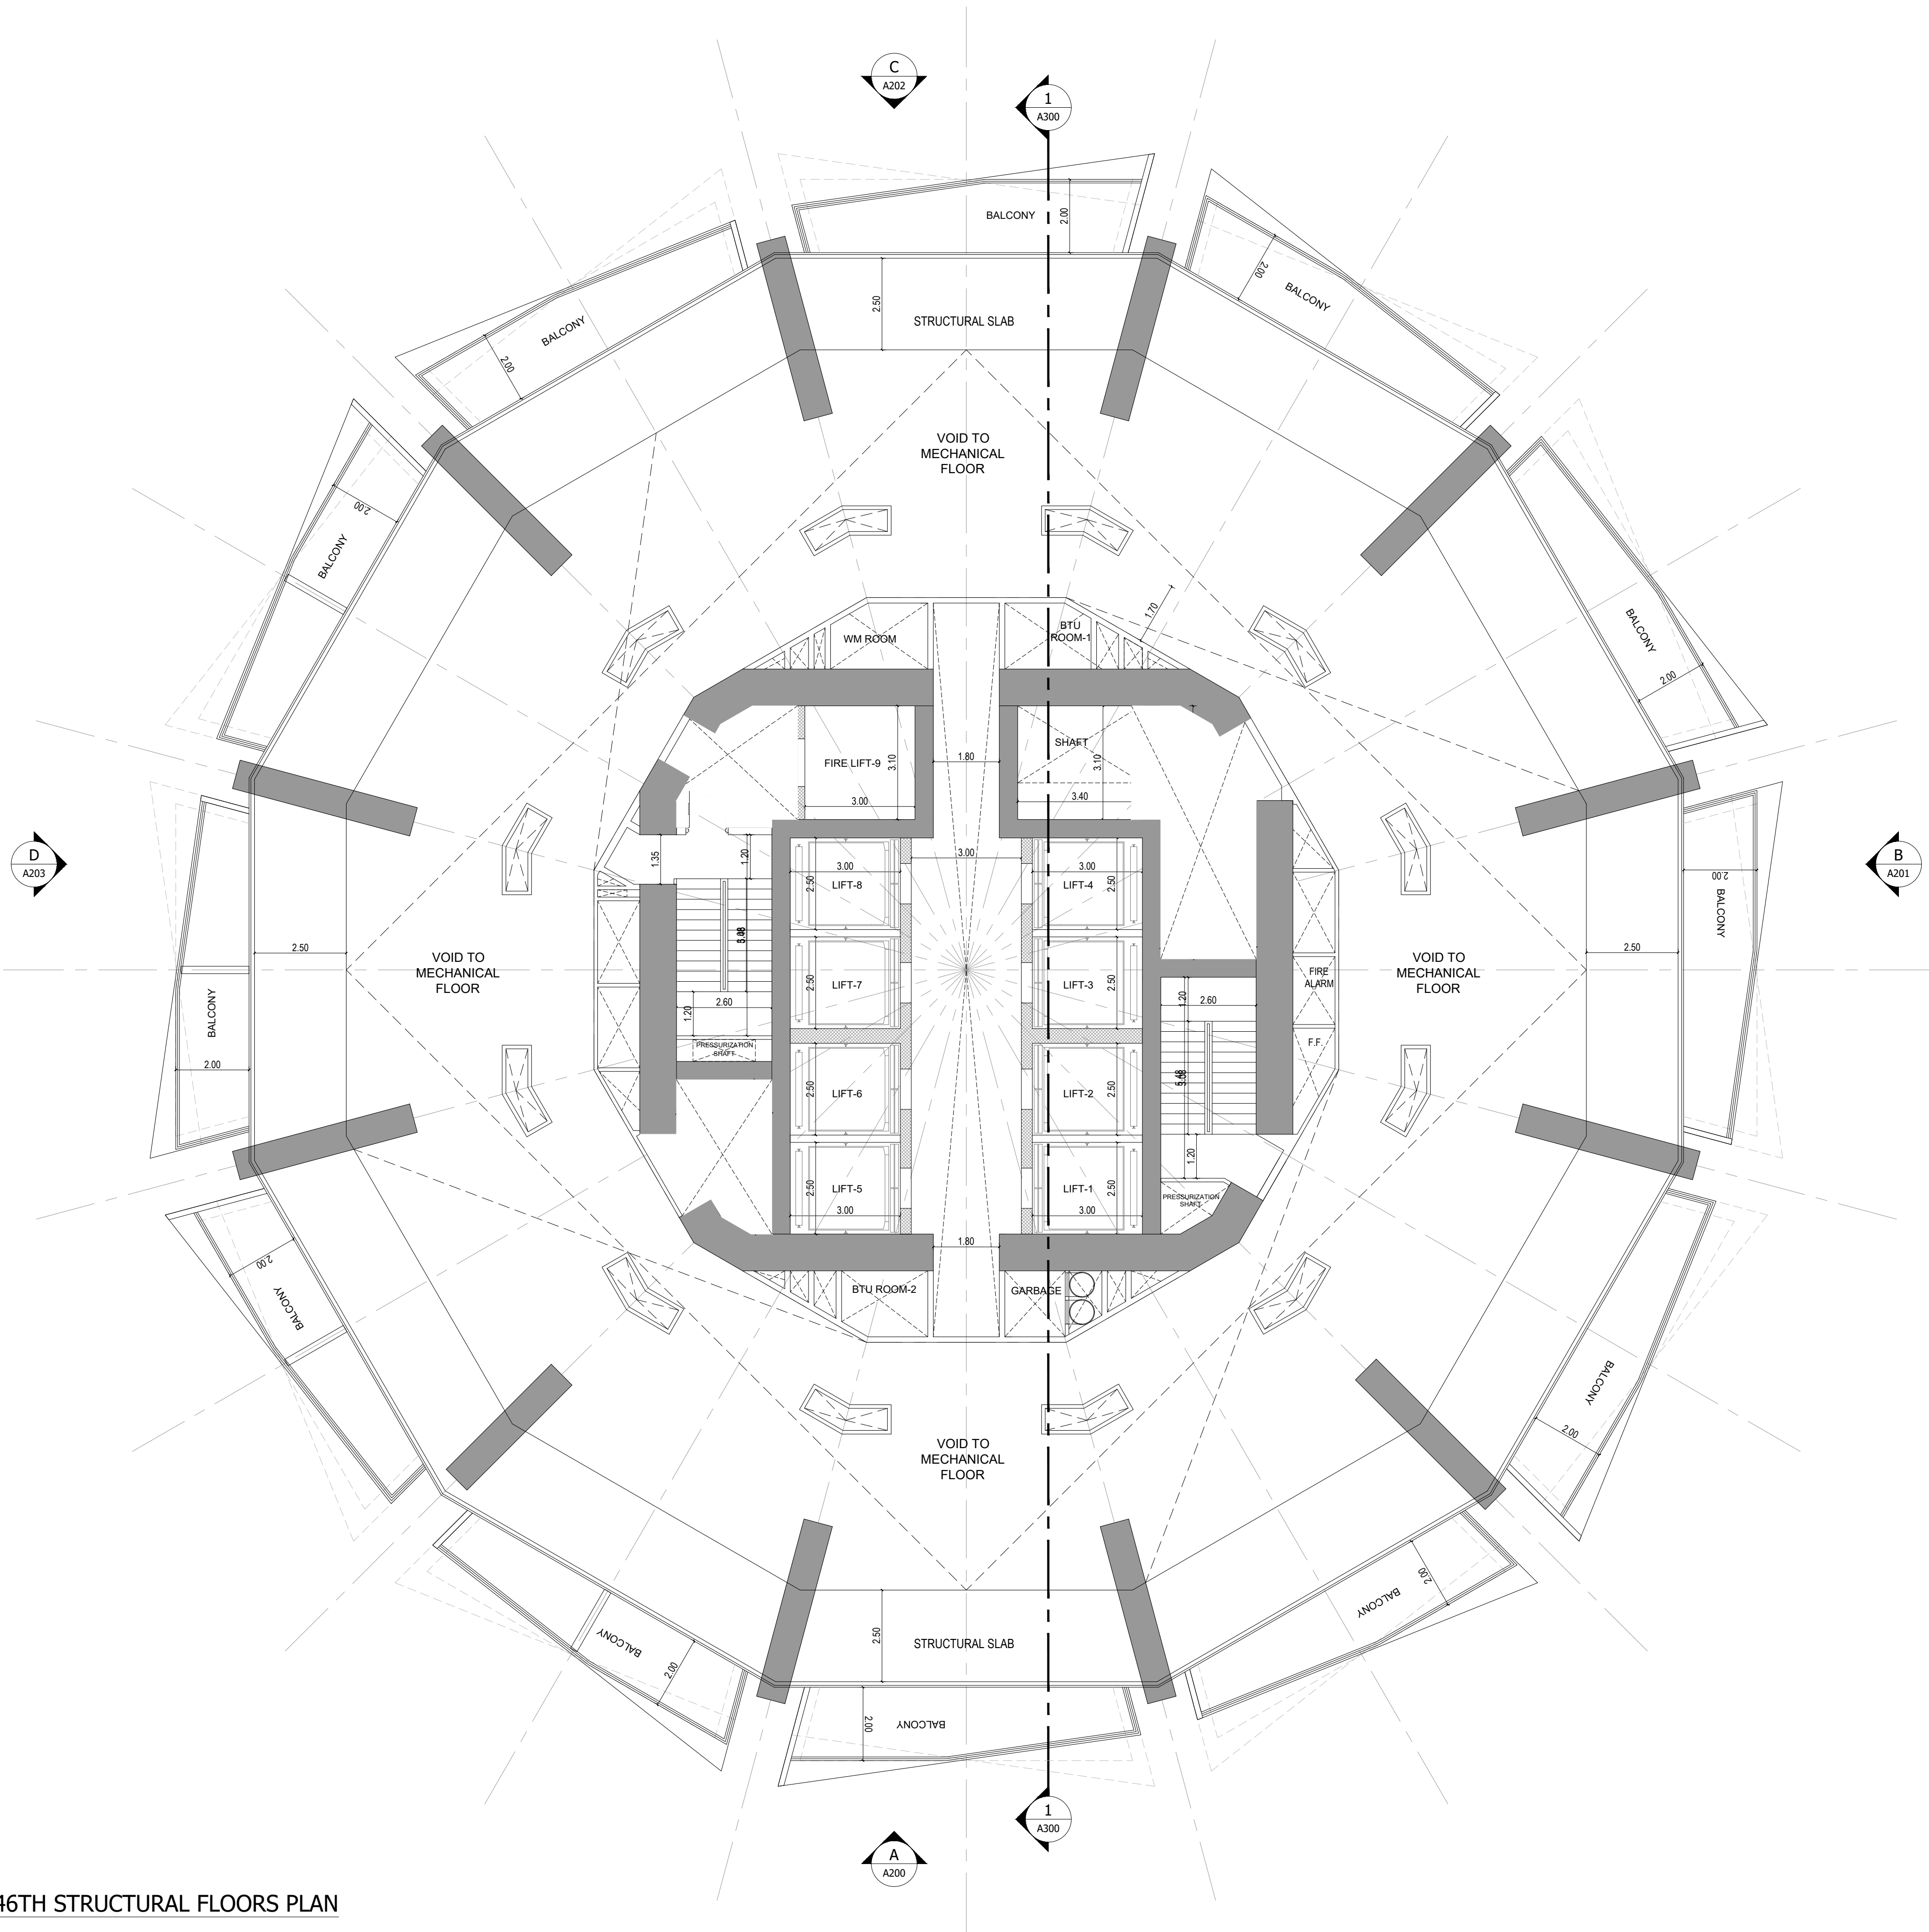

APPROVAL STAMP:

- NOTES:
- 1.) ALL DIMENSIONS TO BE VERIFIED BY CONTRACTOR ON SITE PRIOR TO COMMENCEMENT OF ANY WORK.
 - 2.) DO NOT SCALE THIS DRAWING FOR THE PURPOSE OF MEASUREMENT. ONLY SCALE DIMENSIONS WHERE SPECIFICALLY INSTRUCTED TO DO SO.
 - 3.) ALL MEASUREMENTS ARE IN MILLIMETERS UNLESS OTHERWISE SPECIFIED.
 - 4.) DIMENSIONS SHOWN ON THESE DRAWINGS ARE STRUCTURAL DIMENSIONS UNLESS CLEARLY NOTED OTHERWISE.
 - 5.) THIS DRAWING IS TO BE READ IN CONJUNCTION WITH ALL OTHER DRAWINGS, DETAIL AND SPECIFICATIONS. ANY DISCREPANCY TO BE IMMEDIATELY BROUGHT TO THE ATTENTION OF ARCHITECT PRIOR TO COMMENCING THE WORKS.

KEY PLAN:-

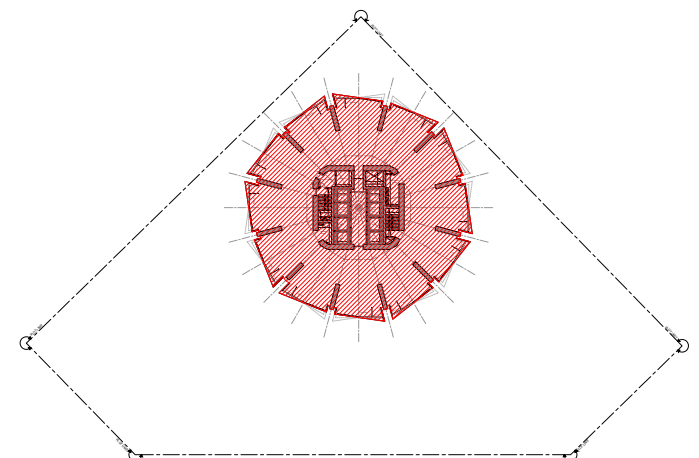

GATE LEVEL PROPOSED = (±0.00 m.) = +15.45 m. DMD LVL.

REV	DATE	DESCRIPTION	CHECK

STATUS :

PRELIMINARY SUBMISSION

OWNER:

ARGENTI PROPERTIES
INVESTMENTS LTD

CONSULTANT:



PROJECT :



BINGHATTI CIRCLE

2B + G + 4P + 58 TYP. FLOORS +3 MECH.+3 STR.+ ROOF

PLOT NO.	LOCATION:
JVC13RHRG001	AL BARSHA SOUTH FOURTH(681)
ARCH: AMAR M	STR Engg: M FLAHA
Reg. No: 114763	Reg. No: 109115
SCALE:	DRAWN: MUS
	CHECKED & APPROVED: AM

1:100

DRAWING TITLE:

9TH,27TH&46TH STRUCTURAL FLOORS PLAN



PROJECT NO:	DWG NO:	REV:
P025-01	A120	00

1

A120

9TH,27TH&46TH STRUCTURAL FLOORS PLAN


SCALE - 1:100

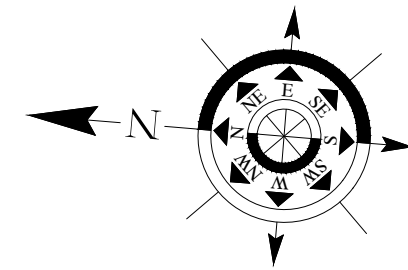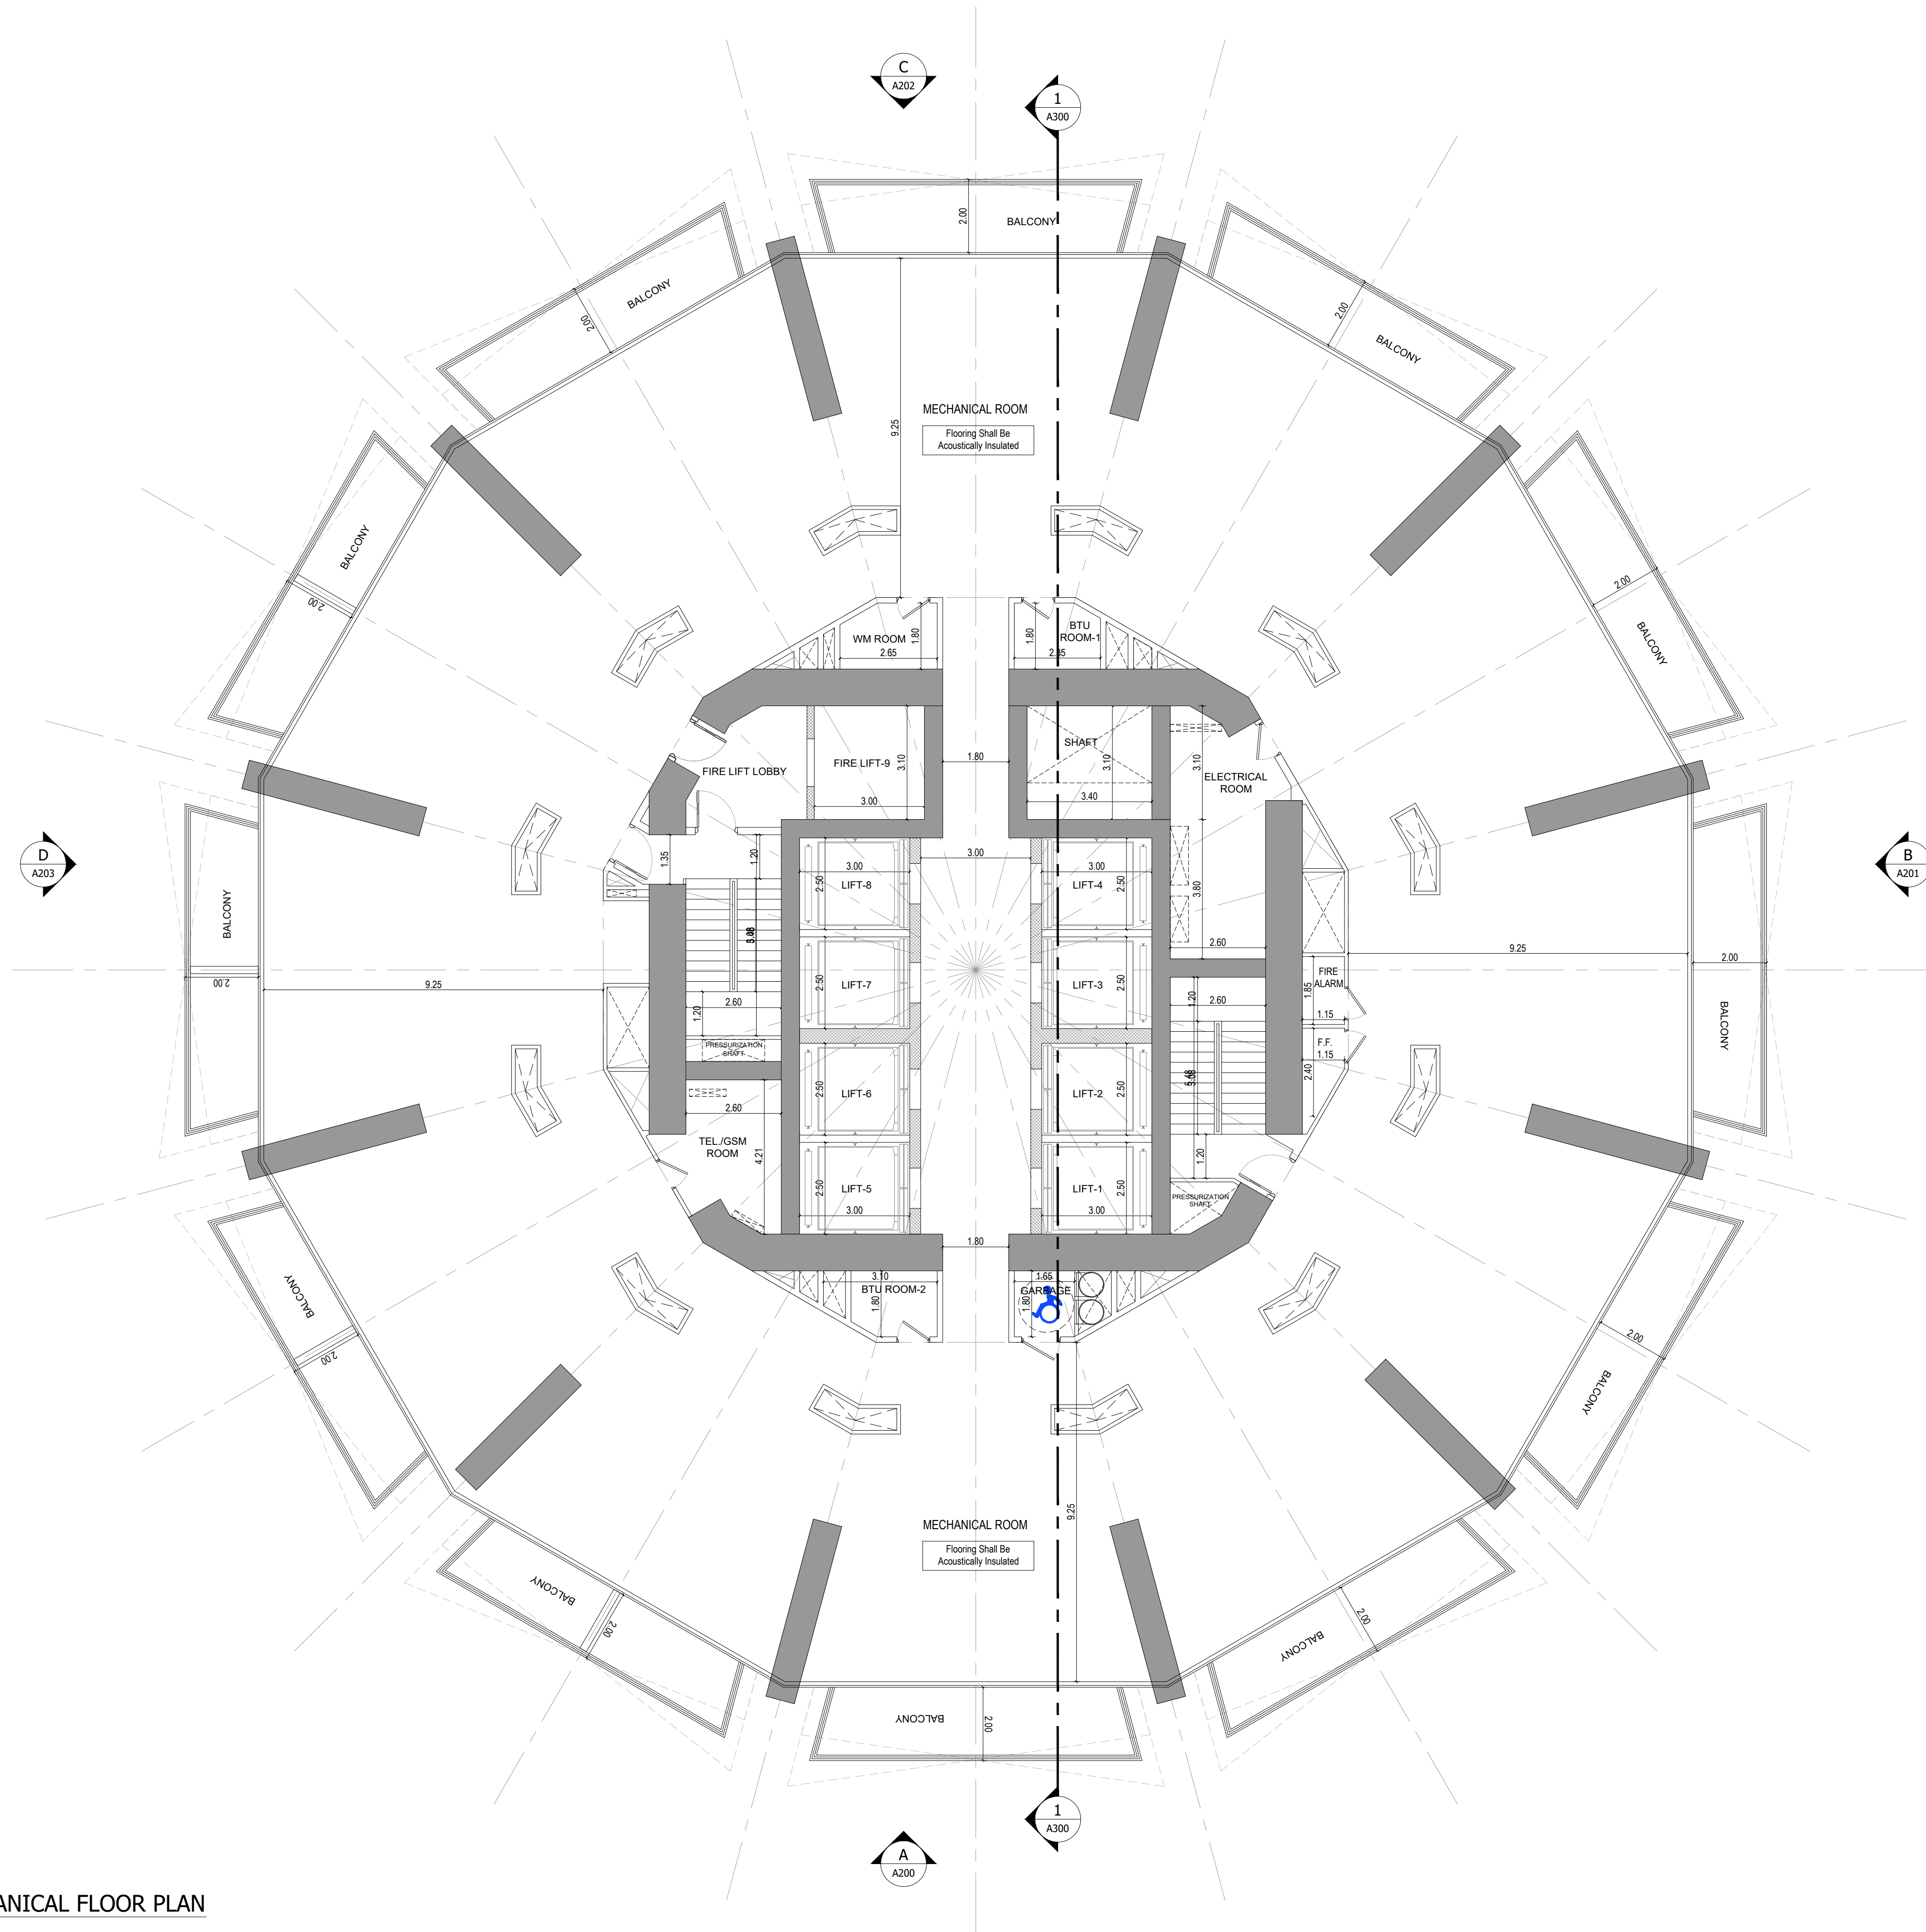

APPROVAL STAMP:

- NOTES:
- 1.) ALL DIMENSIONS TO BE VERIFIED BY CONTRACTOR ON SITE PRIOR TO COMMENCEMENT OF ANY WORK.
 - 2.) DO NOT SCALE THIS DRAWING FOR THE PURPOSE OF MEASUREMENT. ONLY SCALE DIMENSIONS WHERE SPECIFICALLY INSTRUCTED TO DO SO.
 - 3.) ALL MEASUREMENTS ARE IN MILLIMETERS UNLESS OTHERWISE SPECIFIED.
 - 4.) DIMENSIONS SHOWN ON THESE DRAWINGS ARE STRUCTURAL DIMENSIONS UNLESS CLEARLY NOTED OTHERWISE.
 - 5.) THIS DRAWING IS TO BE READ IN CONJUNCTION WITH ALL OTHER DRAWINGS, DETAIL AND SPECIFICATIONS. ANY DISCREPANCY TO BE IMMEDIATELY BROUGHT TO THE ATTENTION OF ARCHITECT PRIOR TO COMMENCING THE WORKS.

KEY PLAN:-

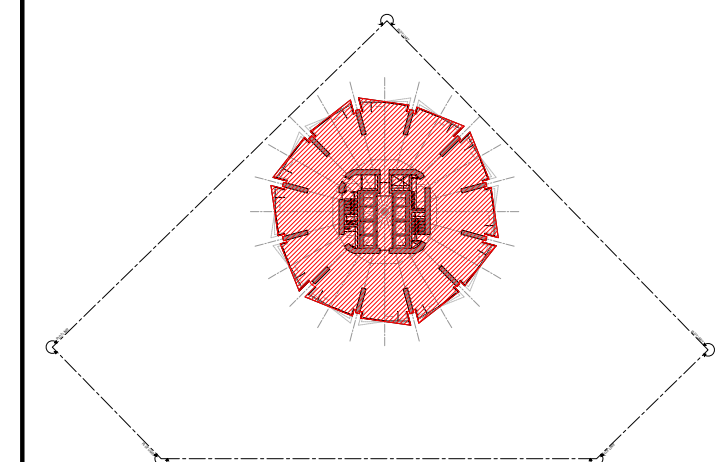

GATE LEVEL PROPOSED = (±0.00 m.) = +15.45 m. DMD LVL.

REV DATE DESCRIPTION CHECK

STATUS:

PRELIMINARY SUBMISSION

OWNER:

ARGENTI PROPERTIES INVESTMENTS LTD

CONSULTANT:



PROJECT :

BINGHATTI CIRCLE

2B + G + 4P + 58 TYP. FLOORS +3 MECH.+3 STR.+ ROOF

PLOT NO: JVC13RHRG001 LOCATION: AL BARSHA SOUTH FOURTH(681)

ARCH: AMAR M STR Engg: M FLAHA

Reg. No: 114763 Reg. No: 109115

SCALE: DRAWN: MUS CHECKED & APPROVED: AM

1:100



DRAWING TITLE:

8TH MECHANICAL FLOOR PLAN

PROJECT NO: DWG NO: REV:

P025-01 A121 00


1 8TH MECHANICAL FLOOR PLAN
A121 SCALE - 1:100

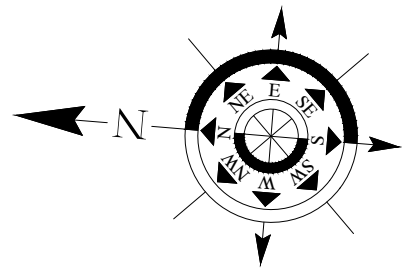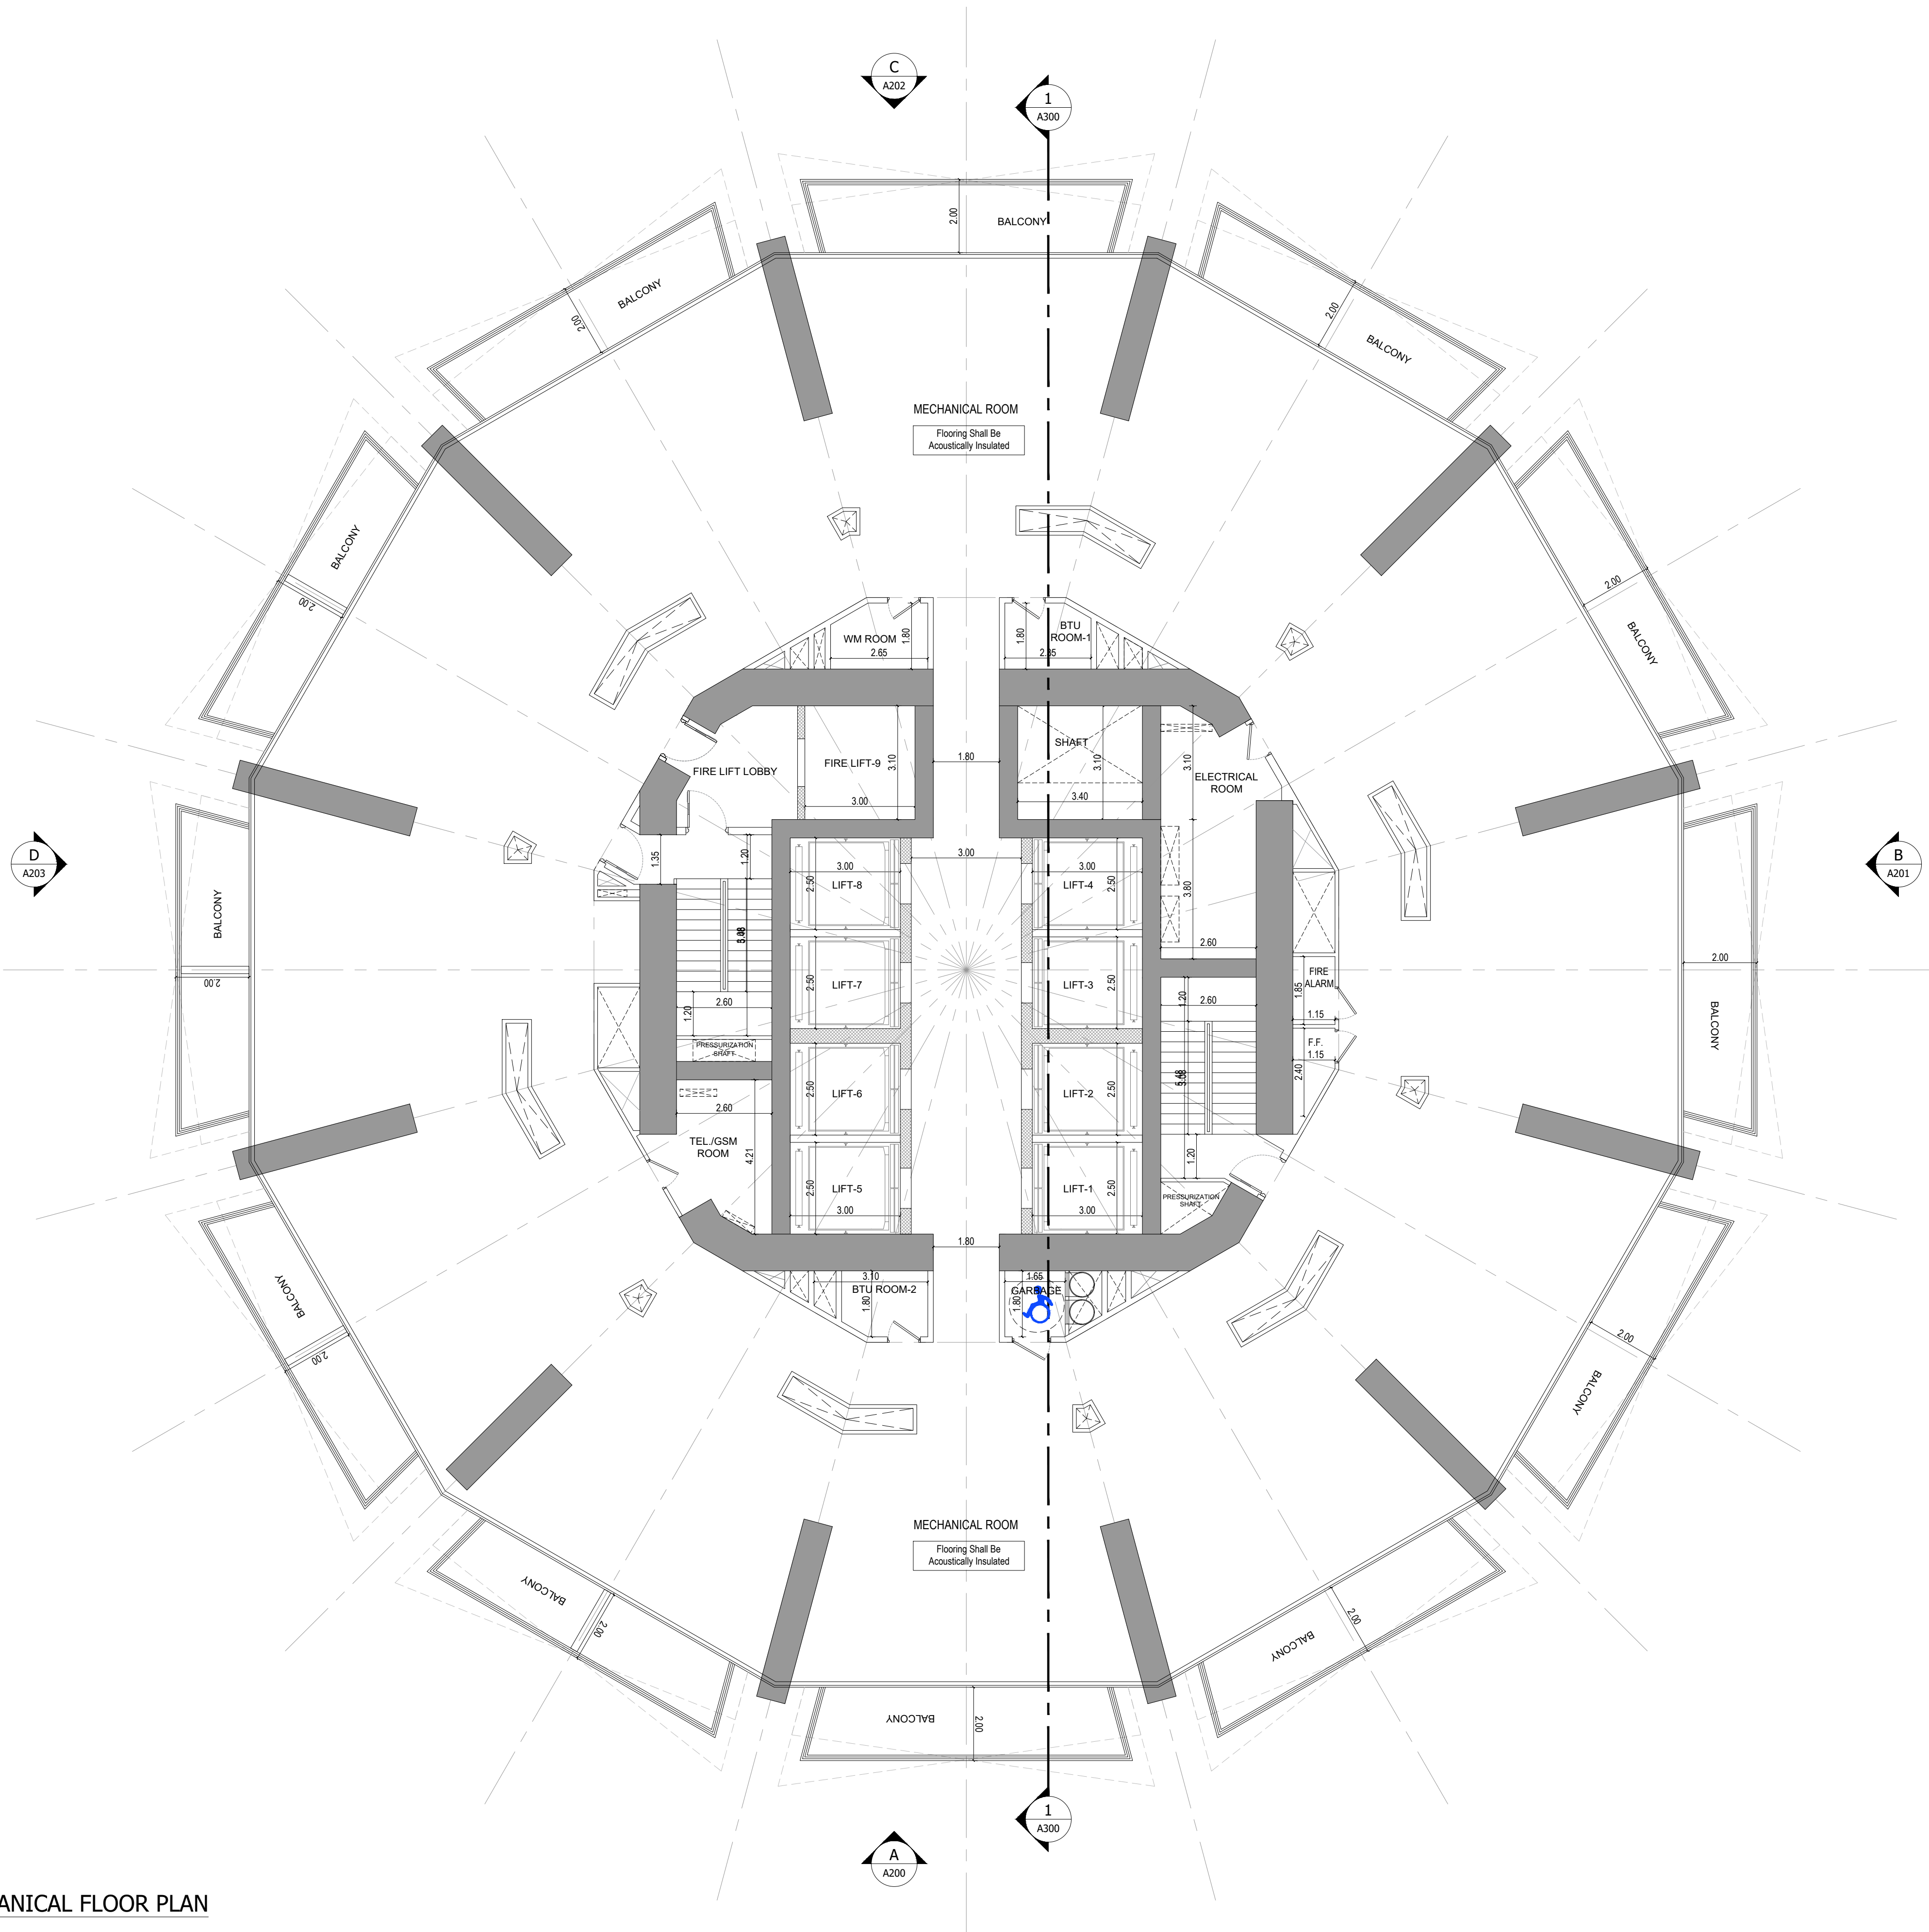

APPROVAL STAMP:

- NOTES:
- 1.) ALL DIMENSIONS TO BE VERIFIED BY CONTRACTOR ON SITE PRIOR TO COMMENCEMENT OF ANY WORK.
 - 2.) DO NOT SCALE THIS DRAWING FOR THE PURPOSE OF MEASUREMENT. ONLY SCALE DIMENSIONS WHERE SPECIFICALLY INSTRUCTED TO DO SO.
 - 3.) ALL MEASUREMENTS ARE IN MILLIMETERS UNLESS OTHERWISE SPECIFIED.
 - 4.) DIMENSIONS SHOWN ON THESE DRAWINGS ARE STRUCTURAL DIMENSIONS UNLESS CLEARLY NOTED OTHERWISE.
 - 5.) THIS DRAWING IS TO BE READ IN CONJUNCTION WITH ALL OTHER DRAWINGS, DETAIL AND SPECIFICATIONS. ANY DISCREPANCY TO BE IMMEDIATELY BROUGHT TO THE ATTENTION OF ARCHITECT PRIOR TO COMMENCING THE WORKS.

KEY PLAN:-

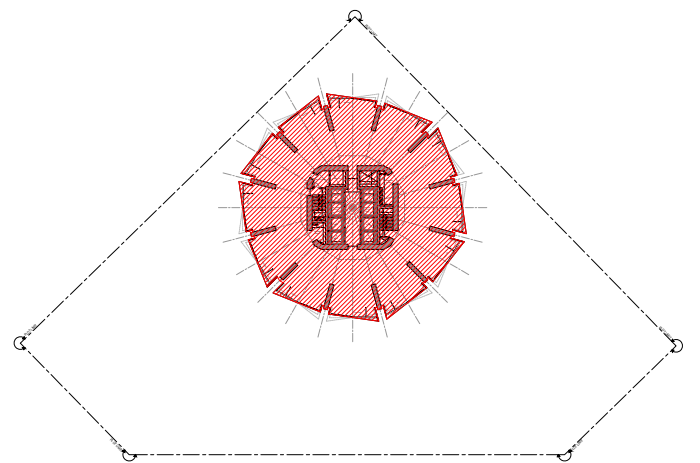

GATE LEVEL PROPOSED = (±0.00 m.) = +15.45 m. DMD LVL.

REV	DATE	DESCRIPTION	CHECK

STATUS:

PRELIMINARY SUBMISSION

OWNER:

ARGENTI PROPERTIES
INVESTMENTS LTD

CONSULTANT:



PROJECT:



BINGHATTI CIRCLE

2B + G + 4P + 5B TYP. FLOORS +3 MECH.+3 STR.+ ROOF

PLOT NO.	LOCATION:
JVC13RHRG001	AL BARSHA SOUTH FOURTH(681)
ARCH: AMAR M	STR Engg: M FLAHA
Reg. No: 114763	Reg. No: 109115
SCALE:	DRAWN: MUS
	CHECKED & APPROVED: AM



1:100

DRAWING TITLE:

26TH MECHANICAL FLOOR PLAN

PROJECT NO:	DWG NO:	REV:
P025-01	A122	00


1 26TH MECHANICAL FLOOR PLAN
A122 SCALE - 1:100

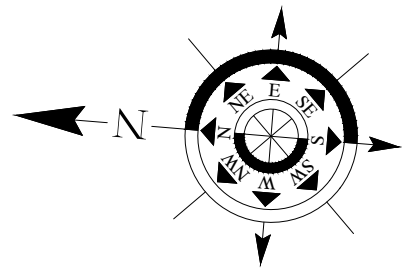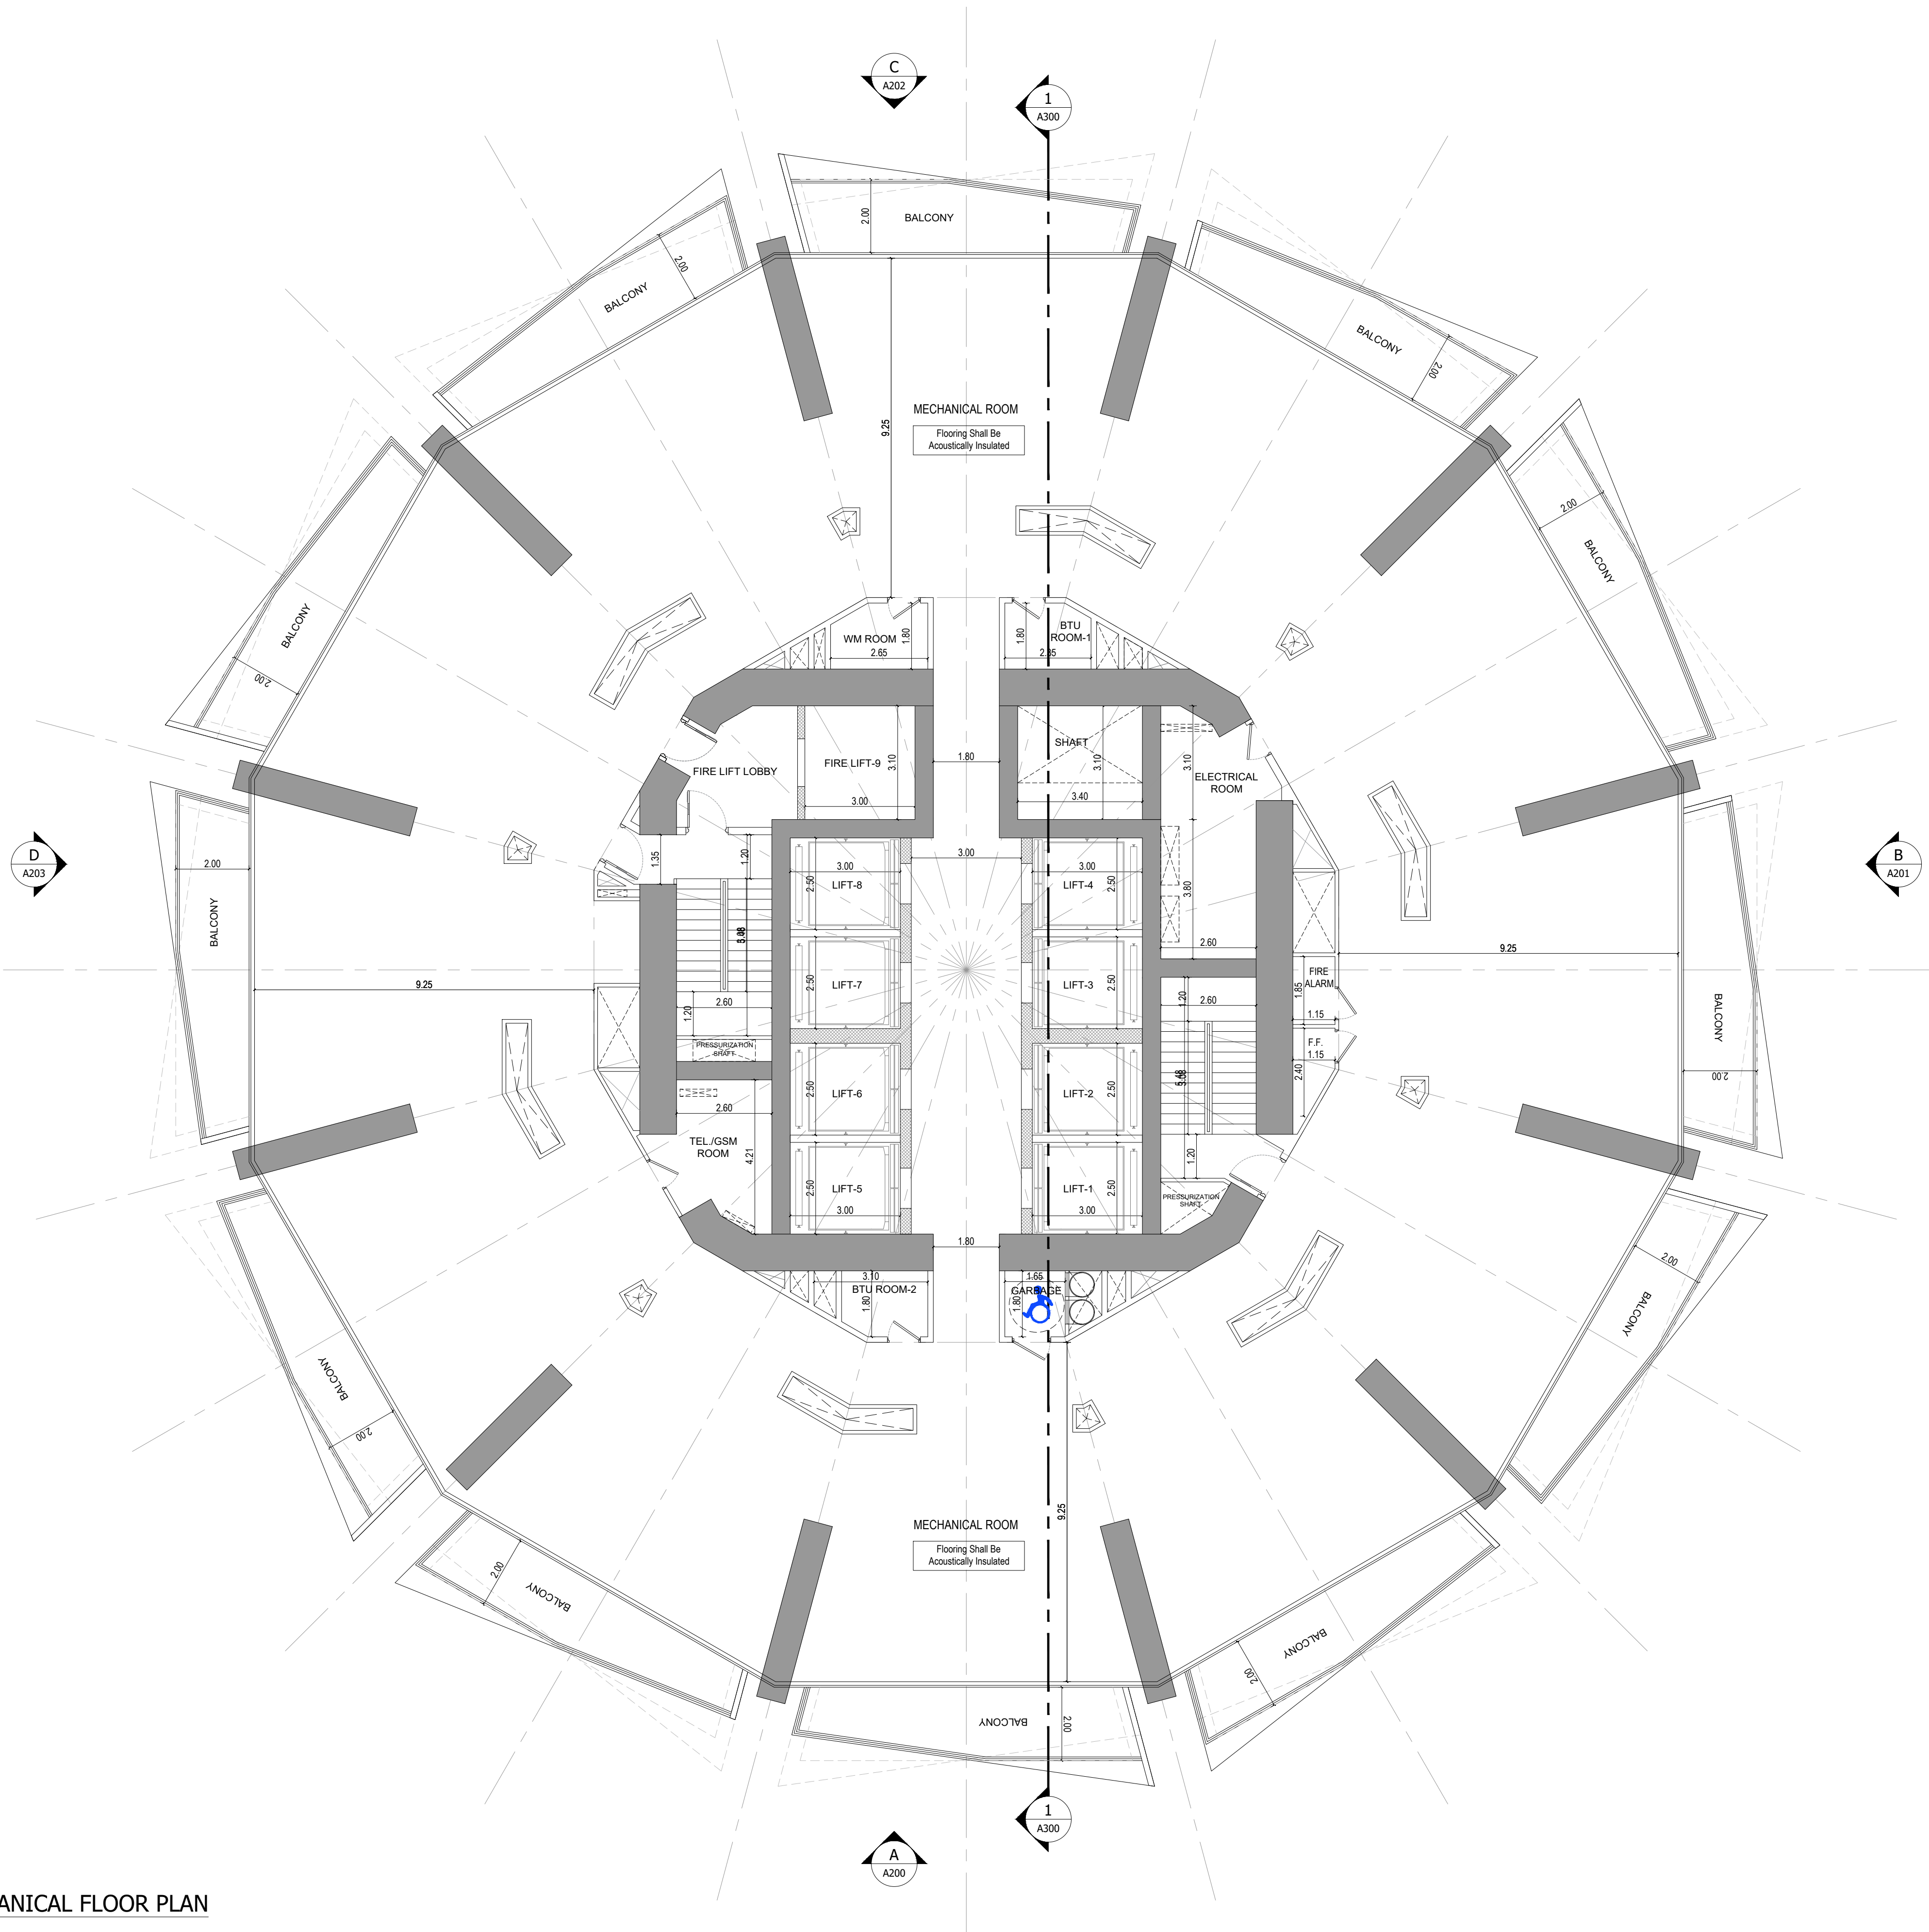

APPROVAL STAMP:

- NOTES:
- 1.) ALL DIMENSIONS TO BE VERIFIED BY CONTRACTOR ON SITE PRIOR TO COMMENCEMENT OF ANY WORK.
 - 2.) DO NOT SCALE THIS DRAWING FOR THE PURPOSE OF MEASUREMENT. ONLY SCALE DIMENSIONS WHERE SPECIFICALLY INSTRUCTED TO DO SO.
 - 3.) ALL MEASUREMENTS ARE IN MILLIMETERS UNLESS OTHERWISE SPECIFIED.
 - 4.) DIMENSIONS SHOWN ON THESE DRAWINGS ARE STRUCTURAL DIMENSIONS UNLESS CLEARLY NOTED OTHERWISE.
 - 5.) THIS DRAWING IS TO BE READ IN CONJUNCTION WITH ALL OTHER DRAWINGS, DETAIL AND SPECIFICATIONS. ANY DISCREPANCY TO BE IMMEDIATELY BROUGHT TO THE ATTENTION OF ARCHITECT PRIOR TO COMMENCING THE WORKS.

KEY PLAN:-

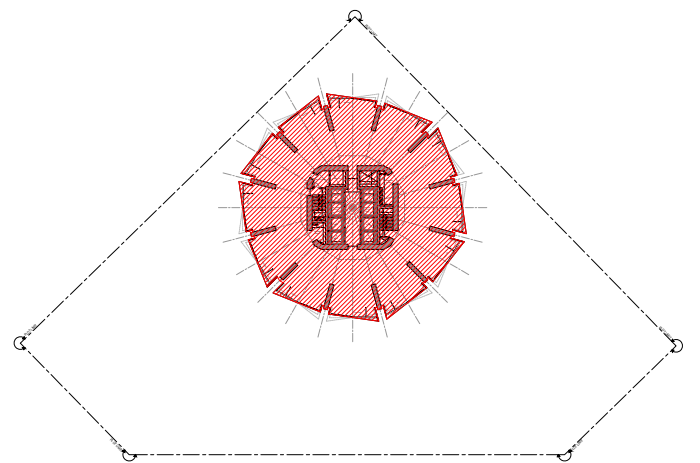

GATE LEVEL PROPOSED = (±0.00 m.) = +15.45 m. DMD LVL.

REV DATE DESCRIPTION CHECK

STATUS:

PRELIMINARY SUBMISSION

OWNER:

ARGENTI PROPERTIES INVESTMENTS LTD

CONSULTANT:



PROJECT:



BINGHATTI CIRCLE

2B + G + 4P + 58 TYP. FLOORS +3 MECH.+3 STR.+ ROOF

PLOT NO: JVC13RHRG001 LOCATION: AL BARSHA SOUTH FOURTH(681)

ARCH: AMAR M STR Engg: M FLAHA

Reg. No: 114763 Reg. No: 109115


SCALE: 1:100 DRAWN: MUS CHECKED & APPROVED: AM

DRAWING TITLE:

45TH MECHANICAL FLOOR PLAN

PROJECT NO: P025-01 DWG NO: A123 REV: 00


1 45TH MECHANICAL FLOOR PLAN
A123 SCALE - 1:100

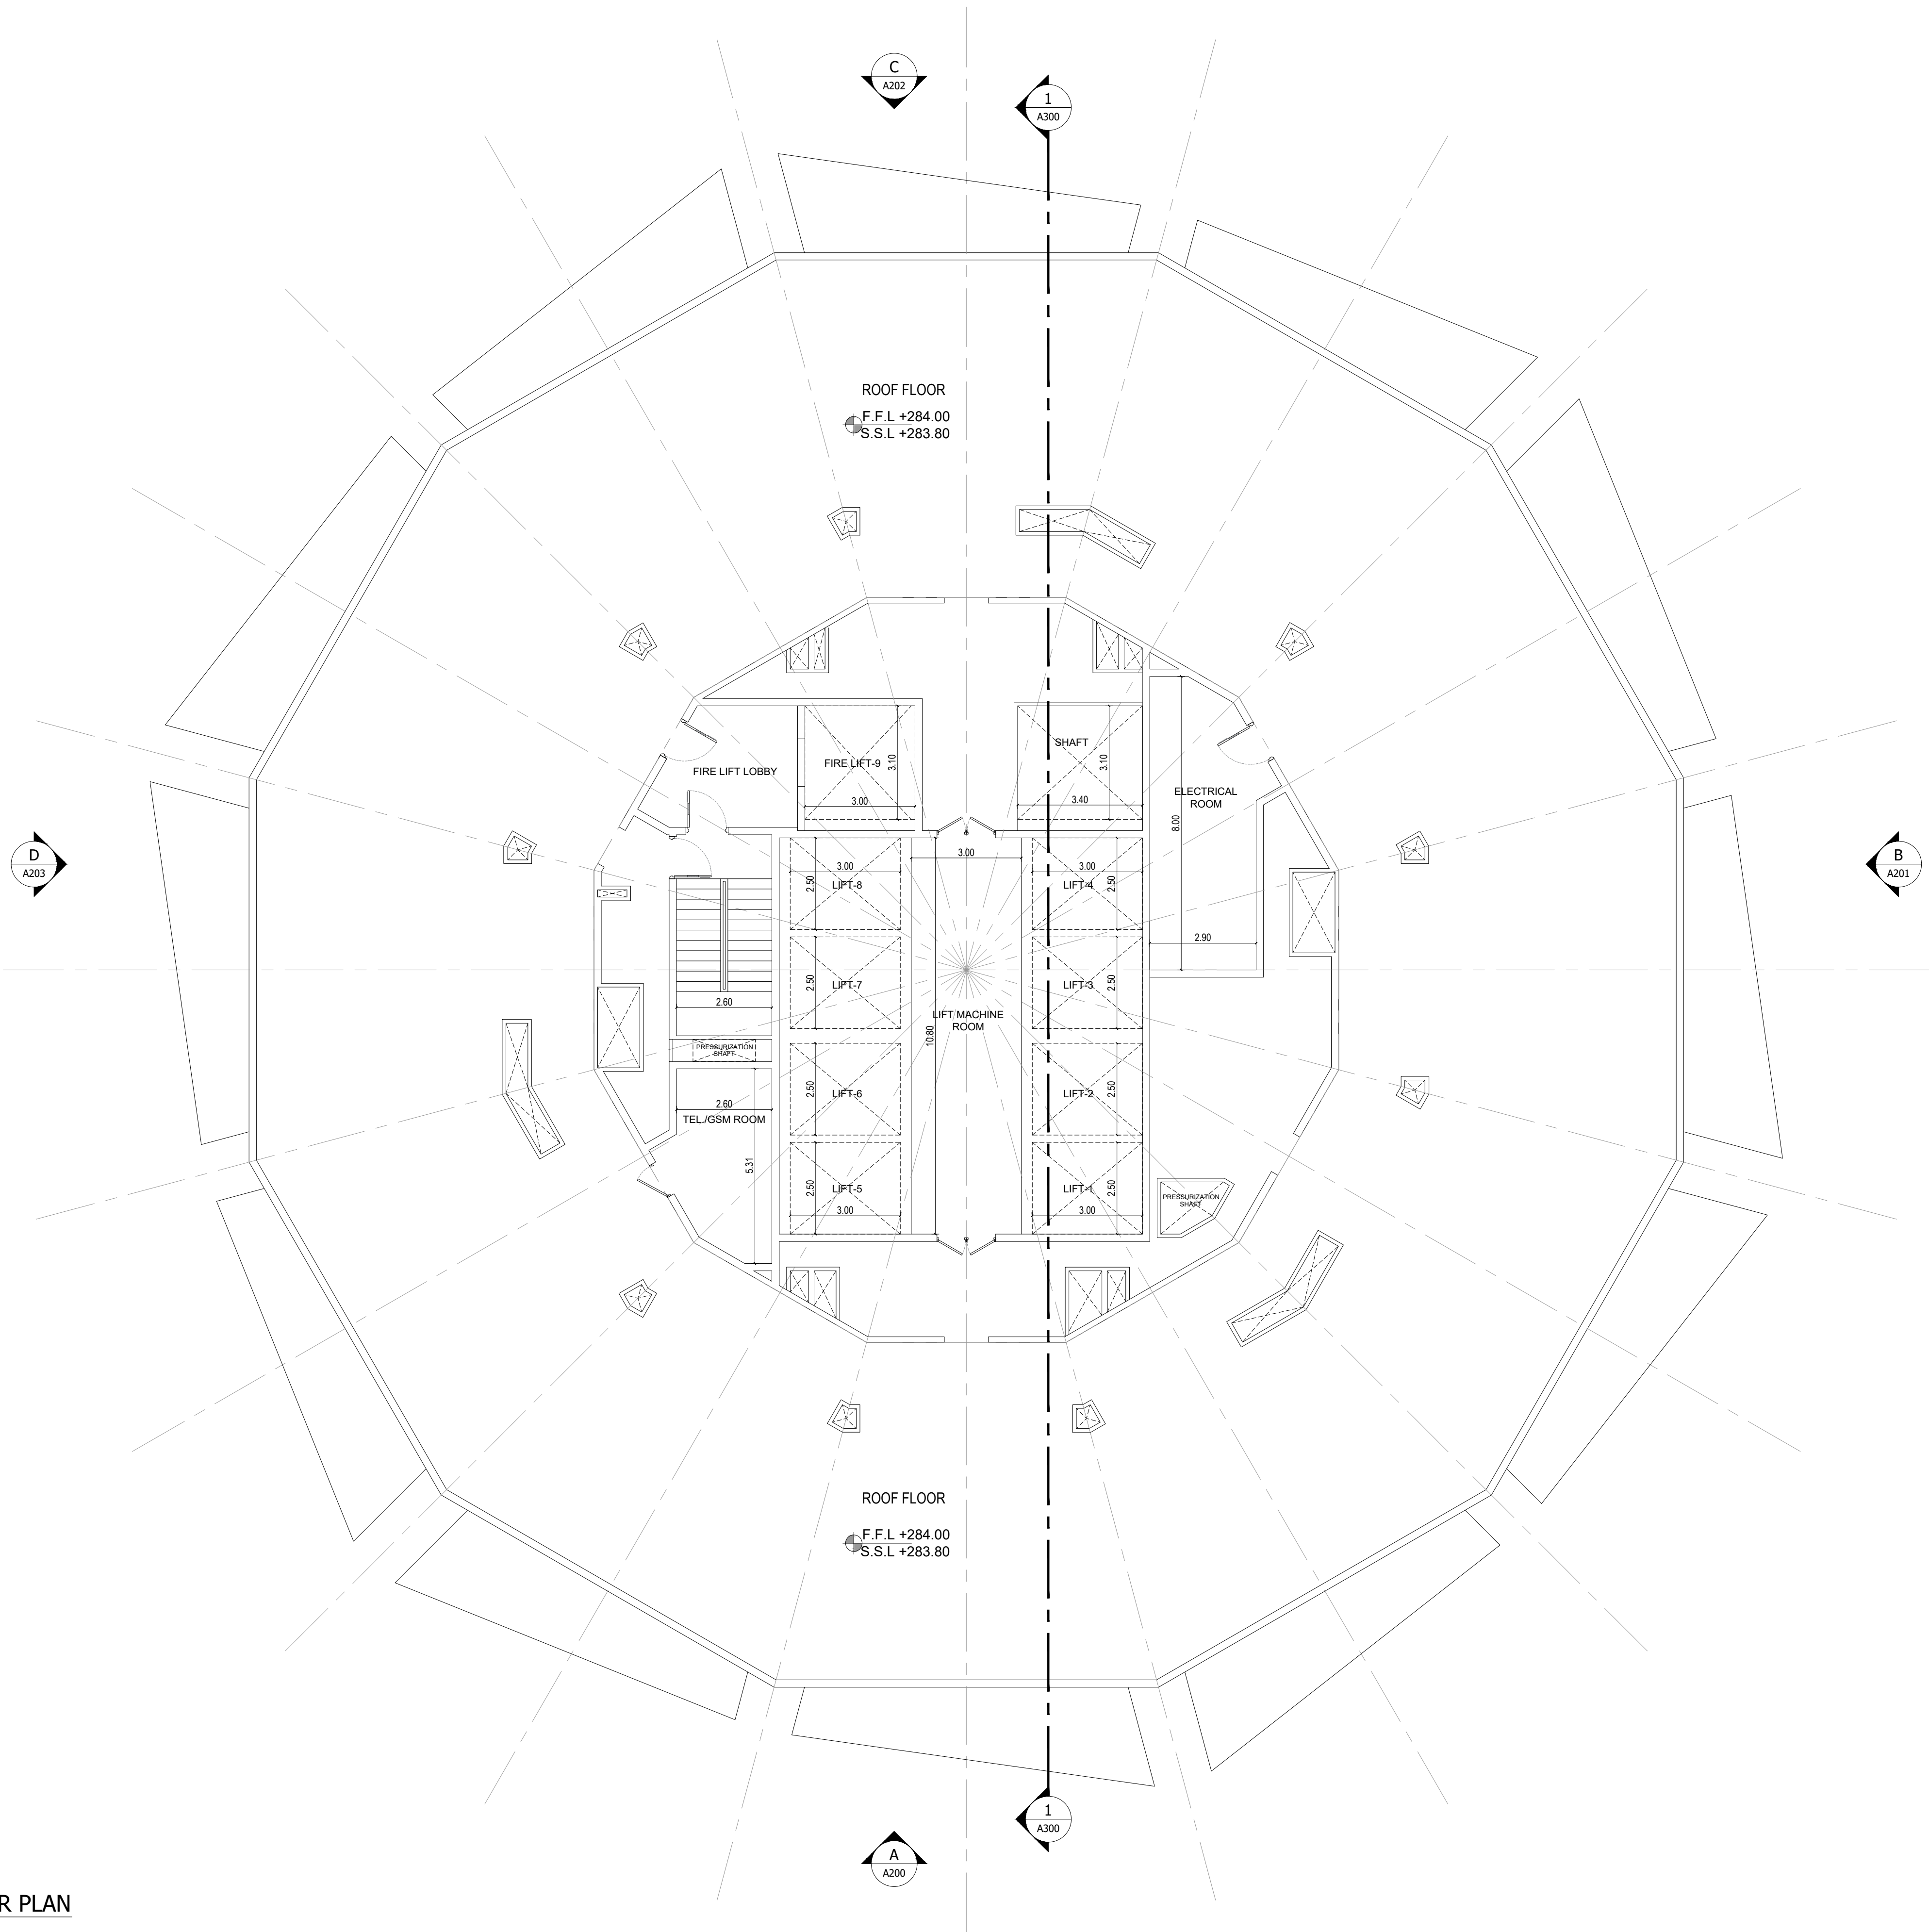

APPROVAL STAMP:

NOTES:

- 1.) ALL DIMENSIONS TO BE VERIFIED BY CONTRACTOR ON SITE PRIOR TO COMMENCEMENT OF ANY WORK.
- 2.) DO NOT SCALE THIS DRAWING FOR THE PURPOSE OF MEASUREMENT. ONLY SCALE DIMENSIONS WHERE SPECIFICALLY INSTRUCTED TO DO SO.
- 3.) ALL MEASUREMENTS ARE IN MILLIMETERS UNLESS OTHERWISE SPECIFIED.
- 4.) DIMENSIONS SHOWN ON THESE DRAWINGS ARE STRUCTURAL DIMENSIONS UNLESS CLEARLY NOTED OTHERWISE.
- 5.) THIS DRAWING IS TO BE READ IN CONJUNCTION WITH ALL OTHER DRAWINGS, DETAIL AND SPECIFICATIONS. ANY DISCREPANCY TO BE IMMEDIATELY BROUGHT TO THE ATTENTION OF ARCHITECT PRIOR TO COMMENCING THE WORKS.

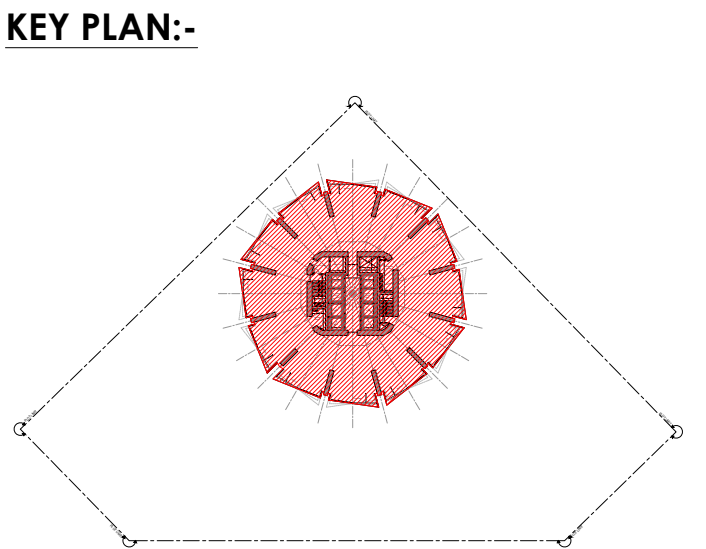

GATE LEVEL PROPOSED = (±0.00 m.) = +15.45 m. DMD LVL.

REV	DATE	DESCRIPTION	CHECK

STATUS : PRELIMINARY SUBMISSION

OWNER: ARGENTI PROPERTIES INVESTMENTS LTD



CONSULTANT: SILVER STONE ENGINEERING CONSULTANTS

PROJECT : BINGHATTI CIRCLE
2B + G + 4P + S8 TYP. FLOORS +3 MECH.+3 STR.+ ROOF

PLOT NO: JVC13RHRG001	LOCATION: AL BARSHA SOUTH FOURTH(681)
ARCH: AMAR M	STR Engg: M FLAHA
Reg. No: 114763	Reg. No: 109115
SCALE:	DRAWN: MUS
CHECKED & APPROVED: AM	

DRAWING TITLE: ROOF FLOOR PLAN


PROJECT NO: P025-01	DWG NO: A124	REV: 00
-------------------------------	------------------------	-------------------

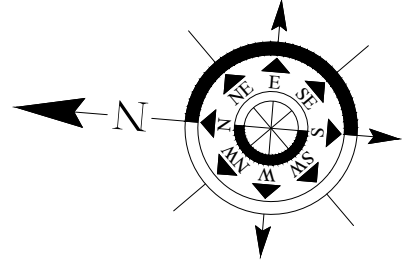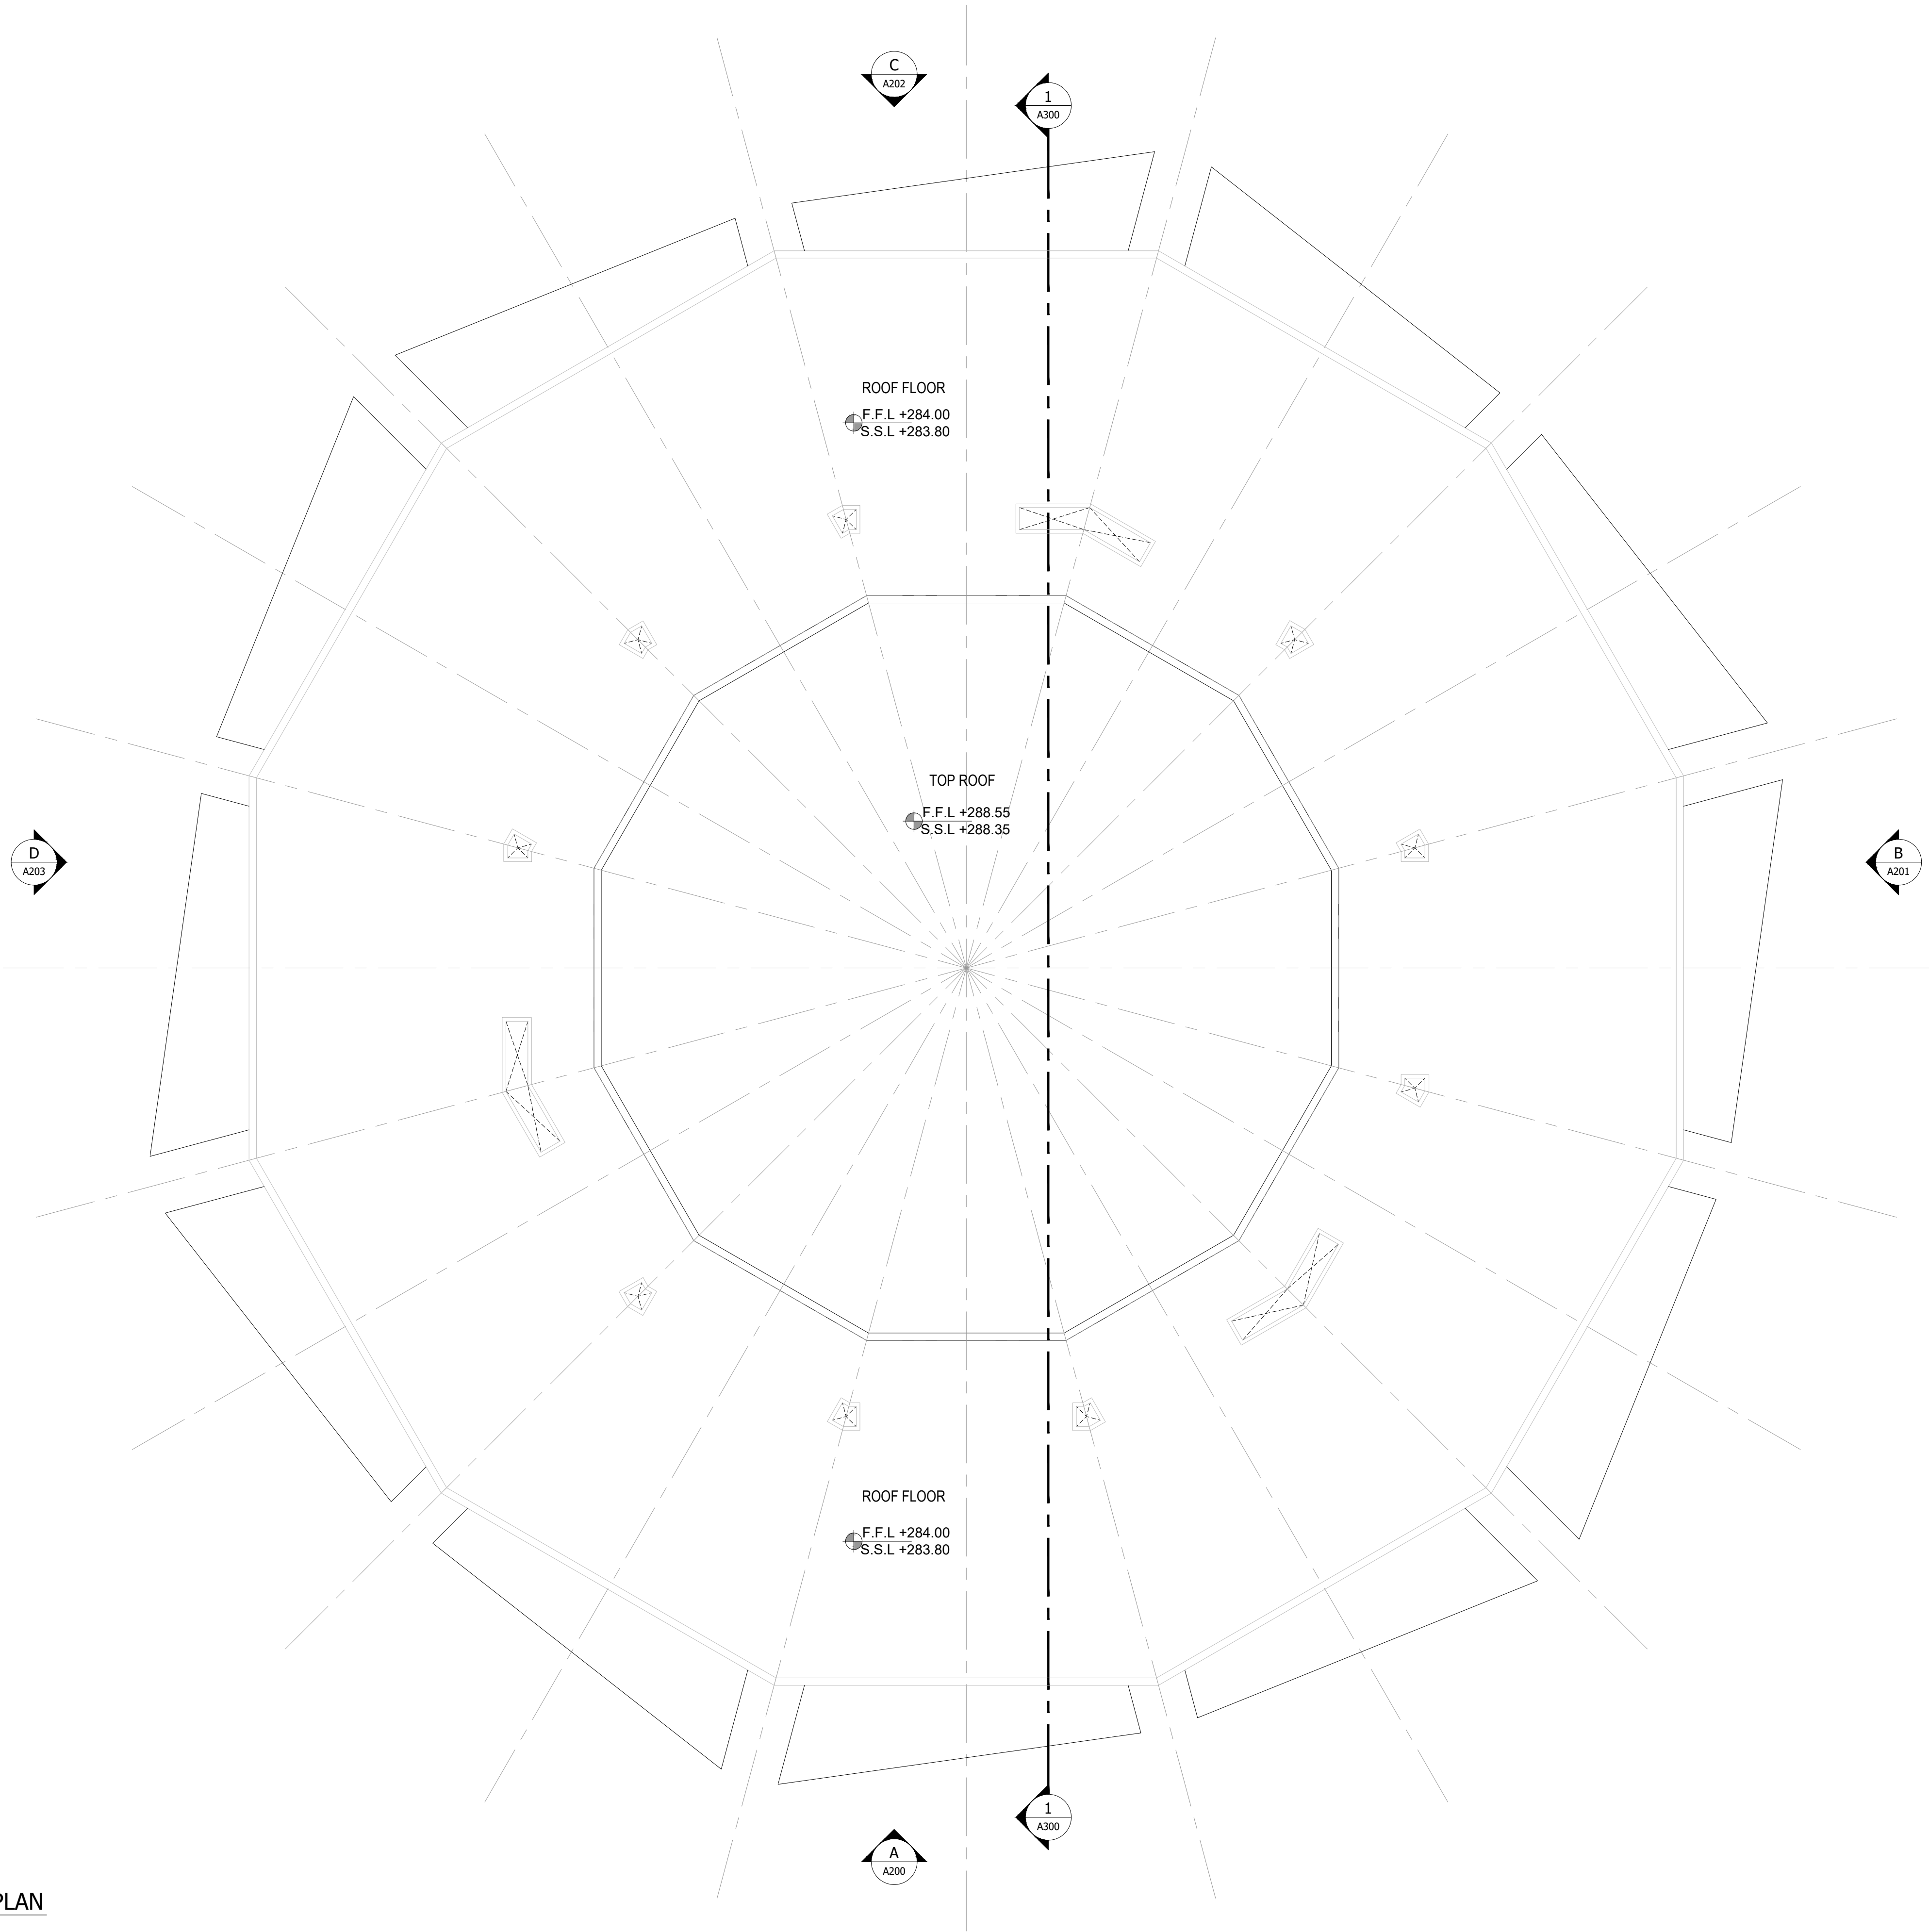

APPROVAL STAMP:

- NOTES:
- 1.) ALL DIMENSIONS TO BE VERIFIED BY CONTRACTOR ON SITE PRIOR TO COMMENCEMENT OF ANY WORK.
 - 2.) DO NOT SCALE THIS DRAWING FOR THE PURPOSE OF MEASUREMENT. ONLY SCALE DIMENSIONS WHERE SPECIFICALLY INSTRUCTED TO DO SO.
 - 3.) ALL MEASUREMENTS ARE IN MILLIMETERS UNLESS OTHERWISE SPECIFIED.
 - 4.) DIMENSIONS SHOWN ON THESE DRAWINGS ARE STRUCTURAL DIMENSIONS UNLESS CLEARLY NOTED OTHERWISE.
 - 5.) THIS DRAWING IS TO BE READ IN CONJUNCTION WITH ALL OTHER DRAWINGS. DETAIL AND SPECIFICATIONS. ANY DISCREPANCY TO BE IMMEDIATELY BROUGHT TO THE ATTENTION OF ARCHITECT PRIOR TO COMMENCING THE WORKS.

KEY PLAN:-

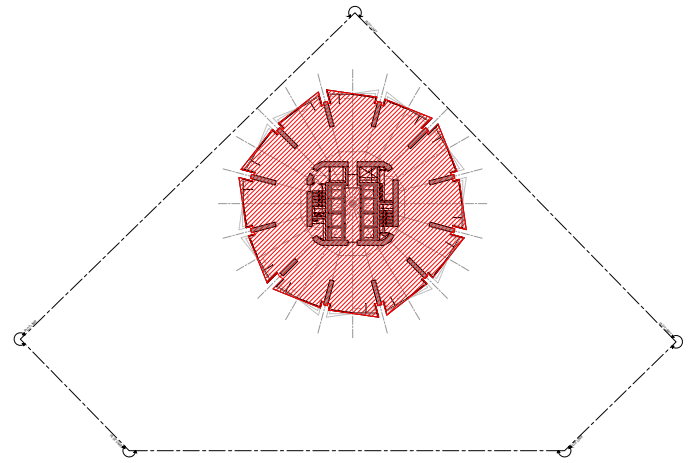

GATE LEVEL PROPOSED = (±0.00 m.) = +15.45 m. DMD LVL.

REV	DATE	DESCRIPTION	CHECK

STATUS :
PRELIMINARY SUBMISSION

OWNER:
ARGENTI PROPERTIES INVESTMENTS LTD

CONSULTANT:
SILVER STONE ENGINEERING CONSULTANTS

PROJECT :
BINGHATTI CIRCLE

PLOT NO: JVC13RHRG001	LOCATION: AL BARSHA SOUTH FOURTH(681)
ARCH: AMAR M	STR Engg: M FLAHA
Reg. No: 114763	Reg. No: 109115
SCALE: 1:100	CHECKED & APPROVED: AM

DRAWING TITLE:
TOP ROOF PLAN

PROJECT NO: P025-01	DWG NO: A125	REV: 00
-------------------------------	------------------------	-------------------

1 TOP ROOF PLAN
A125 SCALE - 1:100

File Path: X:\Binghatti Project\025-01-Binghatti Circle\01- ARCHITECTURE\01- CONCEPT\01- DWG- Prit Date: 12-Jun-25, Time: 10:23:34 AM