


Floor 4 to floor 6 3 Bed units

Burj Khalifa view

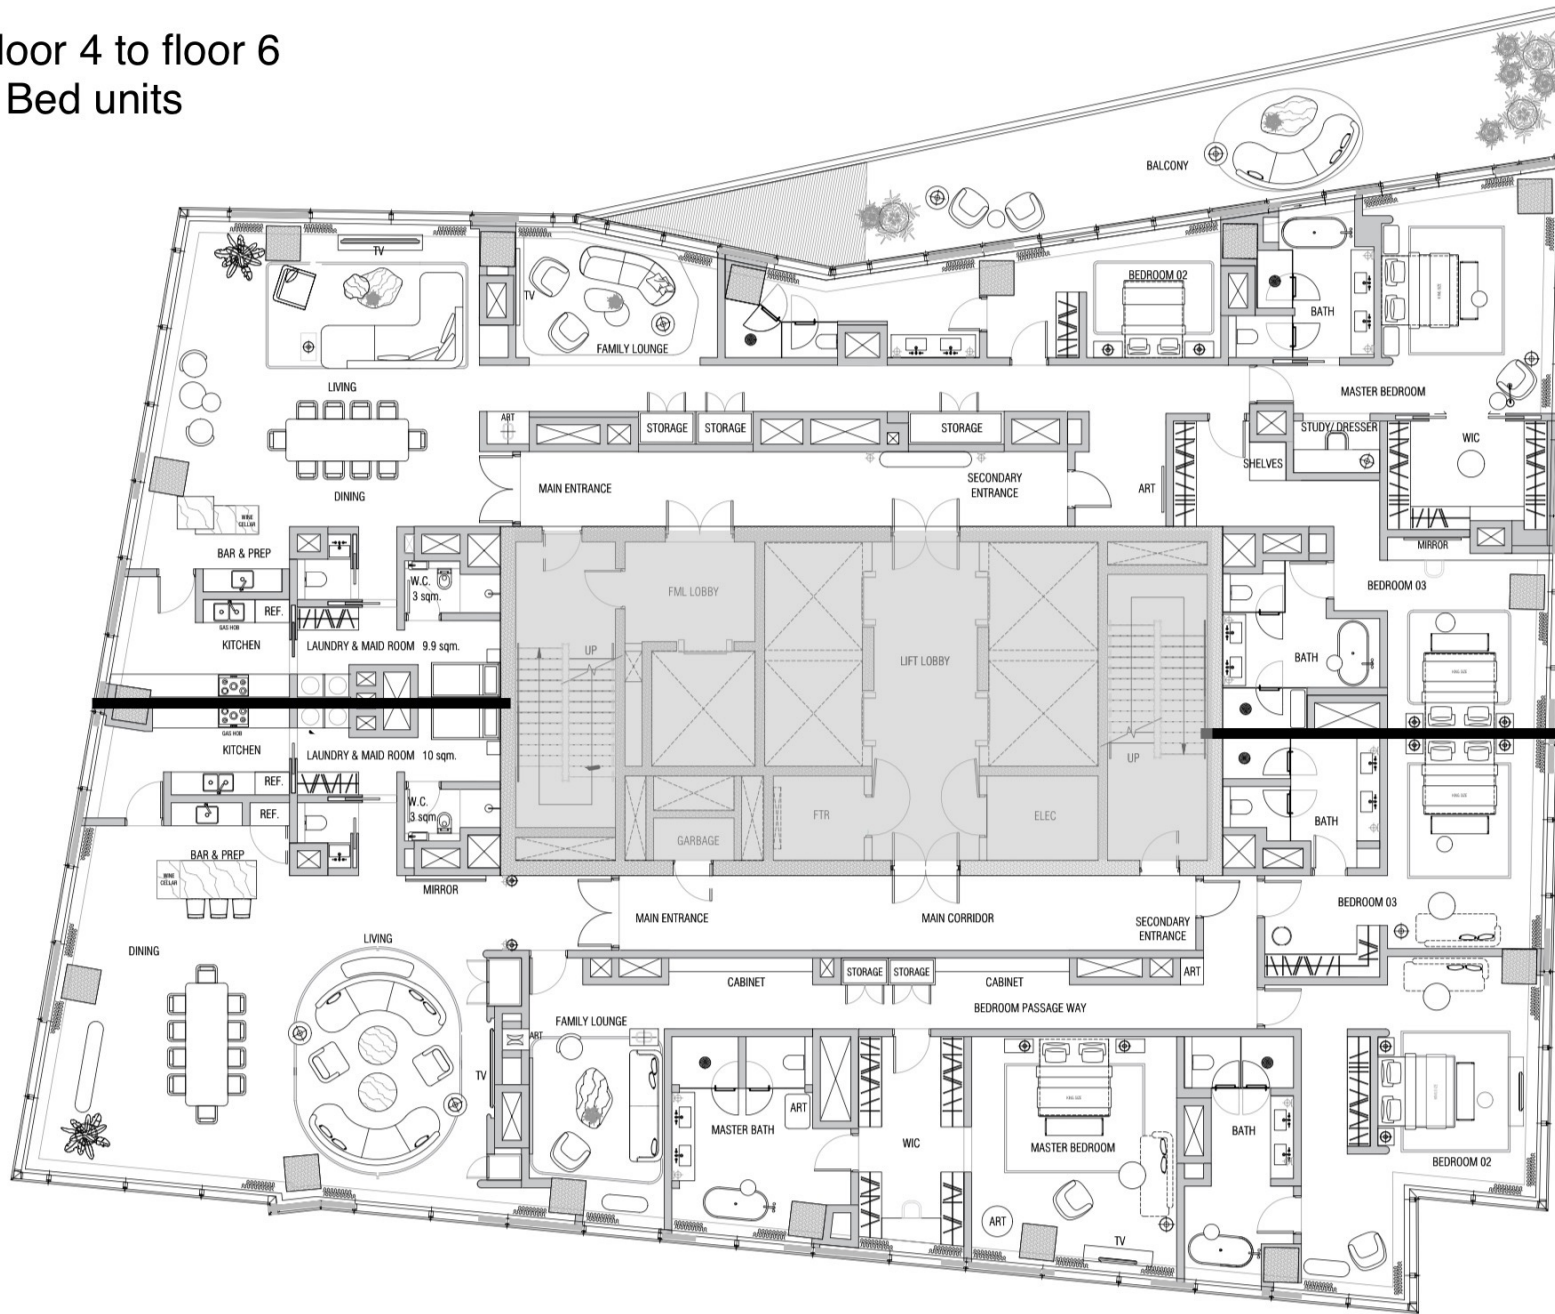

APPROVAL
2. DESIGN / DRAWING IS NOT TO BE SCALED FOR PRODUCTION AND CONSTRUCTION PURPOSES.
3. ALL MEASUREMENTS AND DIMENSIONS ON THIS MUST BE REFERRED TO DESIGNER FOR THEIR COMMENTS OF APPROVAL PRIOR TO COMMENCING WORK.
4. ALL ELECTRICAL, LIGHTING, HVAC AND PLUMBING ISSUES TO BE REFERRED TO ENGINEERING DRAWINGS PRIOR TO COMMENCING WORK.
5. THE DESIGNER AND SUBJECT TO APPROVAL BY STATUTORY AUTHORITIES AND ANY NECESSARY ALTERATIONS SHOULD BE MADE IF REQUIRED TO COMPLY WITH STATUTORY REQUIREMENTS.
6. ALL DESIGN CONCEPTS AND DRAWINGS ARE THE PROPERTY OF 1508 LONDON AND ARE COVERED BY COPYRIGHT. NO REPRODUCTIONS, ADAPTATIONS, OR OTHER COPIES MAY BE MADE WITHOUT WRITTEN PERMISSION BY 1508 LONDON.

Revisions	Rev.	Date	Comment
0	31/10/23		50% SCHEMATIC DESIGN ISSUE

Key Plan


Project: BACCARAT HOTEL 2
Status: STAGE 3
Drawing Pkg: GA, GENERAL ARRANGEMENTS
Drawing Name: 3 Bedrooms unit / S. 04 to floor 06
Date Issued: 31/10/23 Scale: 1:50 @ A0
Drawn by: CMJ Amended by: CMJ Checked by: AT
Drawing Number: 22022_GA_R2_0400 Revision:

1508
LONDON

WORK-IN-PROGRESS

Burj Khalifa view

Floor 7 to floor 11
3bed

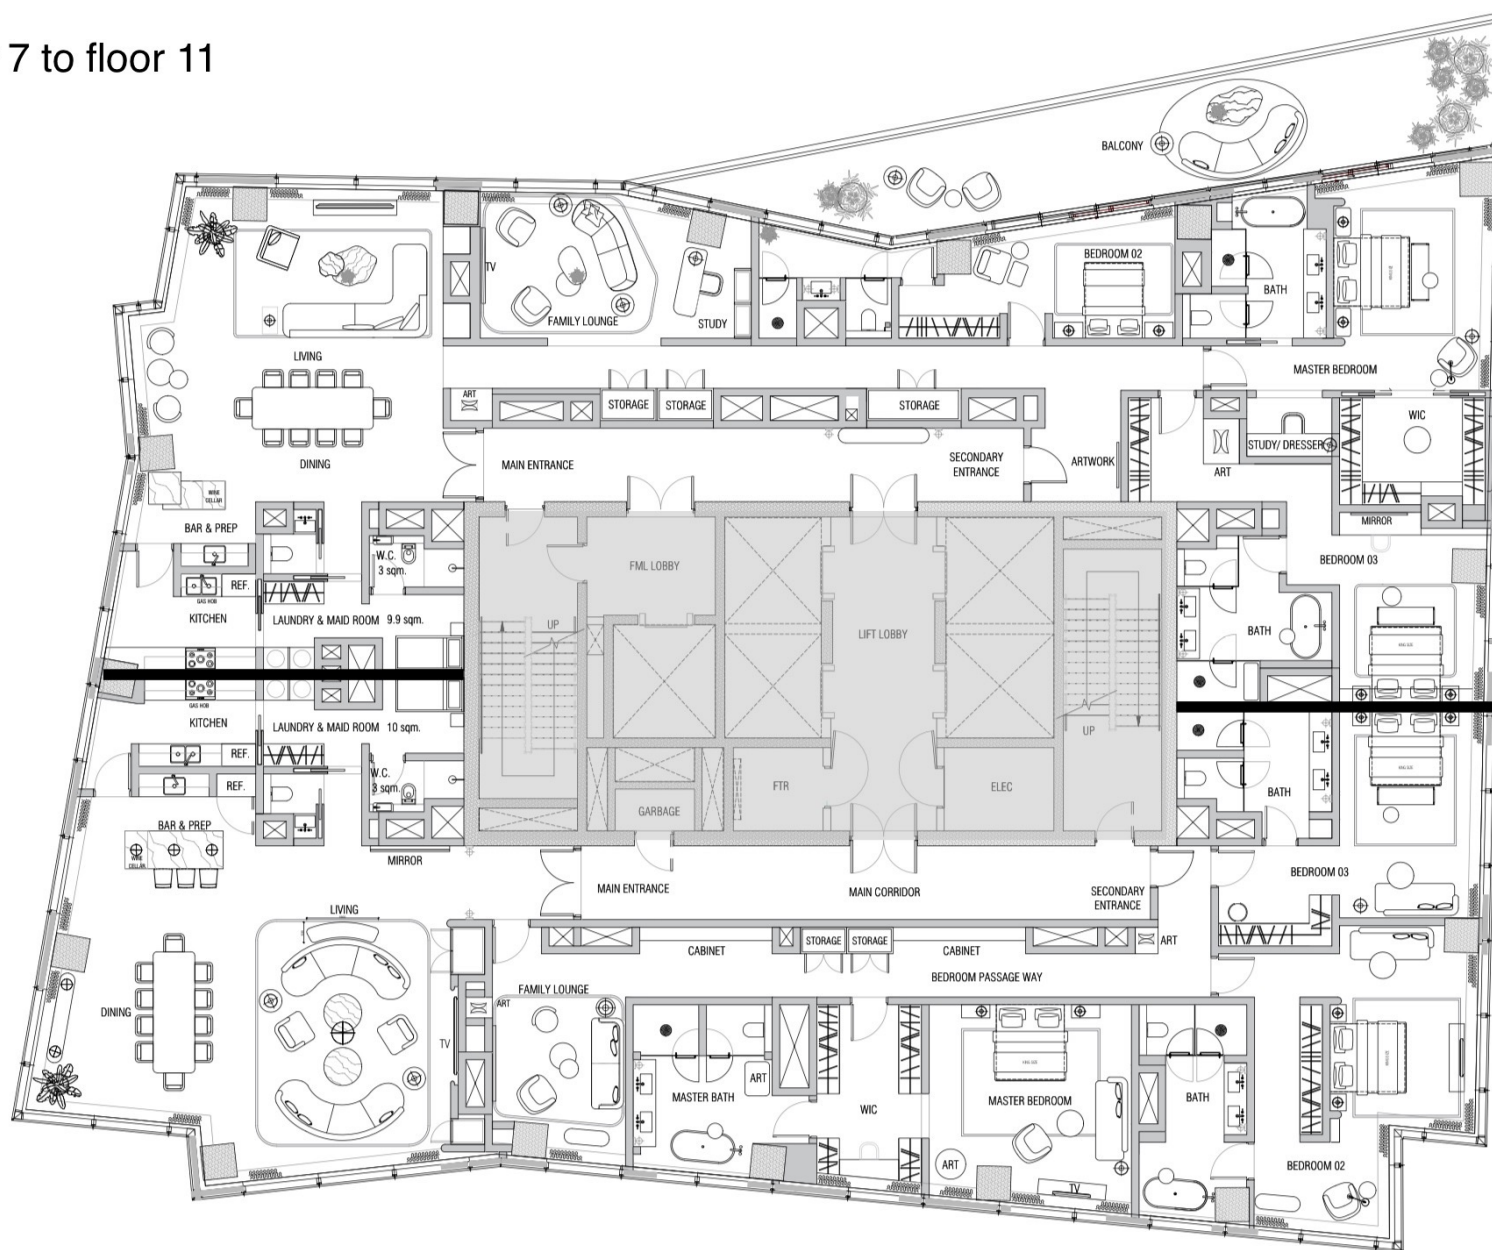

Notes

1. THE DRAWING SHOWS DESIGN INTENT ONLY. ALL DIMENSIONS TO BE CHECKED ON SITE PRIOR TO COMMENCEMENT OF CONSTRUCTION. CONSTRUCTION DETAILS TO BE CONFIRMED BY THE CONTRACTOR MANUFACTURER BY SUBMITTING SHOP DRAWINGS FOR THE DESIGNER'S APPROVAL.
2. DESIGN / DRAWING IS NOT TO BE SCALED FOR PRODUCTION AND CONSTRUCTION PURPOSES.
3. ALL DIMENSIONS AND CONDITIONS ON SITE MUST BE REPORTED TO THE DESIGNER PRIOR TO COMMENCEMENT OF WORK.
4. ALL ELECTRICAL, LIGHTING, HVAC AND PLUMBING DETAILS TO BE REFERRED TO THE ENGINEER'S DRAWINGS PRIOR TO COMMENCEMENT OF WORK.
5. THE DESIGN IS SUBJECT TO APPROVAL BY STATUTORY AUTHORITIES AND ANY NECESSARY ALTERATIONS SHOULD BE MADE IF REQUIRED TO COMPLY WITH STATUTORY REQUIREMENTS.
6. ALL DESIGN CONCEPTS AND DRAWINGS ARE THE PROPERTY OF THE CLIENT AND ARE COVERED BY COPYRIGHT. NO REPRODUCTION, ADAPTATION, REUSE OR OTHER USE MAY BE MADE WITHOUT WRITTEN PERMISSION BY THE CLIENT.

Rev	Date	Comment
1	31/10/23	50% SCHEMATIC DESIGN ISSUE

Key Plan

Project: BACCARAT HOTEL 2

Status: STAGE 3

Drawing File: GA_GENERAL ARRANGEMENTS

Drawing Name: 3 Bedrooms unit / R. 07 to R. 11

Date Issued: 31/10/23 Scale: 1:50 @ A0

Drawn by: CM Checked by: AT


Drawing Number: 22022_GA_R2_0700

1508 LONDON

ARCHITECTS & INTERIORS DESIGN

AND THE LONDON & LONDON


Burj Khalifa view

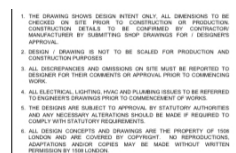

Key Plan

1508
LONDON
ADVERTISING & PROMOTION
DVD PLAYS - 7 RECORD PLAYS - 6000-200

Burj Khalifa view

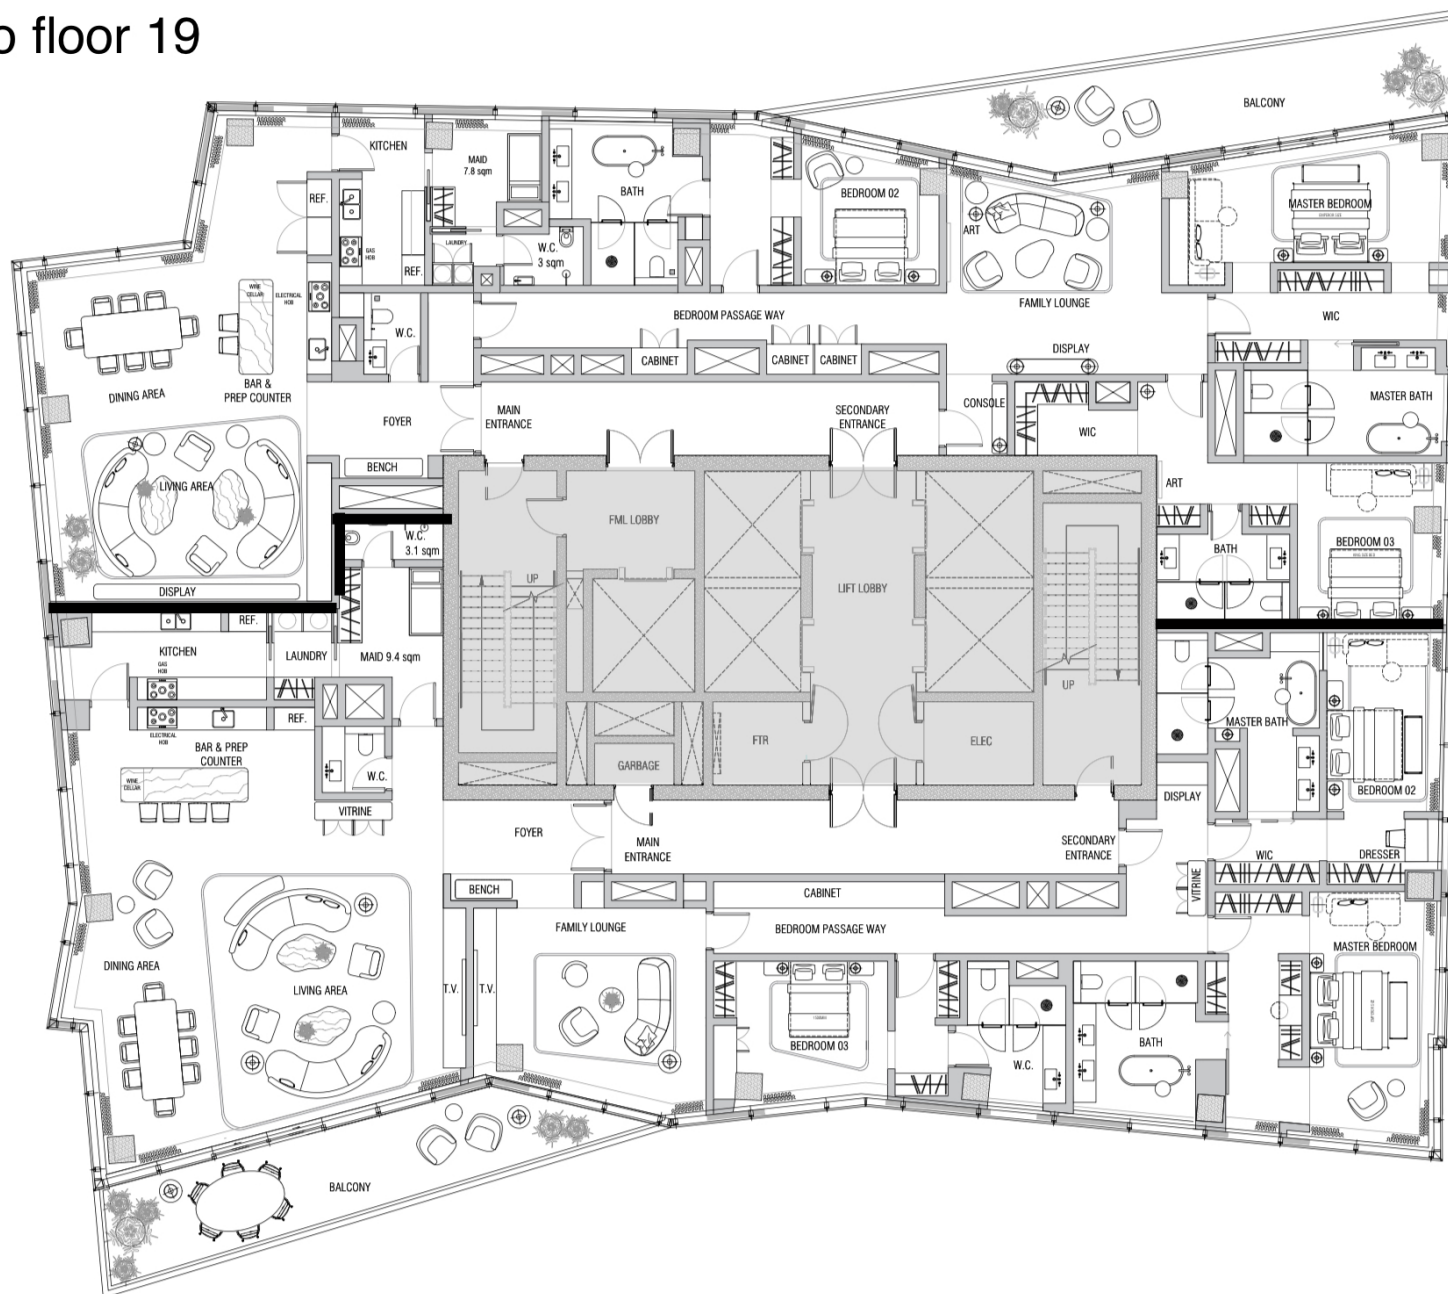

Notes
1. THE DRAWING'S SCOPE DESIGN INTENT ONLY. ALL DIMENSIONS TO BE CHECKED ON SITE PRIOR TO CONSTRUCTION OR PRODUCTION OF CONSTRUCTION DETAILS TO BE CONFIRMED BY CONTRACTOR/MANUFACTURER BY SUBMITTING SHOP DRAWINGS FOR 1 DESIGNER APPROVAL.
2. DESIGN 1 DRAWING IS NOT TO BE SCALED FOR PRODUCTION AND CONSTRUCTION PURPOSES.
3. ALL DISCREPANCIES AND OMISSIONS ON SITE MUST BE REPORTED TO DESIGNER FOR THEIR COMMENTS OR APPROVAL PRIOR TO COMMENCEMENT OF WORKS.
4. ALL ELECTRICAL LIGHTING, HVAC AND FLUVA/ISSUES TO BE REFERRED TO ENGINEER'S DRAWINGS PRIOR TO COMMENCEMENT OF WORKS.
5. THE DESIGN IS SUBJECT TO APPROVAL BY STATUTORY AUTHORITIES AND ANY NECESSARY ALTERATIONS SHOULD BE MADE IF REQUIRED TO COMPLY WITH STATUTORY REQUIREMENTS.
6. ALL DESIGN CONCEPTS AND DRAWINGS ARE THE PROPERTY OF HS HOLDINGS AND ARE COVERED BY COPYRIGHT. NO REPRODUCTION, ADAPTATIONS AND/OR COPIES MAY BE MADE WITHOUT WRITTEN PERMISSION FROM HS HOLDINGS.

Revisions		
Rev.	Date	Comment
0	31/10/23	50% SCHEMATIC DESIGN ISSUE

Key Plan


Project:	BACCARAT HOTEL 2		
Status:	STAGE 3		
Drawing Pkg:	GA_GENERAL ARRANGEMENTS		
Drawing Name:	3 Bedrooms unit / fl. 18 to fl. 19		
Date Issued:	31/10/23	Scale:	1:50 @ A0
Drawn by:	CM	Amended by:	CM
		Checked by:	AT
Drawing Number:	22022_GA_R2_1800		Revision:

1508
LONDON

WORK-IN-PROGRESS

Burj Khalifa view

Floor 20 to floor 23 3/4 Bed

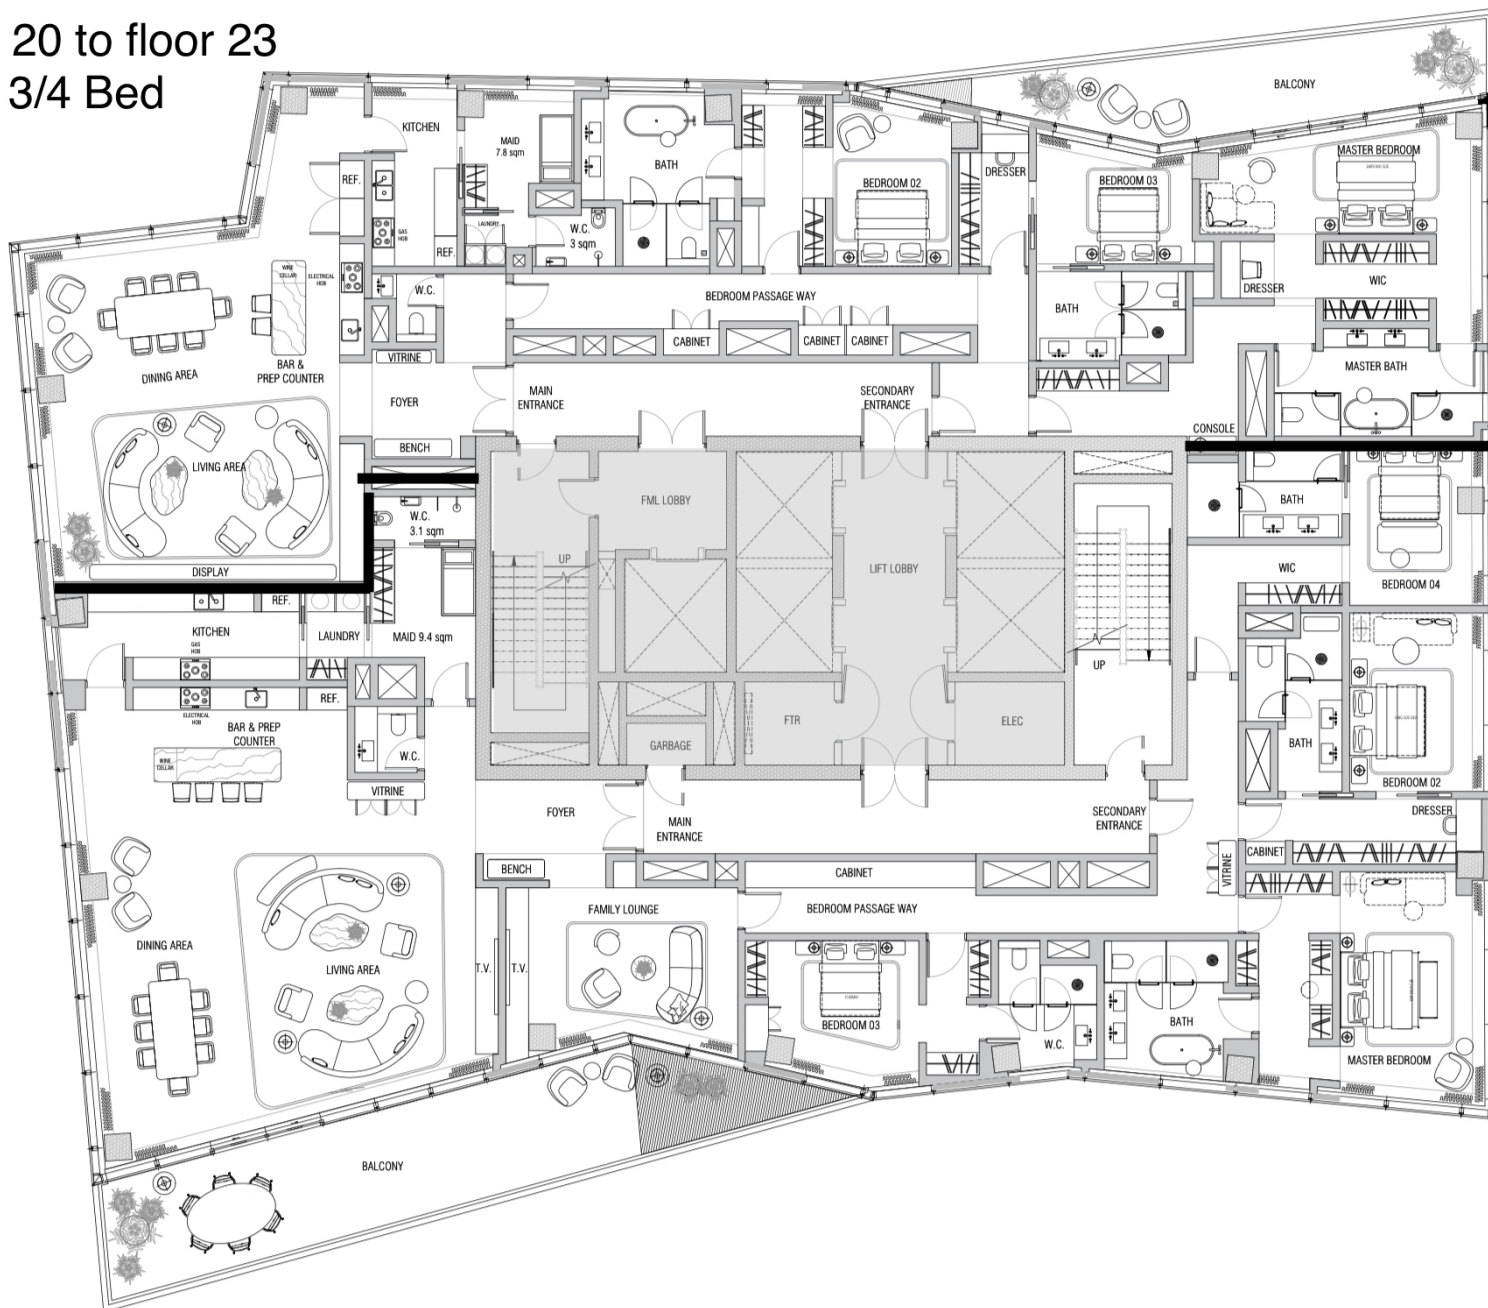

Notes

1. THE DRAWING SHOWS DESIGN INTENT ONLY. ALL DIMENSIONS TO BE CHECKED ON SITE PRIOR TO CONSTRUCTION. ON PRODUCTION CONSTRUCTION DETAILS TO BE COMPLETED BY CONTRACTOR MANUFACTURER BY SUBMITTING SHOP DRAWINGS FOR / DESIGNER'S APPROVAL.
2. DESIGN / DRAWING IS NOT TO BE SCALED FOR PRODUCTION AND CONSTRUCTION PURPOSES.
3. ALL DISCREPANCIES AND CHANGES ON SITE MUST BE REPORTED TO DESIGNER FOR THEIR COMMENTS OR APPROVAL PRIOR TO COMMENCEMENT OF WORK.
4. ALL ELECTRICAL, LIGHTING, HVAC AND PLUMBING ISSUES TO BE REFERRED TO ENGINEERS DRAWINGS PRIOR TO COMMENCEMENT OF WORK.
5. THE DESIGN IS SUBJECT TO APPROVAL BY STATUTORY AUTHORITIES AND ANY NECESSARY ALTERATIONS SHOULD BE MADE IF REQUIRED TO COMPLY WITH STATUTORY REQUIREMENTS.
6. ALL DESIGN CONCEPTS AND DRAWINGS ARE THE PROPERTY OF THIS FIRM AND ARE COVERED BY COPYRIGHT. NO REPRODUCTION, ADAPTATION AND/OR COPIES MAY BE MADE WITHOUT WRITTEN PERMISSION BY THE FIRM.


Rev.	Date	Comment
0	31/10/23	50% SCHEMATIC DESIGN ISSUE

Key Plan

Project: BACCARAT HOTEL 2
 Status: STAGE 3
 Drawing Pkg: GA, GENERAL ARRANGEMENTS
 Drawing Name: 3&4 Bedrooms unit / F. 20 to F.23
 Date Issued: 31/10/23 Scale: 1:50 @ A3
 Drawn by: CM Checked by: AT
 Drawing Number: 22022_GA_R2_2000 Revision:

DRAFT

Floor 26 floor 27 4 Bed penthouses

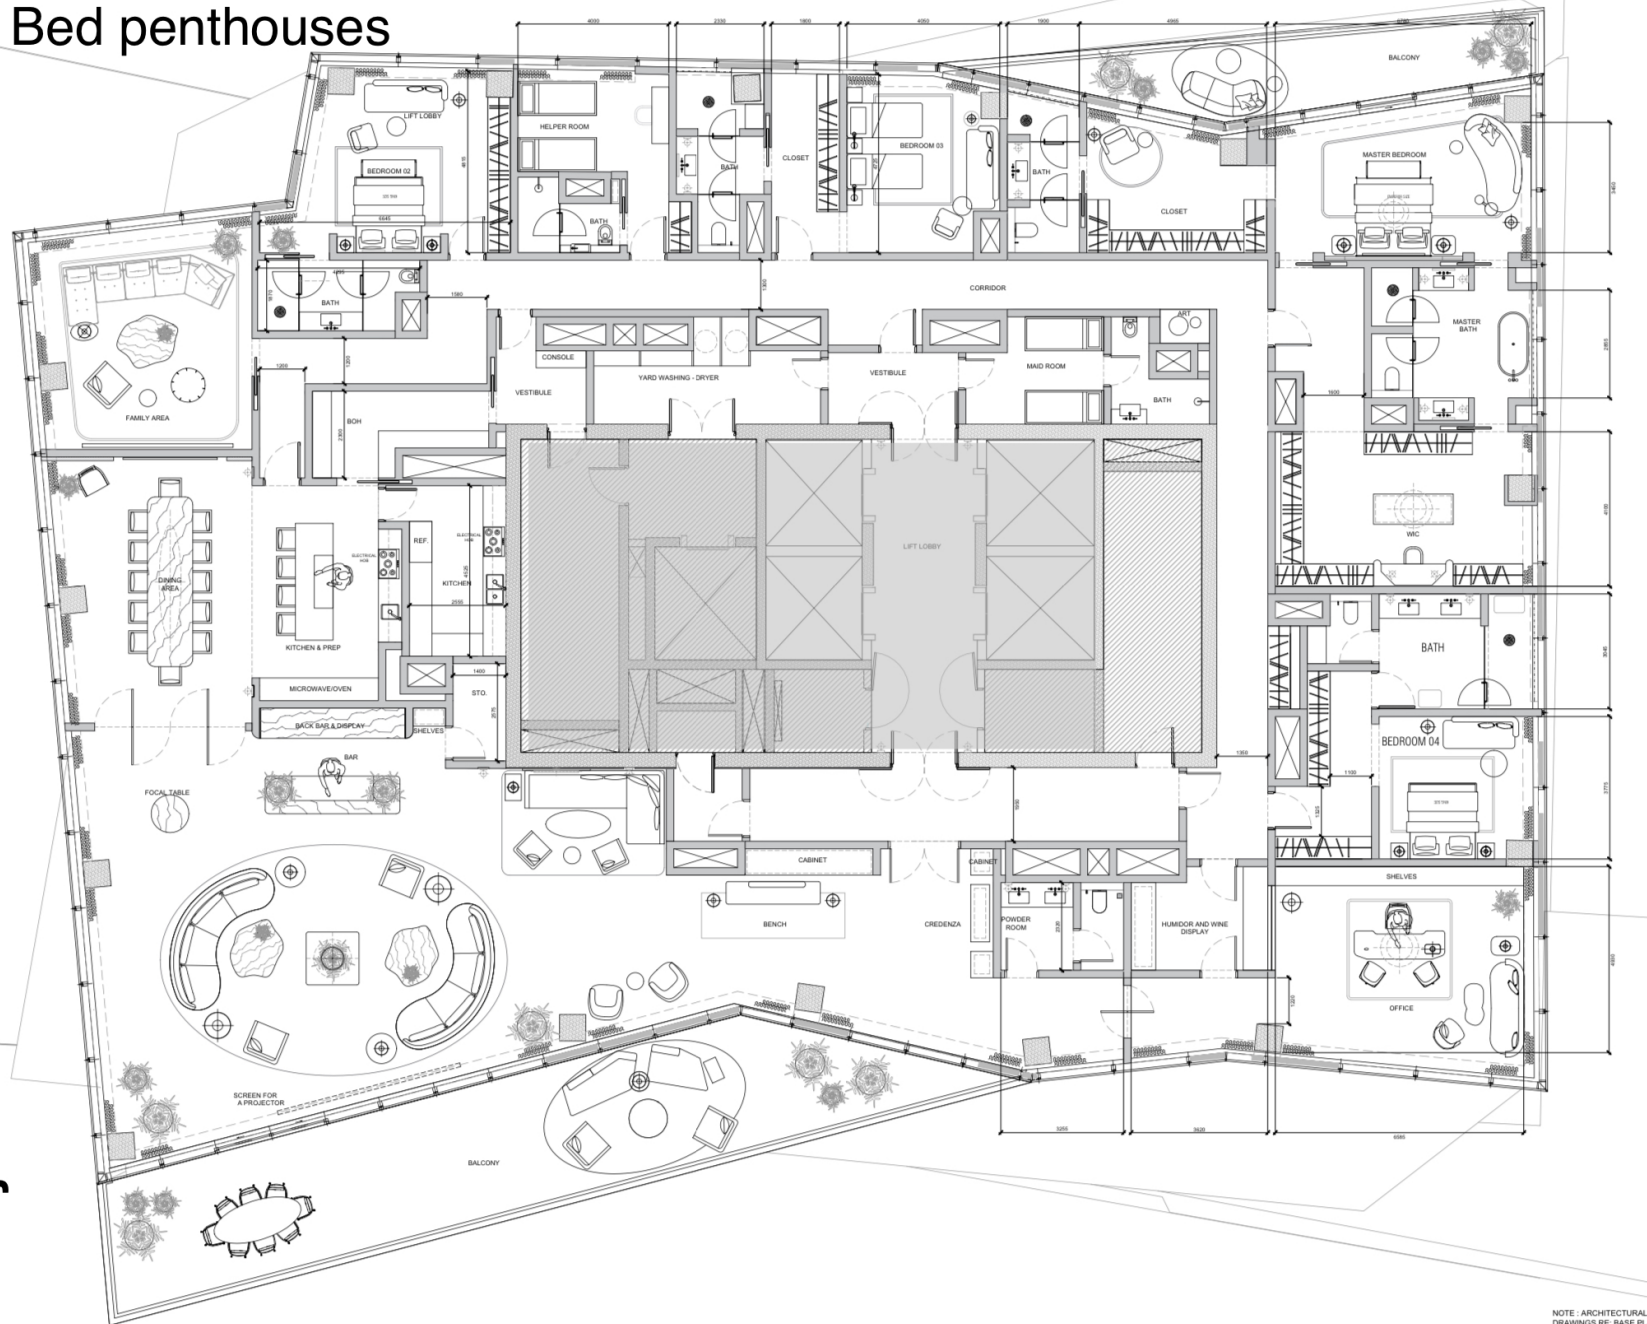

1. THE DRAWING SHOWN REPRESENTS ONLY. ALL DIMENSIONS TO BE CHECKED ON SITE PRIOR TO CONSTRUCTION OR PRODUCTION. CONSTRUCTION OF THE SITE MUST BE REPORTED TO THE ARCHITECT PRIOR TO COMMENCING WORK.
2. DESIGN / DRAWING IS NOT TO BE SCALED FOR PRODUCTION AND CONSTRUCTION PURPOSES.
3. ALL DISCREPANCIES AND OMISSIONS ON SITE MUST BE REPORTED TO THE ARCHITECT PRIOR TO COMMENCING WORK.
4. ALL ELECTRICAL, LIGHTING, HVAC AND PLUMBING ISSUES TO BE REFERRED TO ENGINEERS DRAWINGS PRIOR TO COMMENCING OF WORK.
5. THE DESIGN AND DRAWING ARE THE PROPERTY OF THE ARCHITECT AND ARE NOT TO BE REPRODUCED OR COPIED IN ANY FORM OR BY ANY MEANS WITHOUT THE WRITTEN PERMISSION OF THE ARCHITECT.
6. ALL DESIGN CONCEPTS AND DRAWINGS ARE THE PROPERTY OF THE ARCHITECT AND ARE NOT TO BE REPRODUCED OR COPIED IN ANY FORM OR BY ANY MEANS WITHOUT THE WRITTEN PERMISSION OF THE ARCHITECT.

Rev	Date	Comment
0	31/11/23	50% DEVELOPED DESIGN
A	30/11/23	100% DEVELOPED DESIGN

Key Plan

Project:	BACCARAT HOTEL 2
Status:	STAGE 3
Drawing Pkg:	GA GENERAL ARRANGEMENTS
Drawing Name:	4 BEDROOMS PENTHOUSE UNIT FL 26 FL 27
Date Issued:	30/11/23
Scale:	1:50 @ A0
Drawn by:	CM
Checked by:	AT
Drawing Number:	22022_GA_R2_2600

NOTE: ARCHITECTURAL BACKGROUND AS PER RECEIVED BASIC DRAWINGS RE: BASE PLAN 24 NOVEMBER 2023

WORK-IN-PROGRESS